




LUCAN BIDDULPH COMMUNITY MEMORIAL CENTER

PHASE 2: LUCAN ARENA RENOVATION'S AND ADDITION

263 & 265 MAIN STREET, LUCAN, ONTARIO



LUCAN BIDDULPH
COMMUNITY MEMORIAL
CENTER.

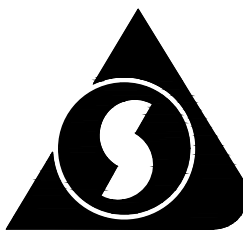

SPRIET ASSOCIATES

architects - engineers

155 york street - london - N6A 1A8

phone : (519) 672-4100 fax : (519) 433-9351

e-mail : mail@spriet.on.ca

ARCHITECT, STRUCTURAL
ENGINEER, CIVIL ENGINEER &
PRIME CONSULTANT



Callidus

Engineering

A Division of 1640286 Ontario Inc.

1385 North Routledge Park, Unit 9 - London, ON N6H 5N5

P: 519-472-7640 F: 519-471-9239 E: info@callidus.ca

MECHANICAL & ELECTRICAL
ENGINEERS

ISSUED FOR CONSTRUCTION – FEB. 02, 2022
ISSUED FOR PERMIT – FEB. 01, 2022
ISSUED FOR TENDER – DEC. 01, 2021

TOWNSHIP OF LUCAN BIDDULPH
(OWNER)

TONDA CONSTRUCTION LIMITED
(CONTRACTOR)

ARCHITECTURAL DRAWINGS LIST:

- COVER PAGE
- SP1 DEMOLITION PLAN
SP2 ARCHITECTURAL PLAN
SP3 SITE SERVICING AND GRADING PLAN
SP4 DETAILS AND NOTES
SP5 DETAILS
D1 ENLARGED GROUND DEMOLITION PLAN
D2 ENLARGED SECOND DEMOLITION PLAN
D3 DEMOLITION ELEVATIONS
A1 GENERAL NOTES, MOUNTING HEIGHTS
BUILDING CODE MATRIX
A2 OVERALL GROUND FLOOR PLAN
A3 OVERALL SECOND FLOOR PLAN
A4 OVERALL ROOF PLAN
A5 ENLARGED GROUND FLOOR PLAN
A6 ENLARGED FLOOR PLANS
A7 ENLARGED FLOOR PLANS
A7.1 DETAILS
A8 ENLARGED FLOOR PLANS
A9 GROUND FLOOR RCP
A10 SECOND FLOOR RCP
A11 BUILDING SECTIONS
A12 SECTIONS
A13 SECTIONS
A14 SECTIONS
A15 INTERIOR ELEVATIONS
A16 INTERIOR ELEVATIONS
A17 INTERIOR ELEVATIONS
A18 DOOR FRAME AND
HARDWARE SCHEDULE
A19 ROOM FINISH SCHEDULE
A20 EXTERIOR ELEVATIONS

STRUCTURAL DRAWINGS LIST:



- S1 STRUCTURAL NOTES AND SCHEDULES
S2 FOUNDATION PLAN
S3 FOUNDATION PLAN
S4 SECOND FLOOR FRAMING AND
GROUND FLOOR LINTELS
S5 LOW ROOF FRAMING PLAN
S6 HIGH ROOF FRAMING PLAN
S7 SECTION AND DETAILS
S8 SECTION AND DETAILS
S9 DETAILS

MECHANICAL DRAWINGS LIST:

- DM1 PARTIAL GROUND FLOOR PLAN -
PLUMBING REMOVALS
DM2 PARTIAL GROUND FLOOR PLAN -
MECHANICAL REMOVALS
M1 SCHEDULES, LEGENDS AND
GENERAL NOTES - MECHANICAL
M2 SCHEDULE AND DETAILS
MECHANICAL
M3 DETAILS AND SCHEMATICS
MECHANICAL
M4 PARTIAL GROUND FLOOR PLAN
PLUMBING
M5 PARTIAL 2ND FLOOR PLAN
PLUMBING
M6 PARTIAL GROUND FLOOR PLAN
PLUMBING
M7 PARTIAL 2ND FLOOR PLAN
PLUMBING
M8 PARTIAL GROUND FLOOR PLAN
HYDRONICS
M9 PARTIAL 2ND FLOOR PLAN
HYDRONICS
M10 PARTIAL GROUND FLOOR PLAN
HVAC
M11 PARTIAL 2ND FLOOR PLAN
HVAC
M12 PARTIAL ROOF PLAN
MECHANICAL
FP1 SCHEDULE, LEGENDS AND
GENERAL NOTES - FIRE
PROTECTION
FP2 GROUND FLOOR PLAN
FIRE PROTECTION
FP3 SECOND FLOOR PLAN
FIRE PROTECTION



ELECTRICAL DRAWINGS LIST:

- E1 ELECTRICAL LEGENDS,
SCHEDULES AND NOTES
E2 GROUND FLOOR DEMOLITION
PLAN
E3 PARTIAL ELECTRICAL SITE PLAN
E4 ELECTRICAL SLD, DETAILS AND
PANEL SCHEDULES
E5 POWER LAYOUT GROUND FLOOR
E6 POWER LAYOUT SECOND FLOOR
E7 POWER ROOF PLAN
E8 FIRE ALARM RISER, ZONE
SCHEDULE
E9 FIRE ALARM LAYOUT GROUND
FLOOR
E10 FIRE ALARM LAYOUT SECOND
FLOOR
E11 LIGHTING SCHEDULE,
EMERGENCY LIGHTING SCHEDULE
E12 LIGHTING LAYOUT GROUND
FLOOR
E13 LIGHTING LAYOUT SECOND FLOOR
E14 LIGHTING CONTROLS SCHEDULE

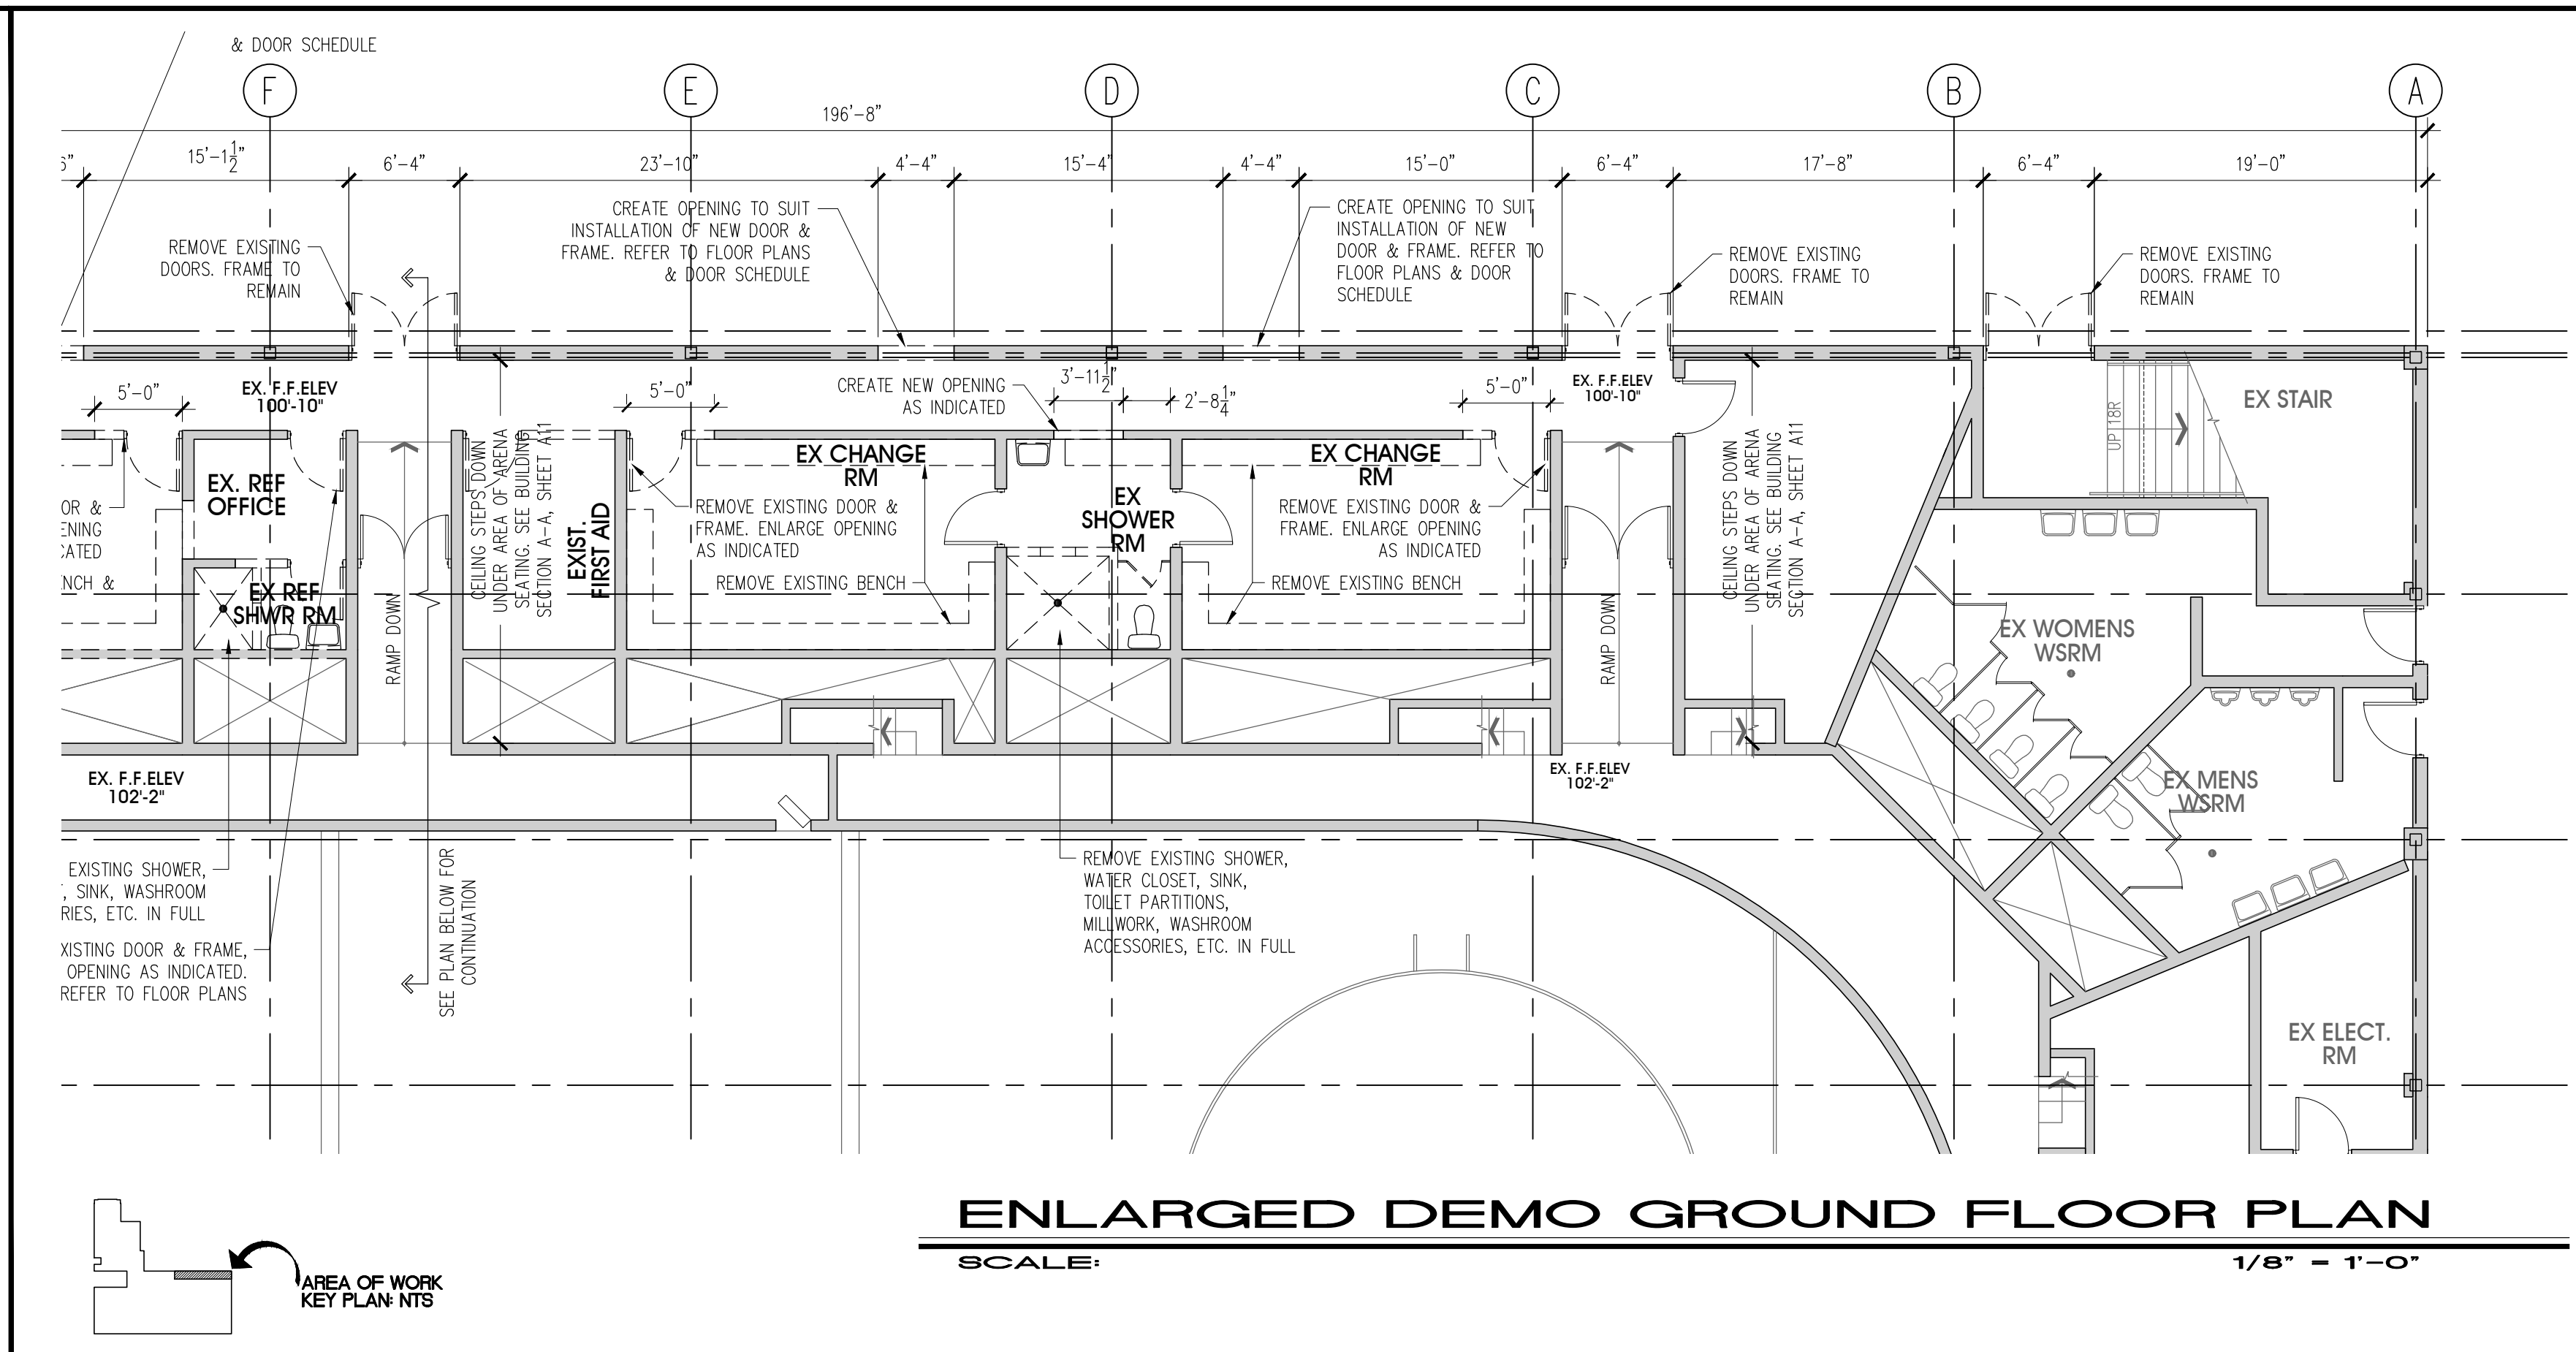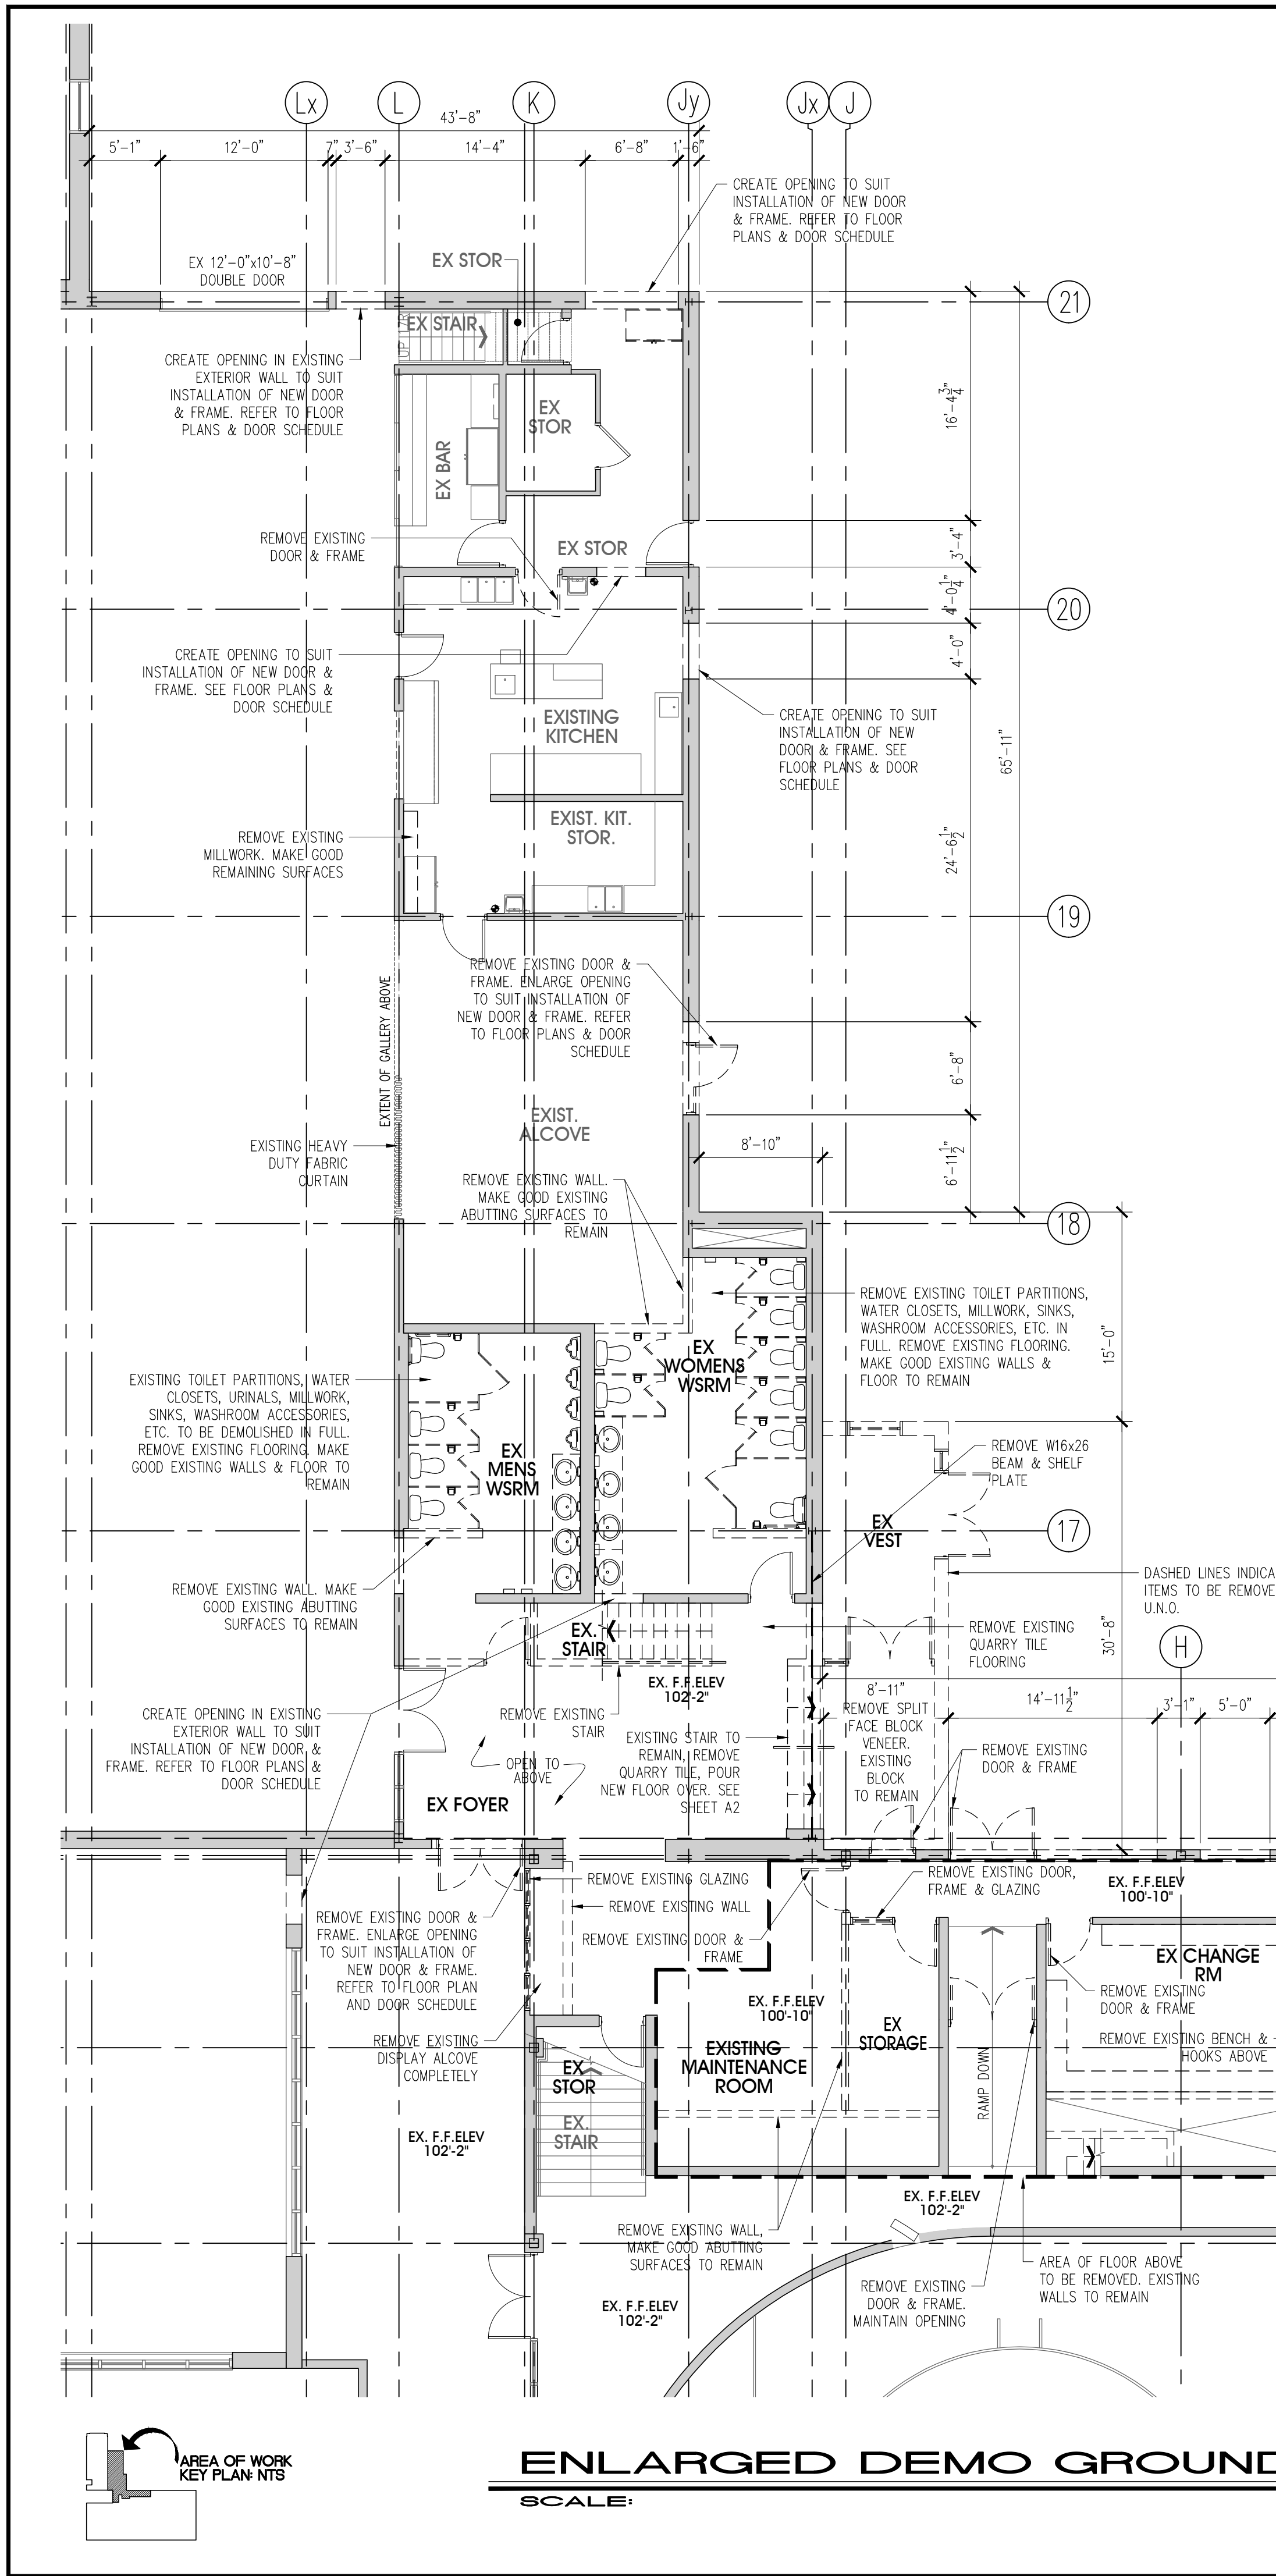

DEMOLITION LEGEND:

ROOM NAME	TAG DENOTES EXIST. ROOM NAME	EXIST. URINAL TO BE REMOVED, CAP ANY LINES AS REQ'D. REFER TO MECH. DUGS.
EXIST. WALL TO REMAIN.		EXIST. LAV. VANITY TO BE REMOVED, CAP ANY LINES AS REQ'D. REFER TO MECH. DUGS.
EXIST. WALL TO BE REMOVED.		EXIST. WALL MOUNTED LAV. TO BE REMOVED, CAP ANY LINES AS REQ'D. REFER TO MECH. DUGS.
EXIST. WINDOW TO BE REMOVED.		EXIST. MECH. SUPPLY/RETURNS FURNACE TO BE DEMO'D. REFER TO MECH. DUGS. FOR FURTHER INFO.
EXIST. DOOR TO BE REMOVED.		EXISTING ACT TO BE REMOVED. REFER TO DEMO PLANS FOR EXIST.
EXIST. OVERHEAD DOOR TO BE REMOVED.		EXIST. GTP. BD. CLG TO BE REMOVED. REFER TO DEMO PLANS FOR EXIST.
EXIST. STAIRS AND HAND/GUARDRAIL TO BE REMOVED.		
EXIST. WC TO BE REMOVED, CAP ANY LINES AS REQ'D. REFER TO MECH. DUGS.		

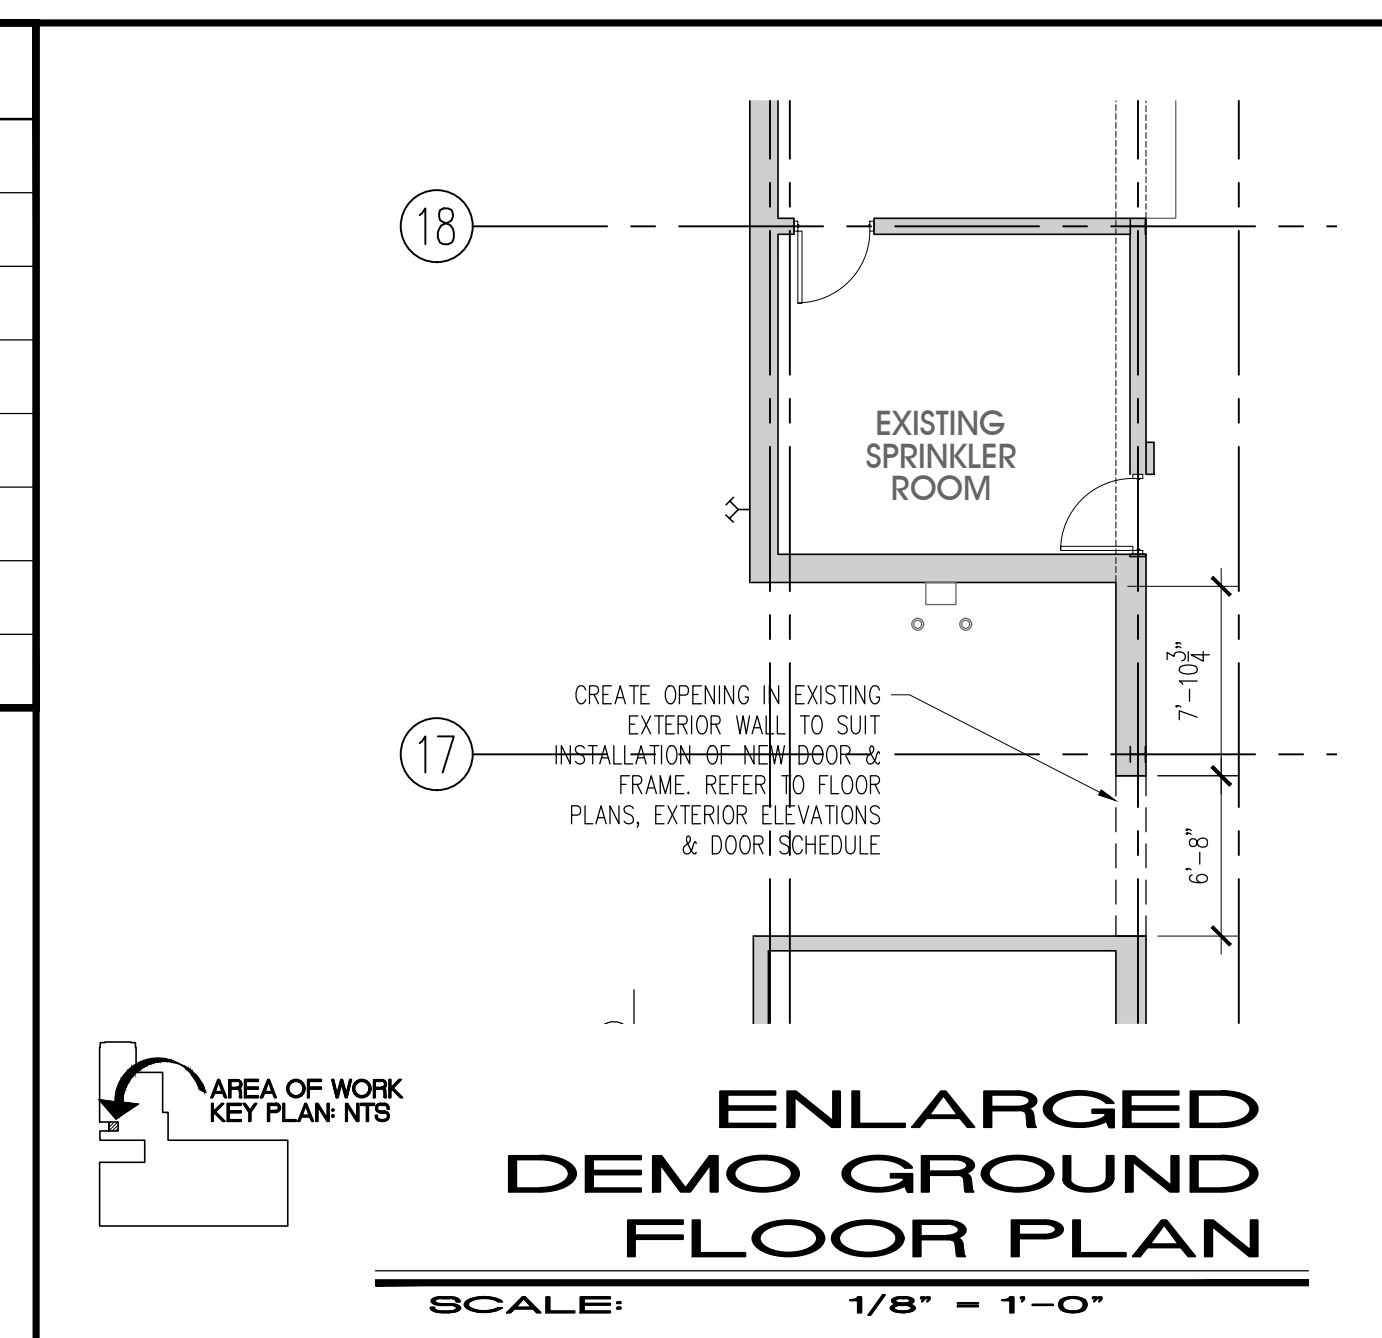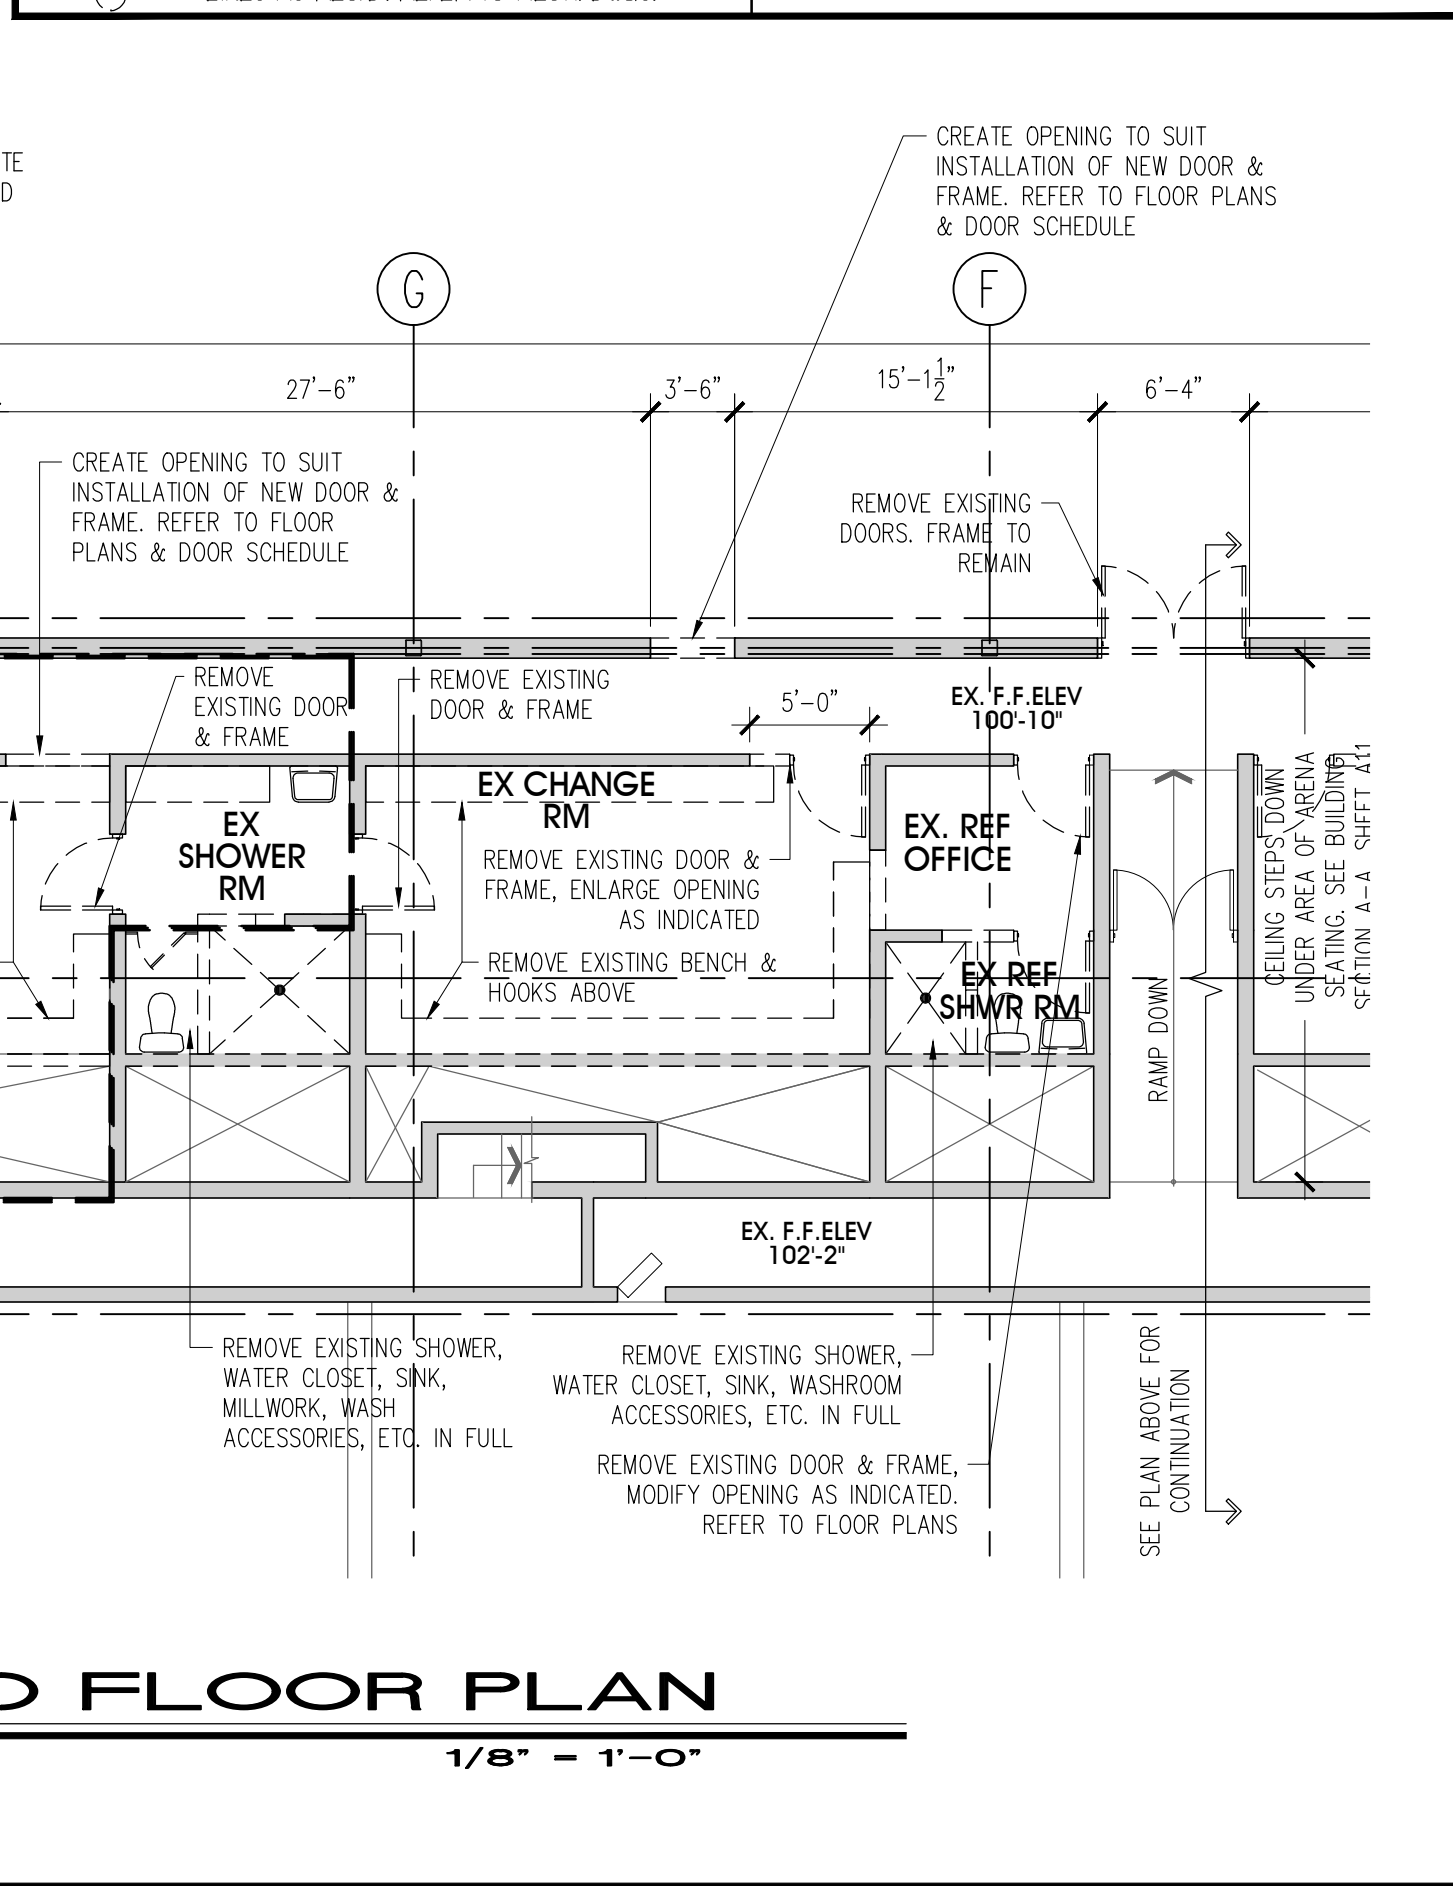

NOTE: BUILDING IS TO REMAIN OPEN DURING CONSTRUCTION. COORDINATE PROJECT PHASING WITH THE OWNER AND ARCHITECT.

NOTES:

EXISTING SIGNAGE THROUGHOUT AREA OF WORK TO BE REMOVED AND RETURNED TO OWNER.

EXISTING EMERGENCY DEFIBRILLATOR TO BE RELOCATED AS DIRECTED ON SITE.

EXISTING QUARRY TILE FLOORING THROUGHOUT AREA OF WORK TO BE REMOVED.

ISSUED FOR PERMIT	FEB. 01/22	
ADDENDA #2	DEC. 15/21	
ISSUED FOR TENDER	DEC. 01/21	
revisions	date	no.

CONTRACTORS MUST CHECK AND VERIFY ALL DIMENSIONS AND REPORT ANY DISCREPANCY TO THIS FIRM BEFORE PROCEEDING WITH THE WORK

A - detail no.
B - location sheet
C - detail sheet

PROJECT NORTH
TRUE NORTH

ONARIO ASSOCIATION
26/11/2021
ARCHITECTS
KEVIN J. McILMURRAY
LICENCE 3879






SPRIET ASSOCIATES
LIMITED architects
LONDON LTD. engineers
155 york street - london - N6A 1A8
phone : (519) 672-4100 fax : (519) 433-9351
e-mail : mail@spriet.on.ca

LUCAN BIDDULPH COMMUNITY MEMORIAL CENTRE
PHASE 2 - LUCAN ARENA
RENO'S & ARENA ADDITION
263 & 265 MAIN STREET, LUCAN, ONTARIO

drawing title :
ENLARGED GROUND DEMOLITION PLAN

date : NOV. 26, 2021
scale : AS NOTED
drawn by : MTH
project no. : 216255-2

drawing no. :
D1

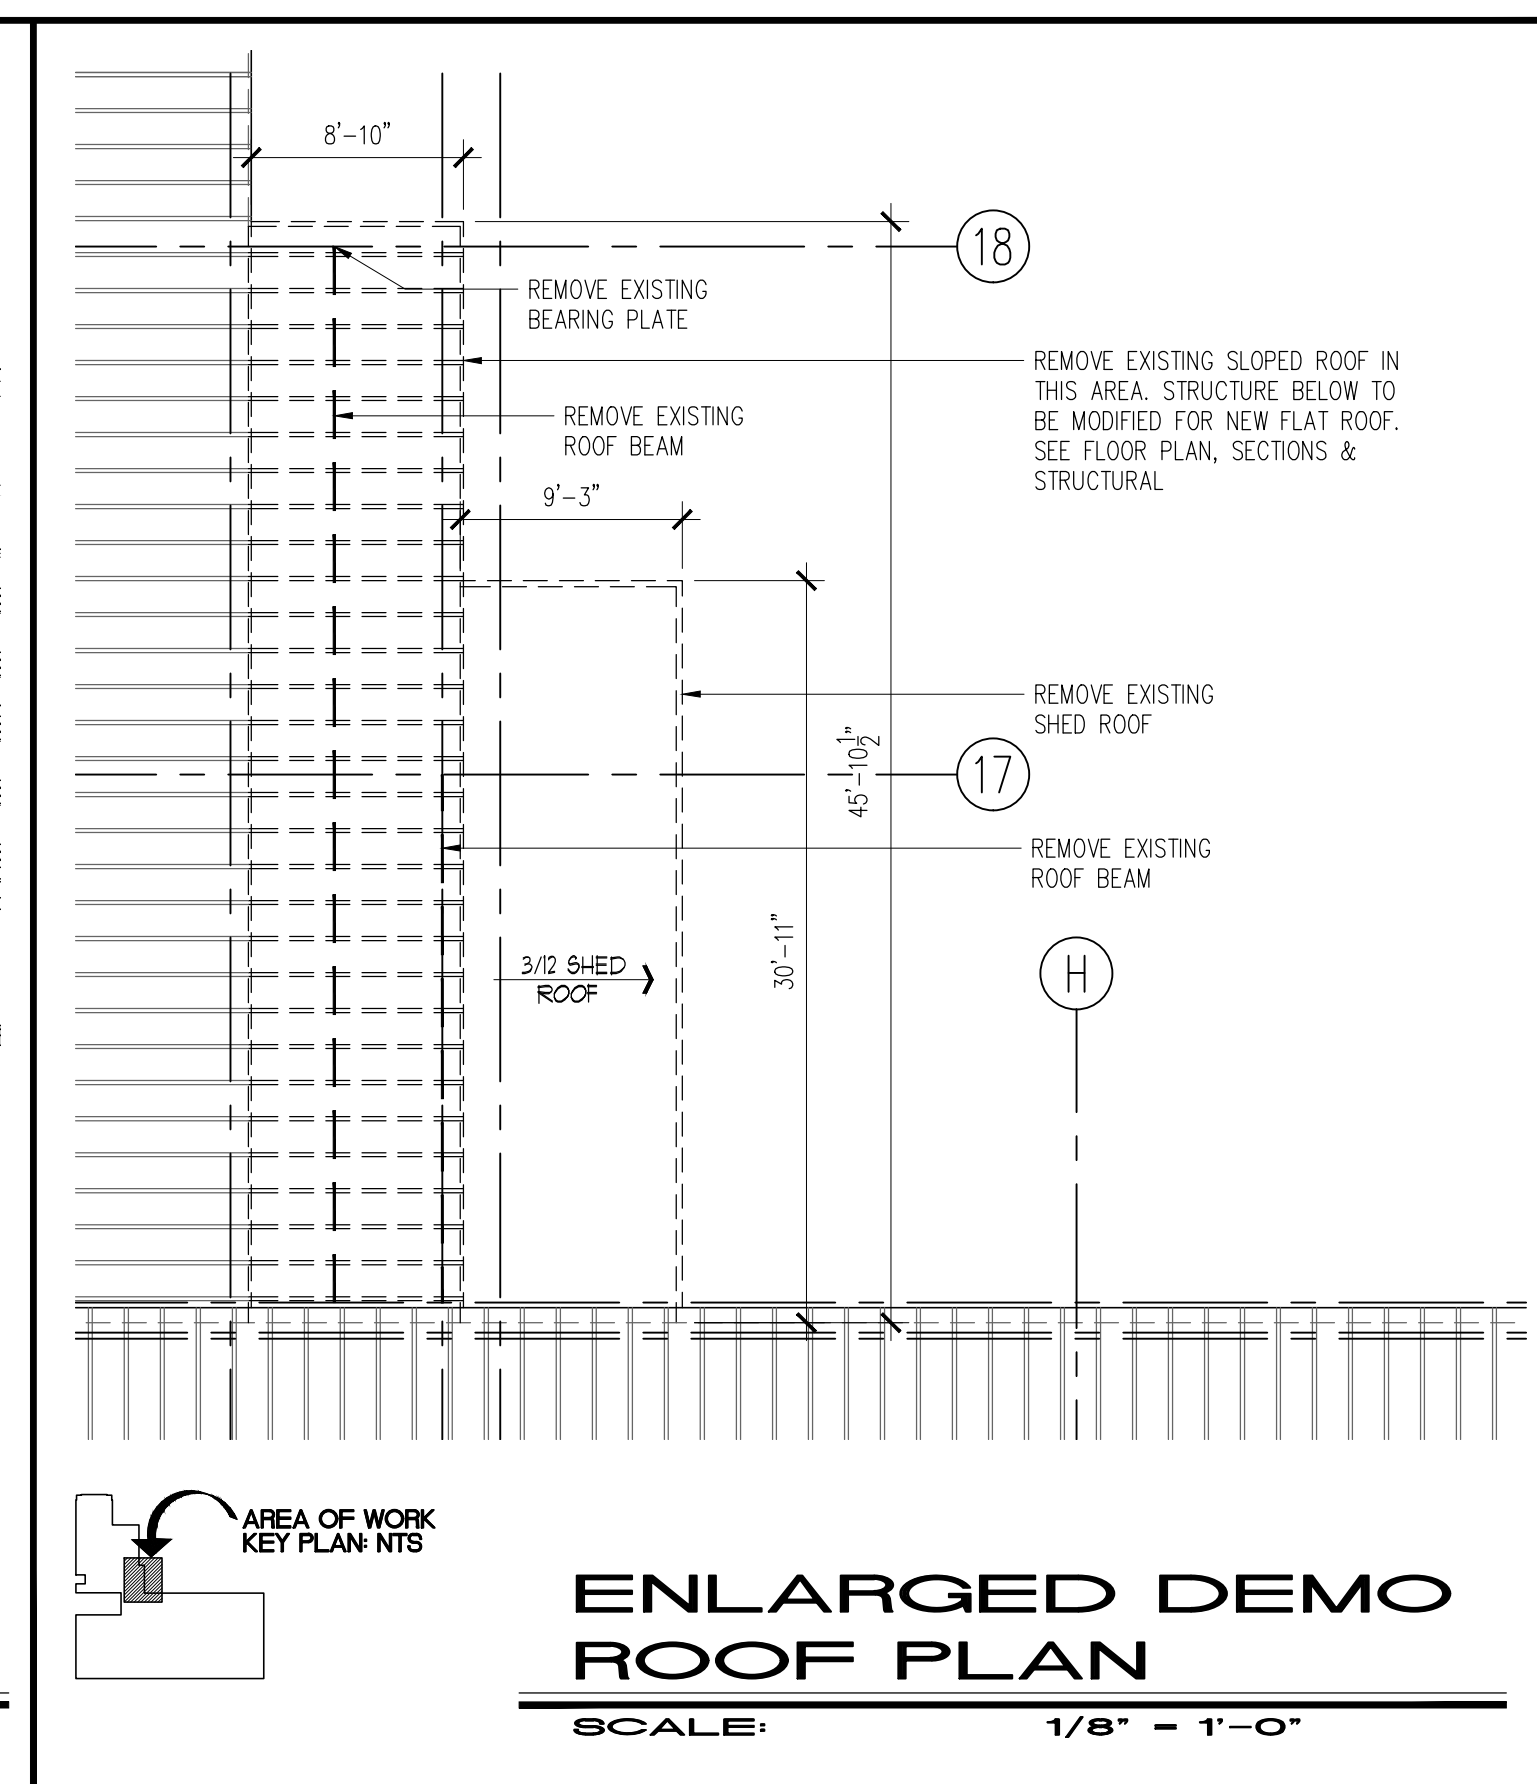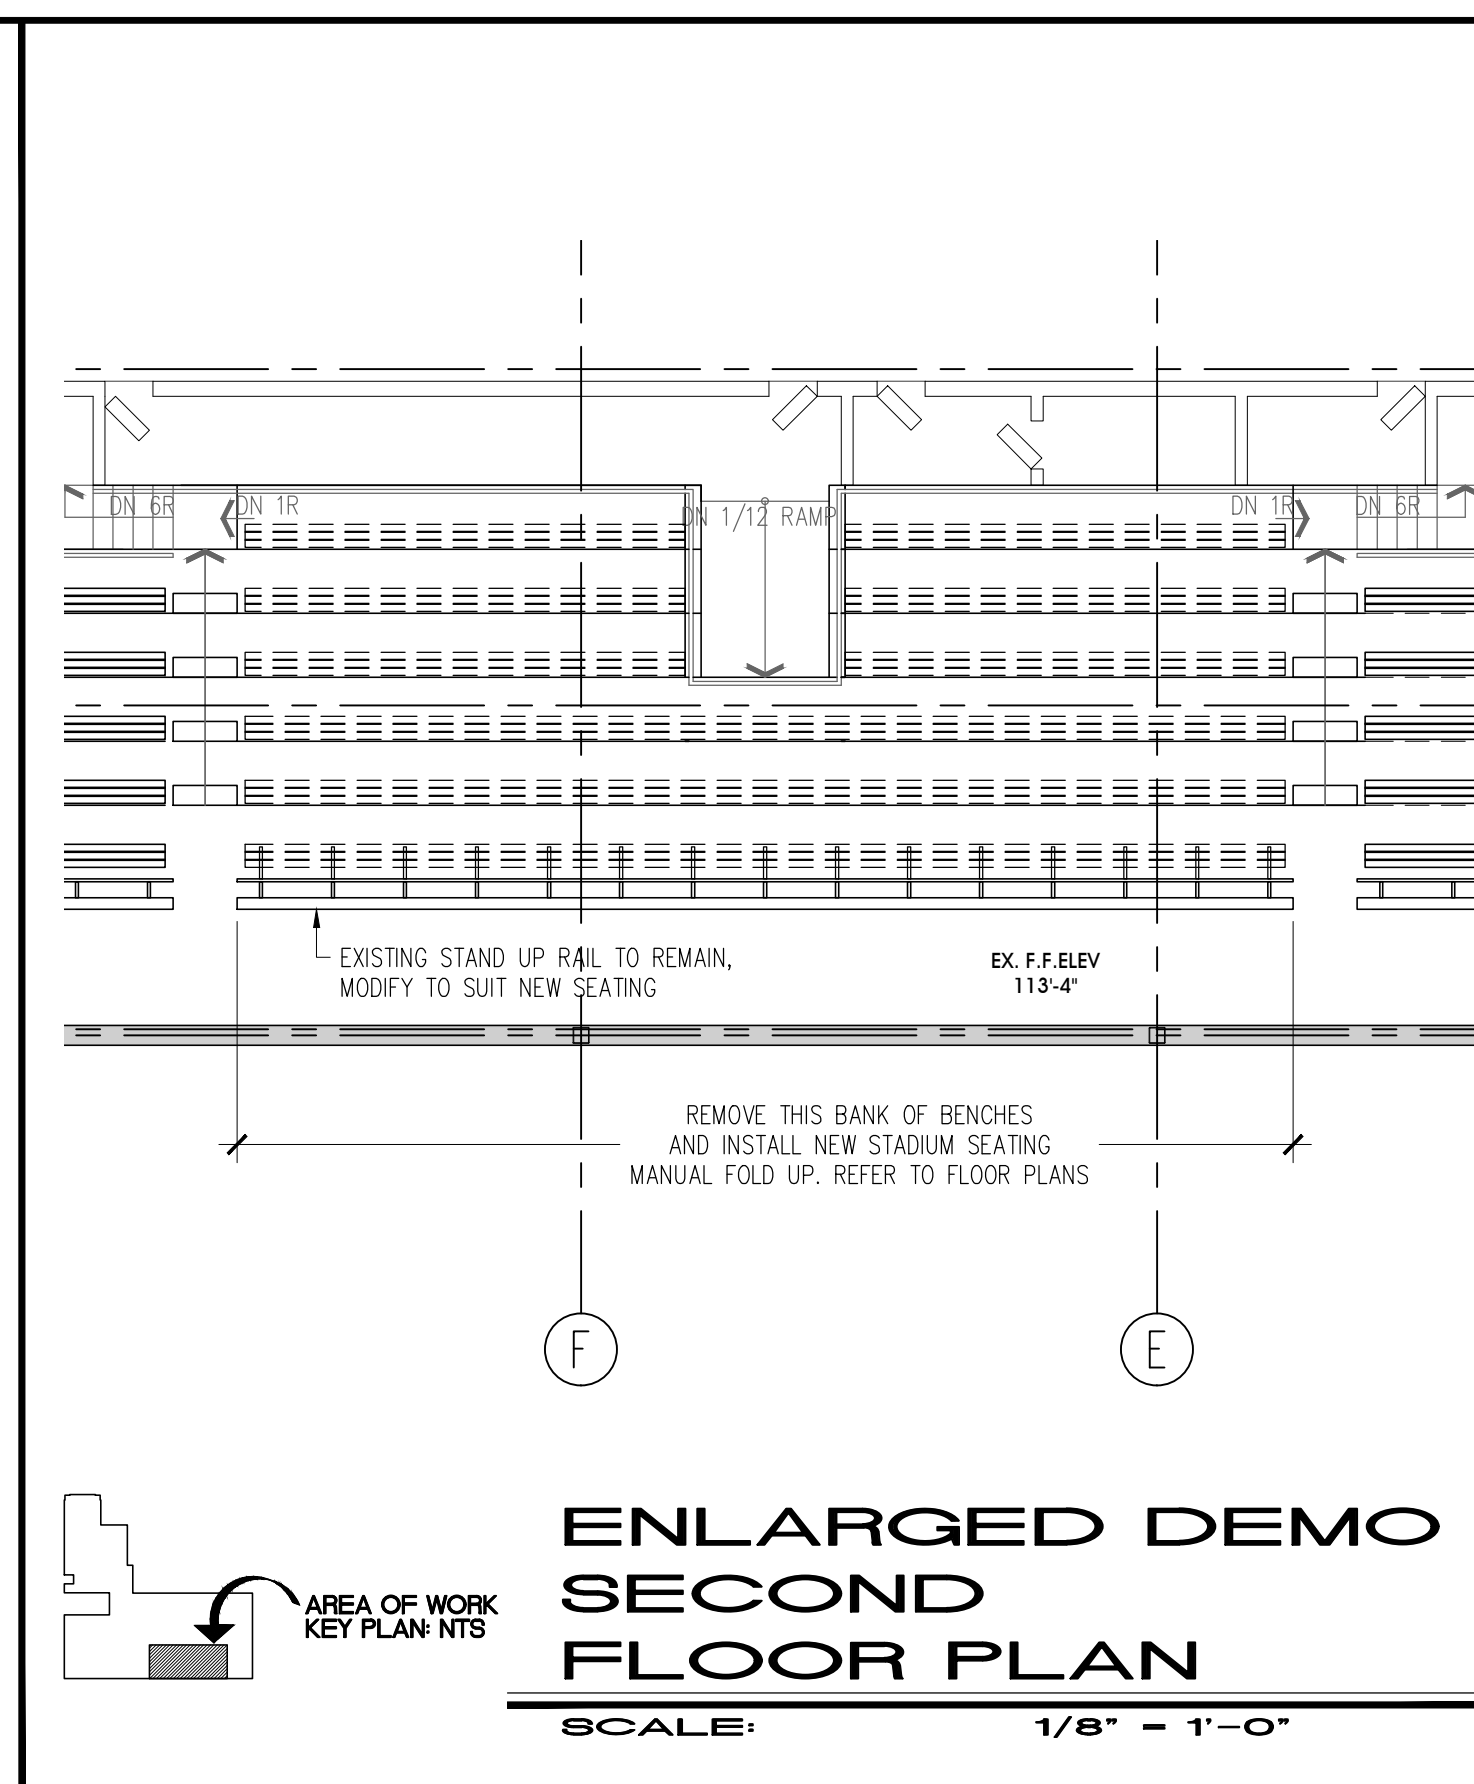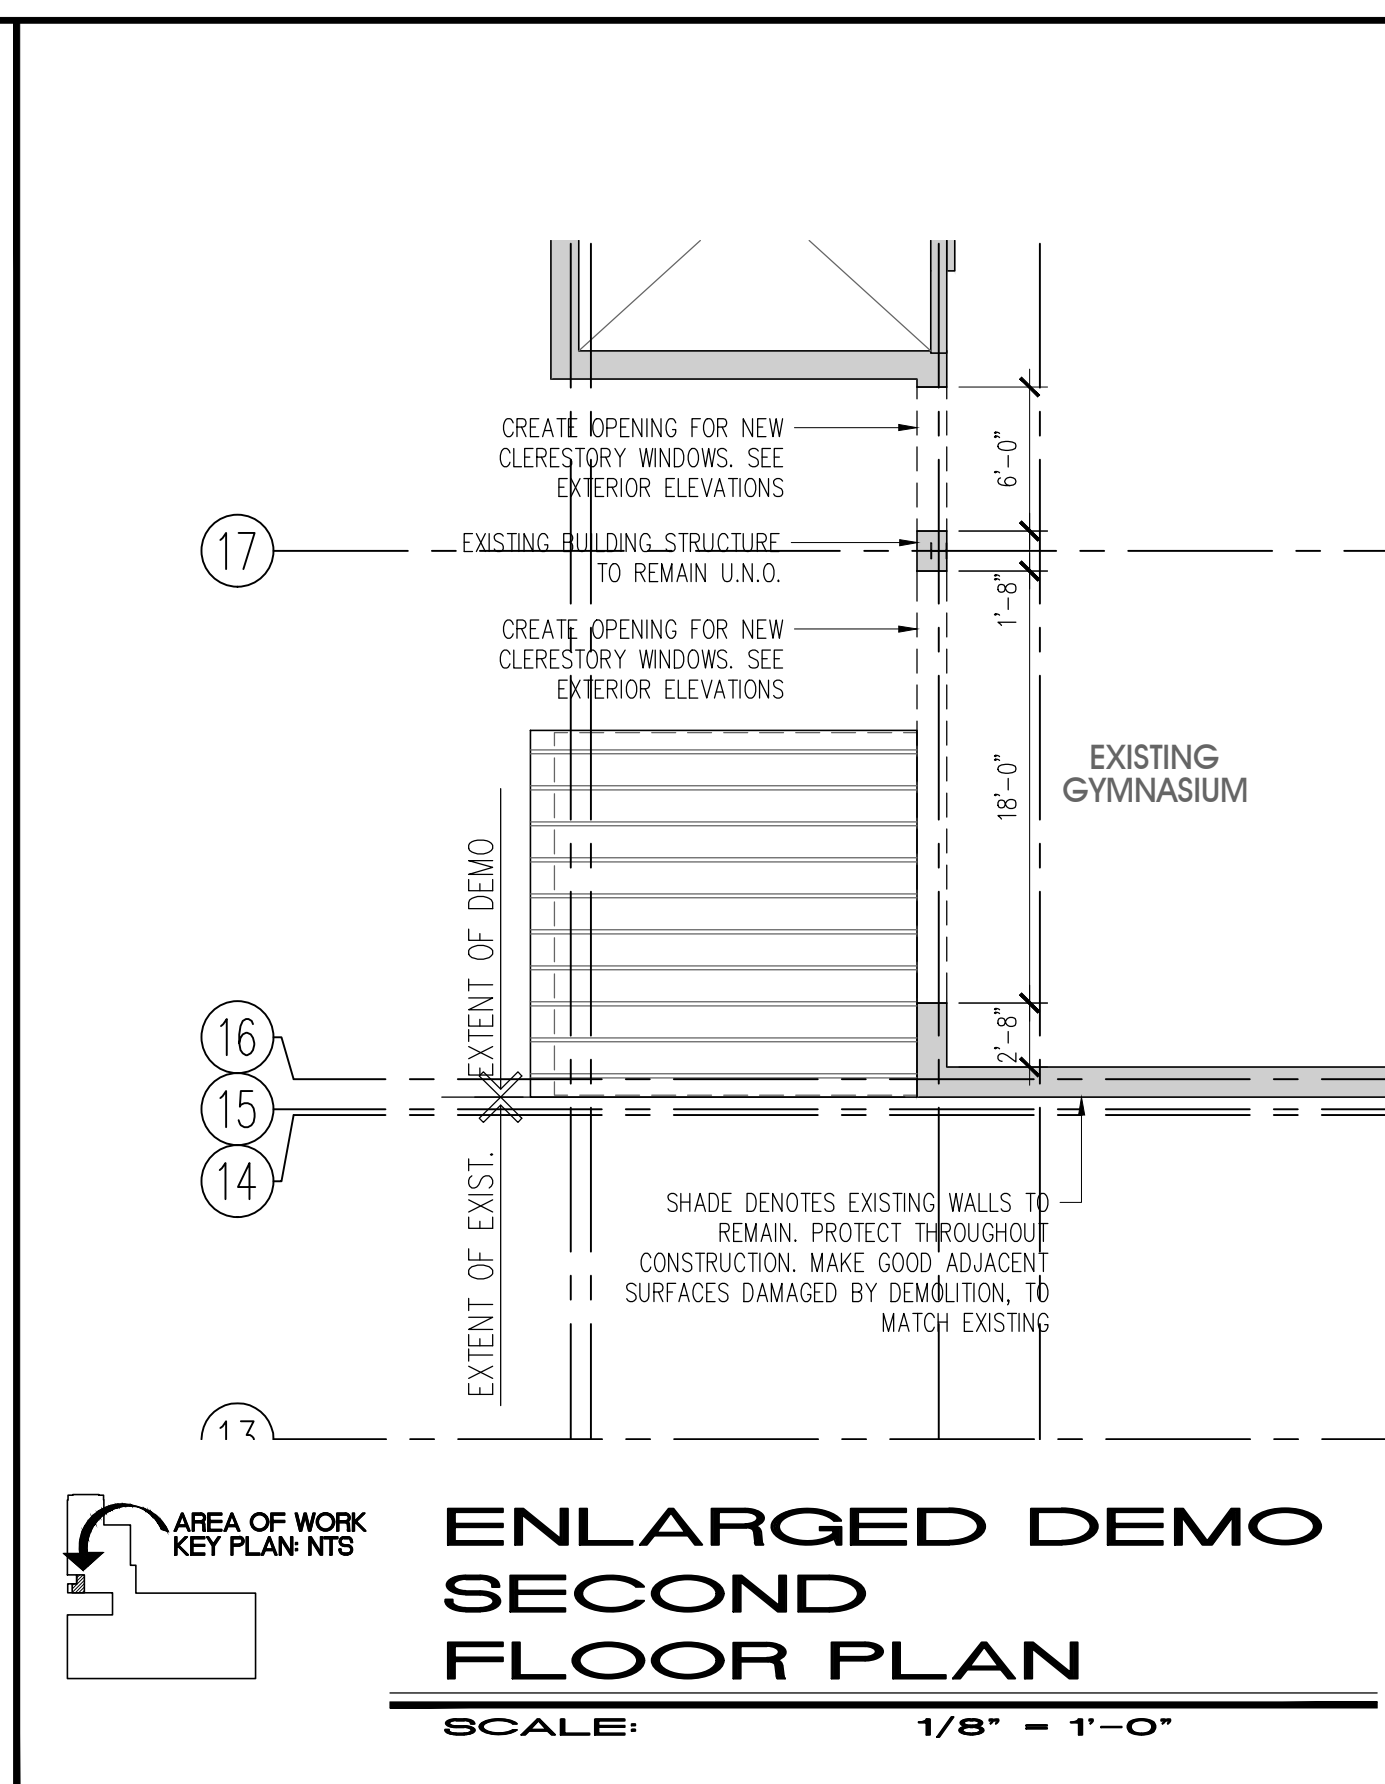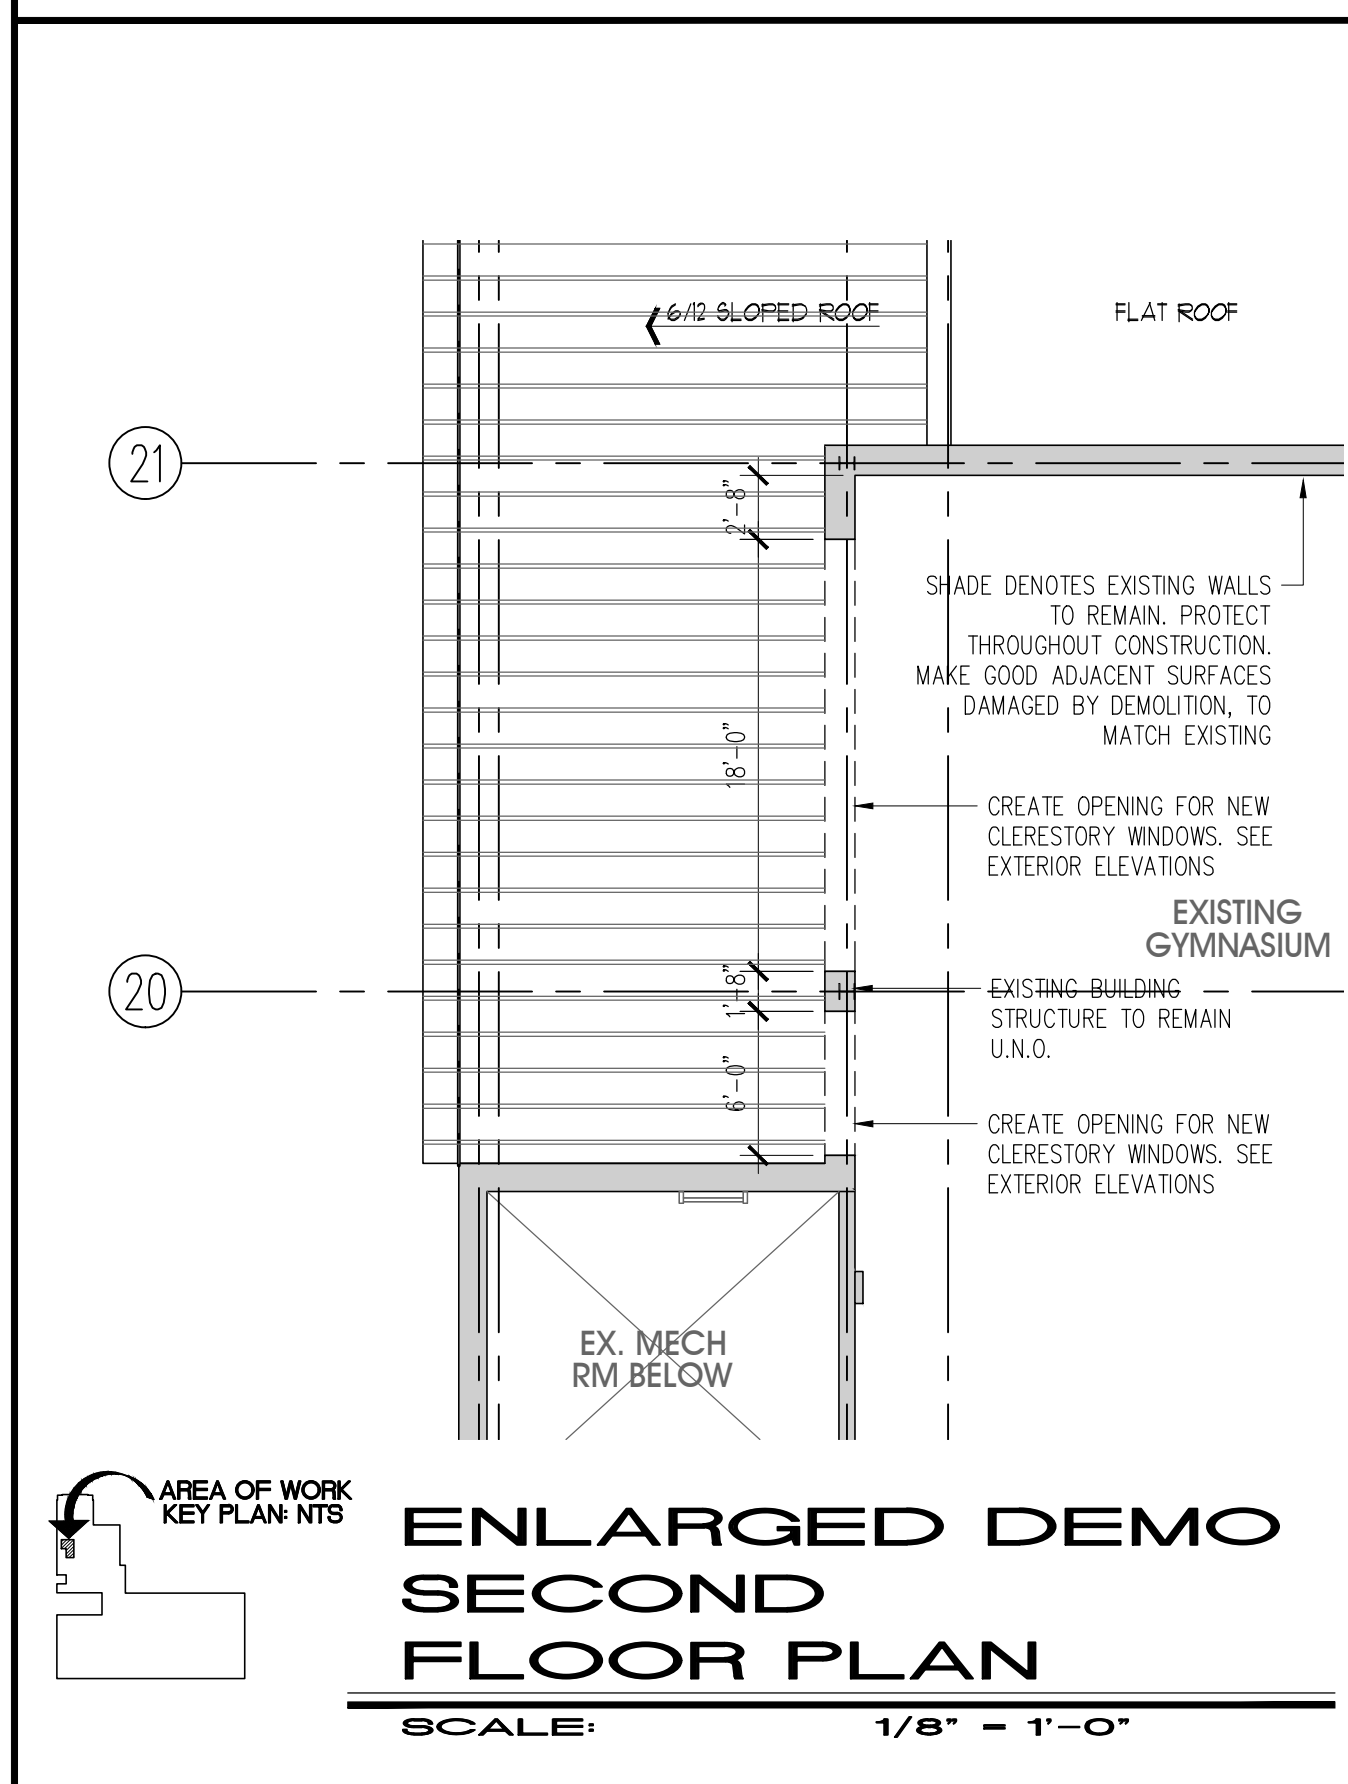
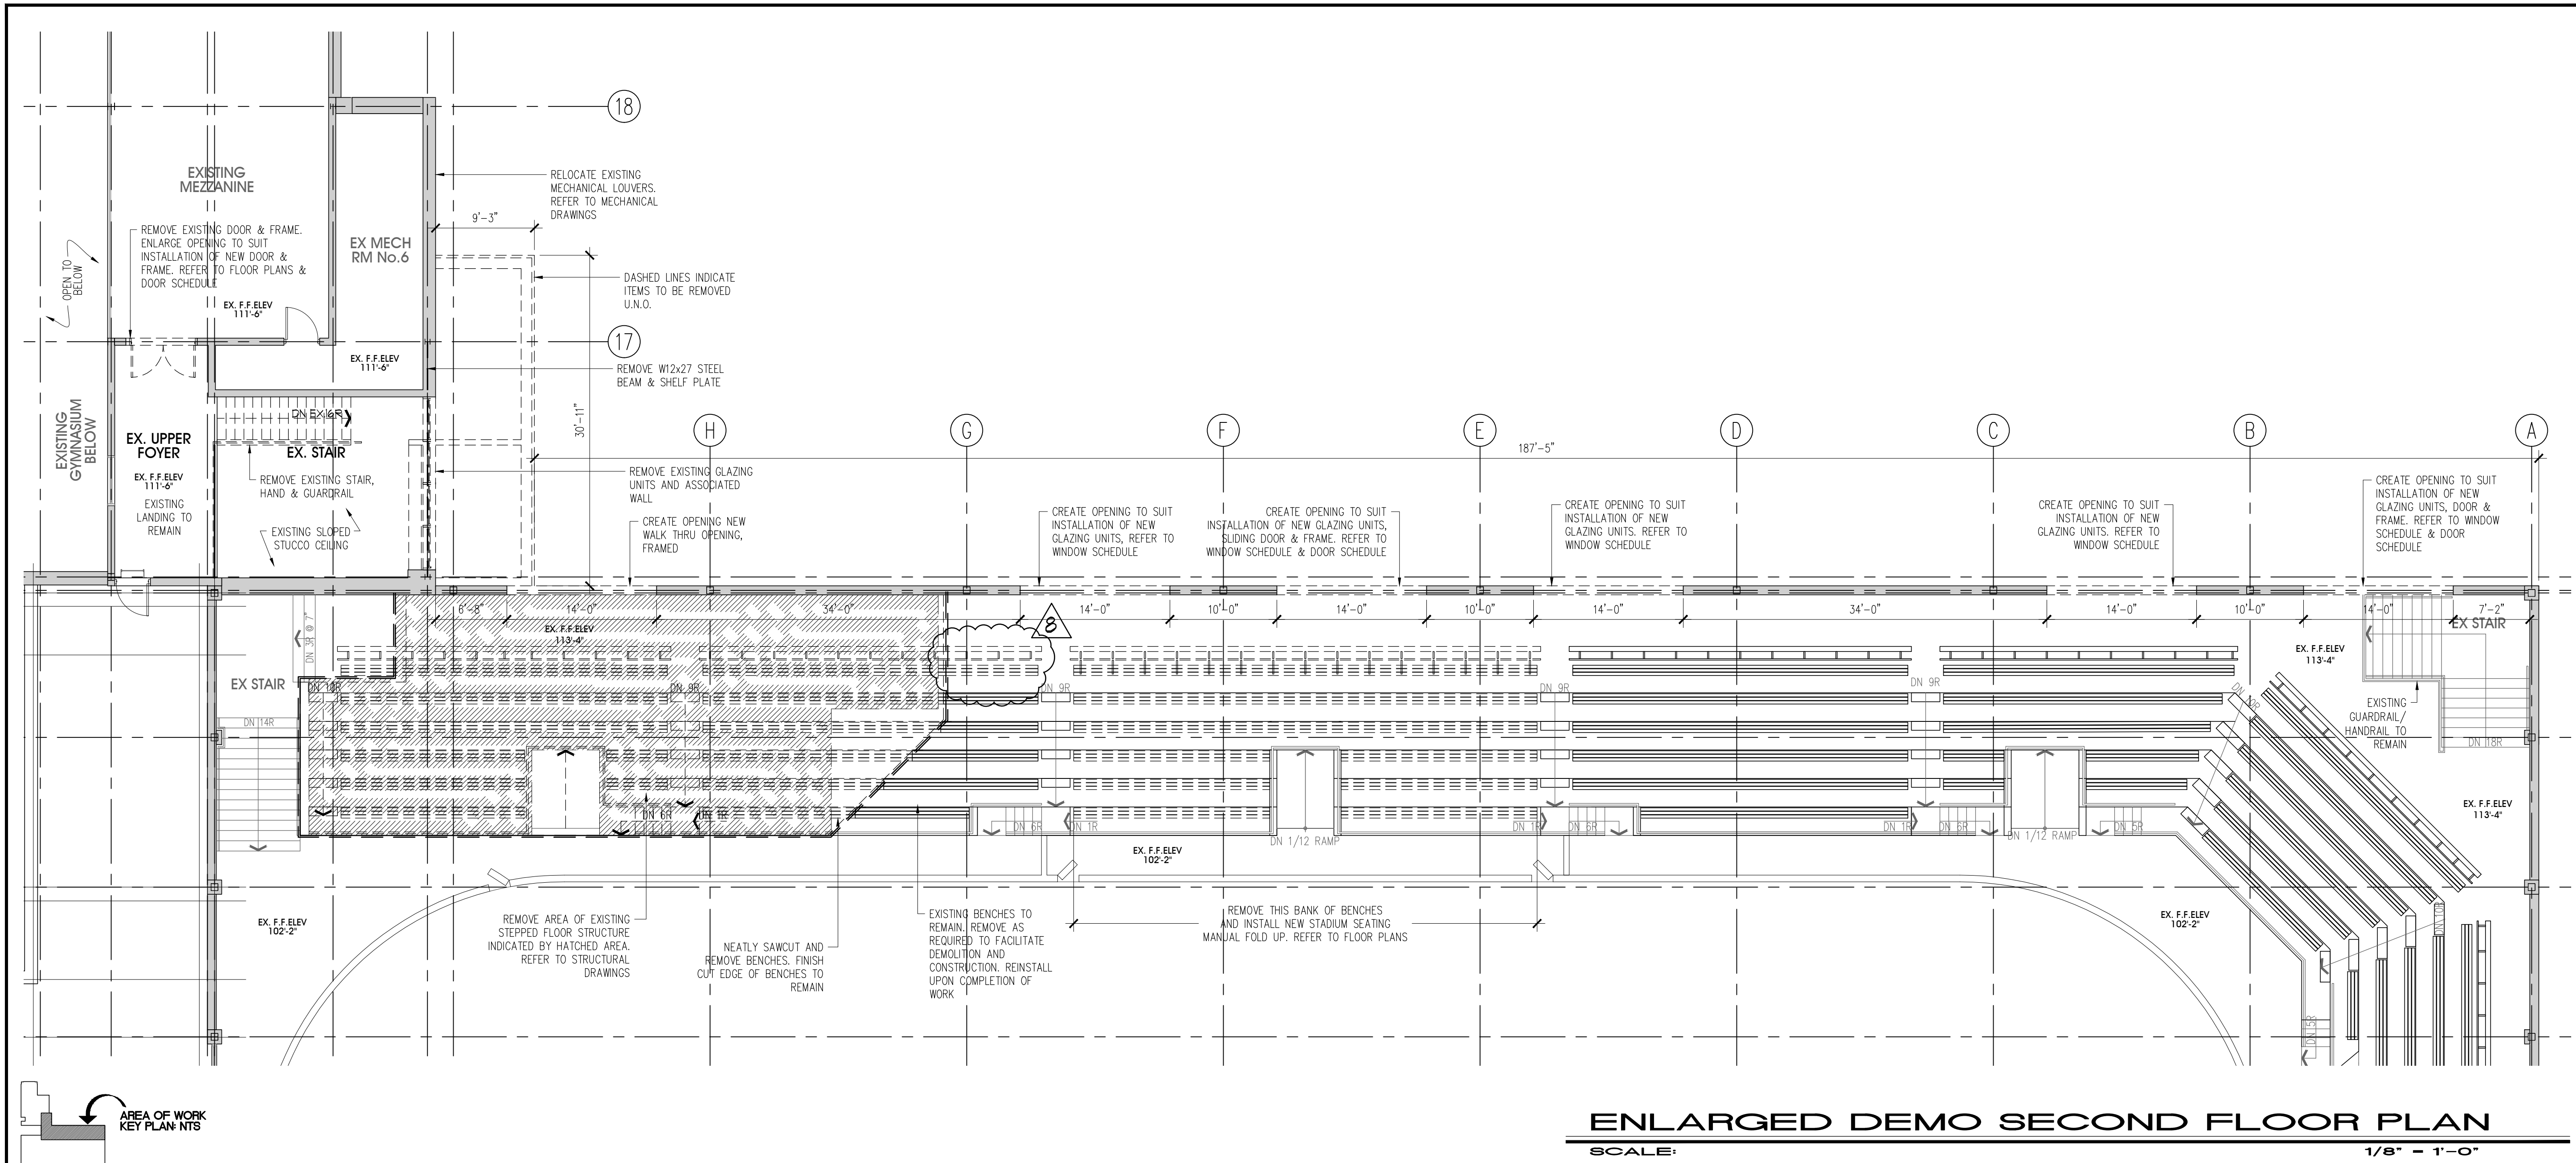


ISSUED FOR PERMIT	FEB. 01/22	
ADDENDA #8	JAN. 31/22	△
ADDENDA #2	DEC. 15/21	△
ISSUED FOR TENDER	DEC. 01/21	△
revisions	date	no.

CONTRACTORS MUST CHECK AND VERIFY ALL DIMENSIONS AND REPORT ANY DISCREPANCY TO THIS FIRM BEFORE PROCEEDING WITH THE WORK

A - detail no.
B - location sheet
C - detail sheet

A
B C

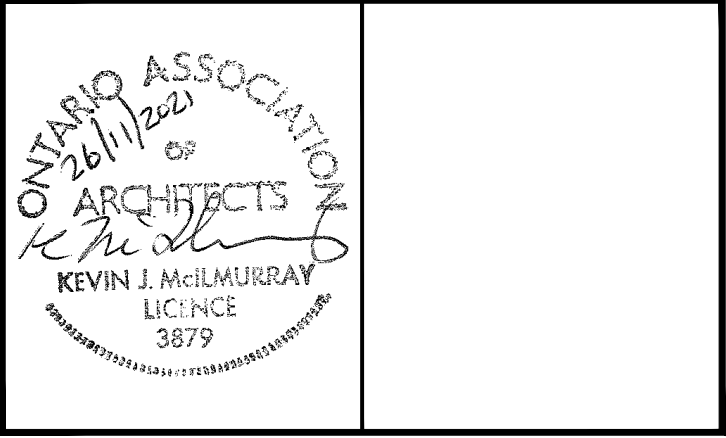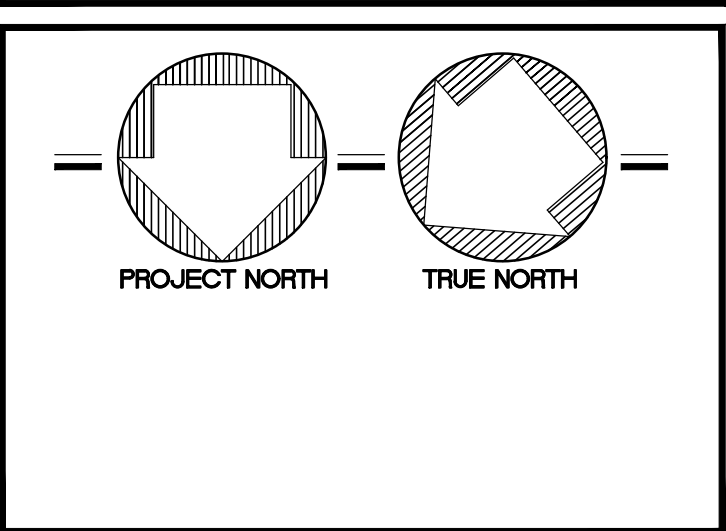

SPRIET ASSOCIATES

LIMITED architects LONDON LTD. engineers


155 York Street - London - N6A 1A8
phone : (519) 672-4100 fax : (519) 433-9351
e-mail : mail@spriet.on.ca

LUCAN BIDDULPH COMMUNITY MEMORIAL CENTRE PHASE 2 - LUCAN ARENA RENOVATION & ADDITION
263 & 265 MAIN STREET, LUCAN, ONTARIO

drawing title :
ENLARGED SECOND DEMOLITION PLAN


date : NOV. 26, 2021
scale : AS NOTED
drawn by : MTH
project no. : 216255-2

drawing no. :
D2

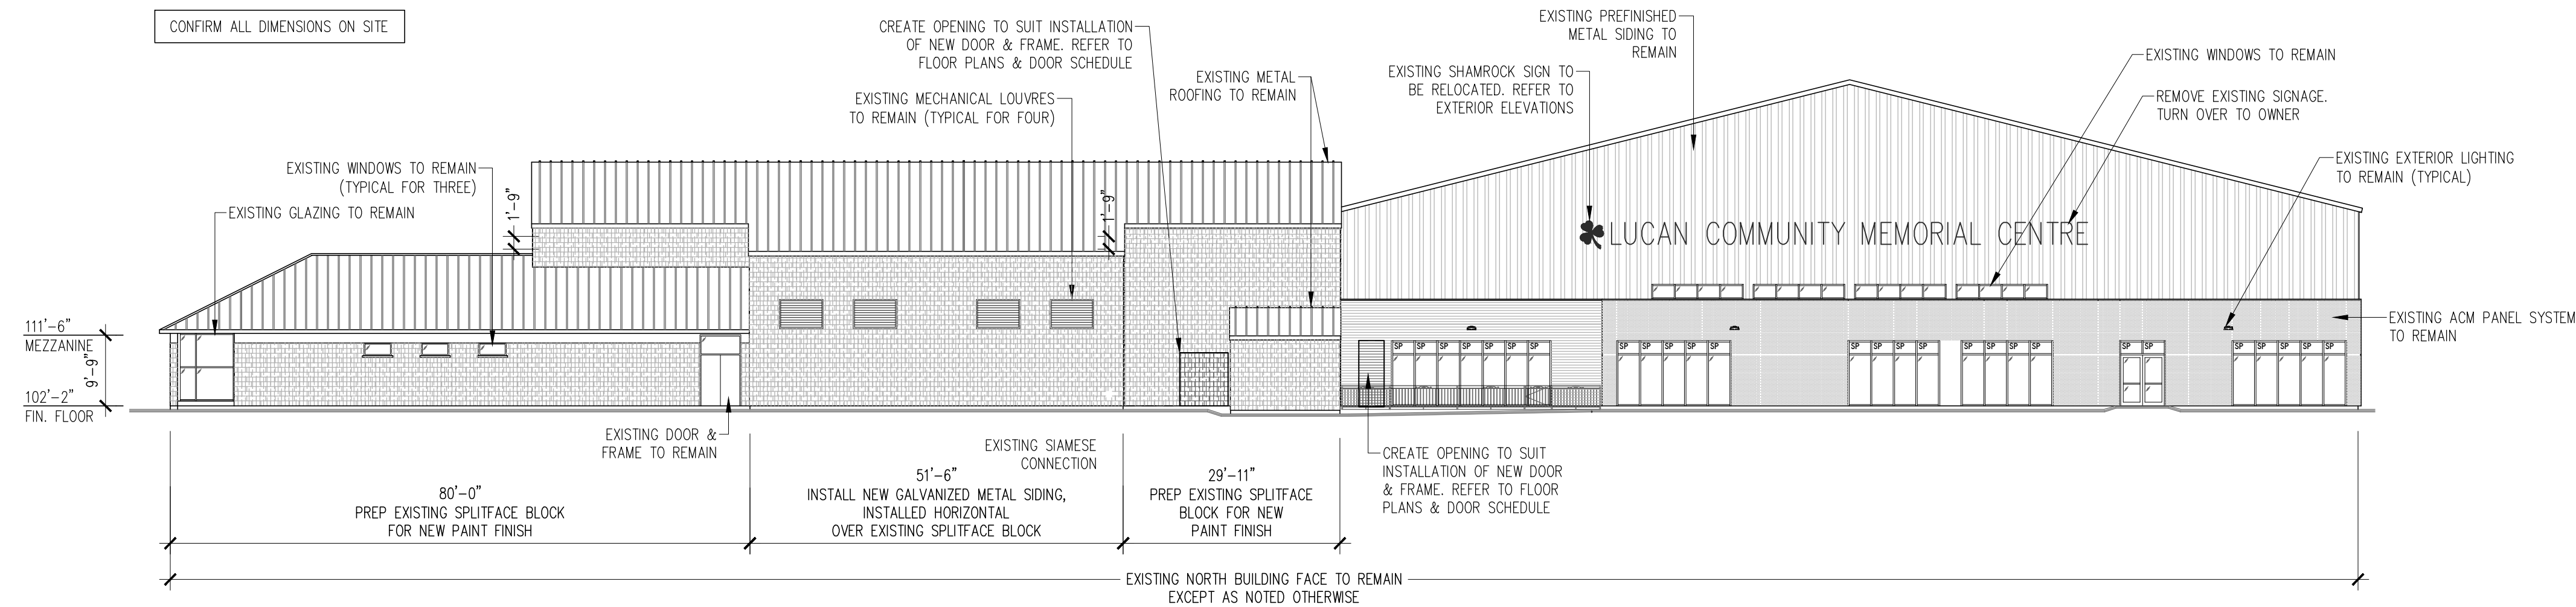


NORTH ELEVATION

SCALE: 1/16" = 1'-0"

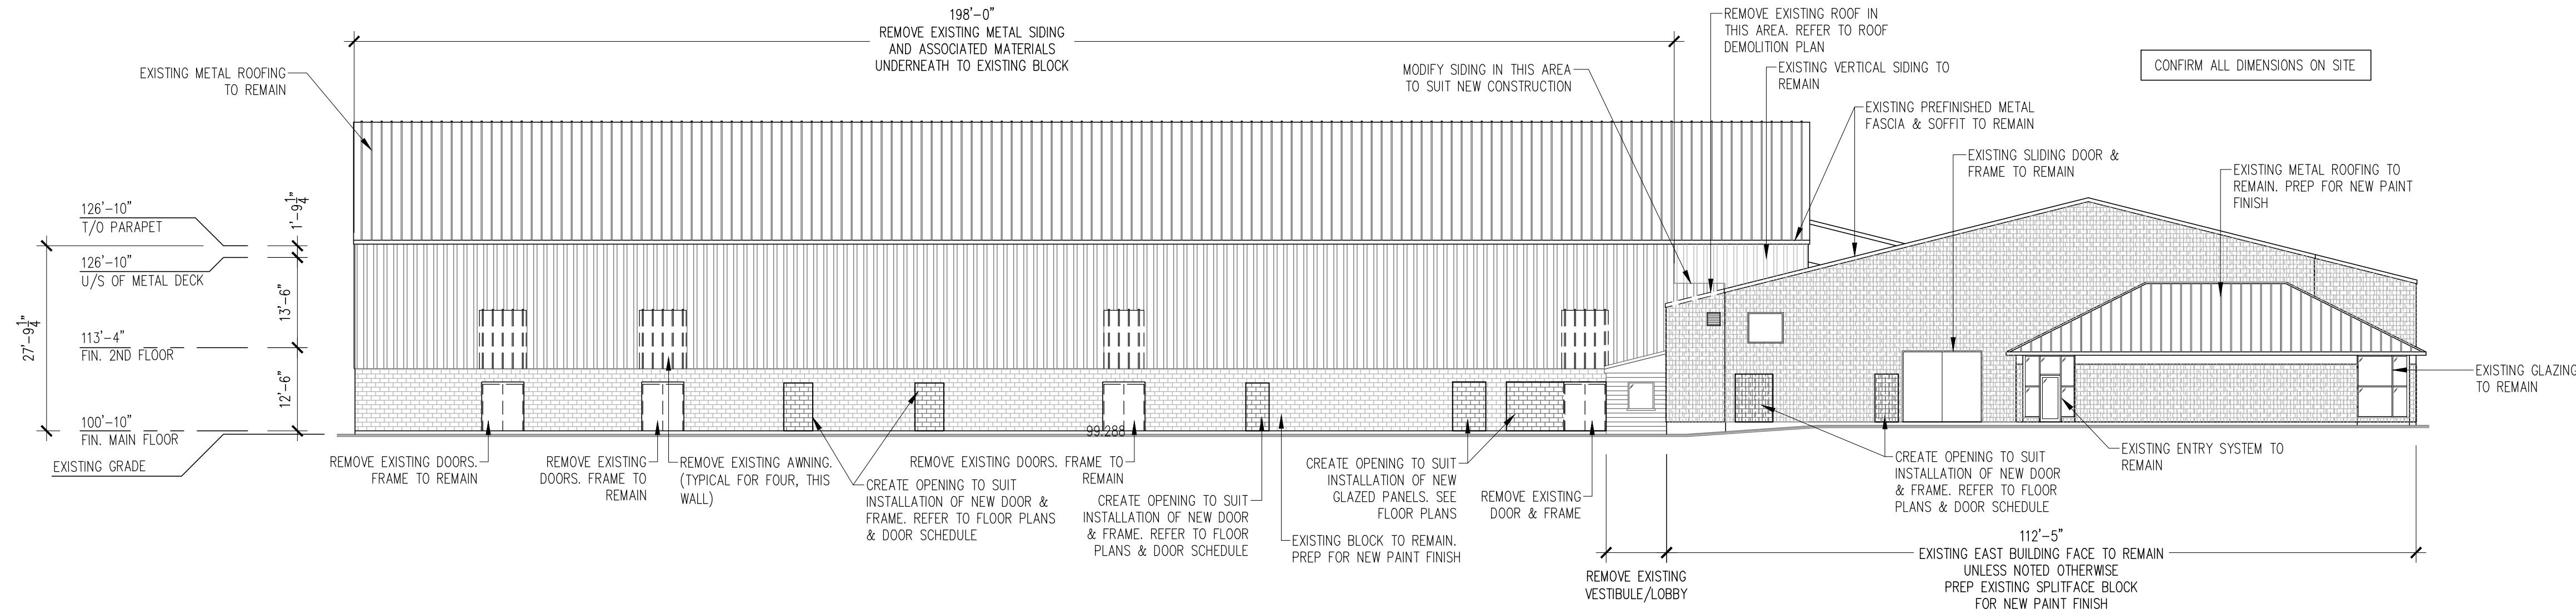

EAST ELEVATION

SCALE: 1/16" = 1'-0"

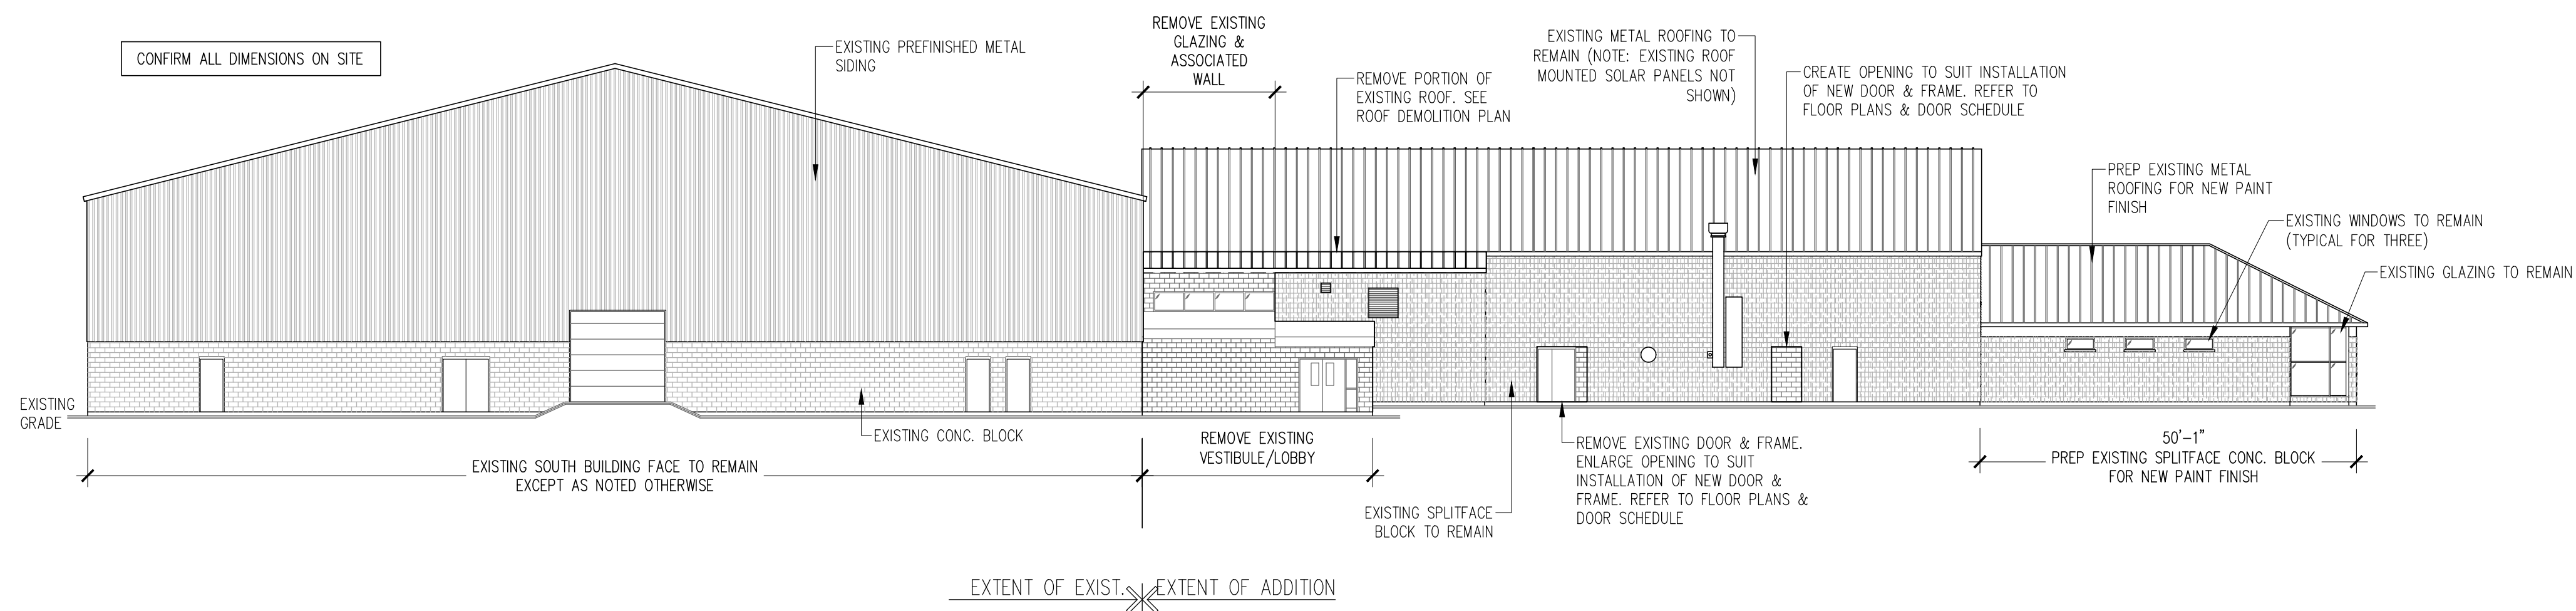




SOUTH ELEVATION

SCALE: 1/16" = 1'-0"

ISSUED FOR PERMIT	FEB. 01/22	
ADDENDA #2	DEC. 15/21	
ISSUED FOR TENDER	DEC. 01/21	
revisions	date	no.

CONTRACTORS MUST CHECK AND VERIFY ALL DIMENSIONS AND REPORT ANY DISCREPANCY TO THIS FIRM BEFORE PROCEEDING WITH THE WORK

A - detail no.
B - location sheet
C - detail sheet

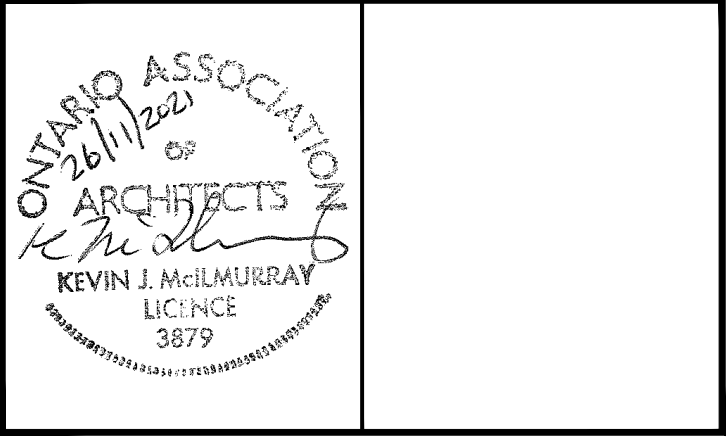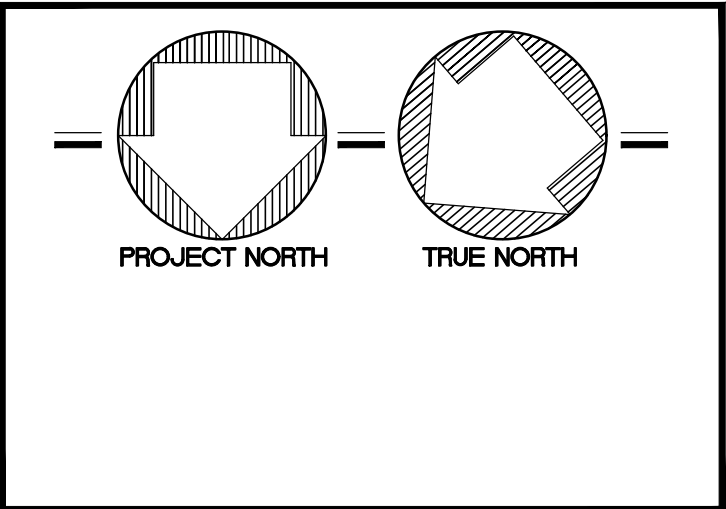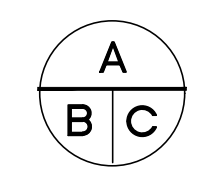

SPRIET ASSOCIATES

LIMITED architects
LONDON LTD. engineers

155 york street - london - N6A 1A8
phone : (519) 672-4100 fax : (519) 433-9351
e-mail : mail@spriet.on.ca

LUCAN BIDDULPH COMMUNITY MEMORIAL CENTRE
PHASE 2 - LUCAN ARENA
RENO'S & ARENA ADDITION
263 & 265 MAIN STREET, LUCAN, ONTARIO

drawing title :
DEMOLITION ELEVATIONS

date : NOV. 26, 2021	drawing no. :
scale : AS NOTED	D3
drawn by : RP	
project no. : 216255-2	

WALL TAGS: NOTE: ALL MATERIALS TO EXTEND FULL HEIGHT U.N.O.
REFER ALSO TO GENERAL RM FINISH SCHEDULE NOTES.

EW1

EW2

EW3

EW4

EW5

P1

P2

P3

P4

P5

P6

P7

ACM PANEL SYSTEM WITH
ADJUSTABLE STEEL SUB-GIRTS @ 24" O.C.
MAX. PROVIDE SUB-GIRTS AT SEAM
LOCATIONS
MIN. R17 SEMI-RIGID INSUL. c/w STEEL STICK
FINS
MEMBRANE AIR BARRIER
8" STANDARD CONCRETE BLOCK

3" CORRUGATED GALVANIZED ALUM. HORIZ. SIDING
ADJUSTABLE STEEL SUB-GIRTS @ 32" O.C. VERTICAL
MIN. R17 SEMI-RIGID INSUL. c/w STEEL STICK FINS
MEMBRANE AIR BARRIER
8" STANDARD CONCRETE BLOCK

1" 5/8" SPLIT FACE BLOCK VENEER
1" AIR SPACE
MIN. R17 SEMI-RIGID INSUL. c/w STEEL STICK FINS
MEMBRANE AIR BARRIER
8" STANDARD CONCRETE BLOCK

PREFINISHED METAL SIDING
ADJUSTABLE STEEL SUB-GIRTS @ 24" O.C. HORIZONTAL
MIN. R17 SEMI-RIGID INSUL. c/w STEEL STICK FINS
MEMBRANE AIR BARRIER
1/2" DENSGLASS
8" (18 Ga.) STEEL STUDS @ 16" O.C.
w/ R20 BATT INSULATION
6 MIL. POLY VAPOUR BARRIER
1/2" GYPSUM BOARD

PREFINISHED METAL SIDING
ADJUSTABLE STEEL SUB-GIRTS @ 24" O.C.
MAX. MIN. R17 SEMI-RIGID INSUL. c/w STEEL
STICK PINS
MEMBRANE AIR BARRIER
8" STANDARD CONCRETE BLOCK

1 hour FIRE RATED WALL
8" STANDARD CONCRETE BLOCK

8" STANDARD CONCRETE BLOCK

6" STANDARD CONCRETE BLOCK


1/2" GYPSUM BOARD, ROOM SIDE ONLY
STEEL STUDS @ 16" O.C. THICKNESS
AS NOTED ON PLANS

1/2" GYPSUM BOARD, BOTH SIDES
STEEL STUDS @ 16" O.C. THICKNESS
AS NOTED ON FLANS

1/2" GYPSUM BOARD
3 5/8" METAL STUDS
STEEL COLUMN, REFER TO
STRUCTURAL DRAWINGS
FOR SIZE
SPRAY APPLIED

PROVIDE 2 HR FIRE
RATING

10" STANDARD CONCRETE BLOCK

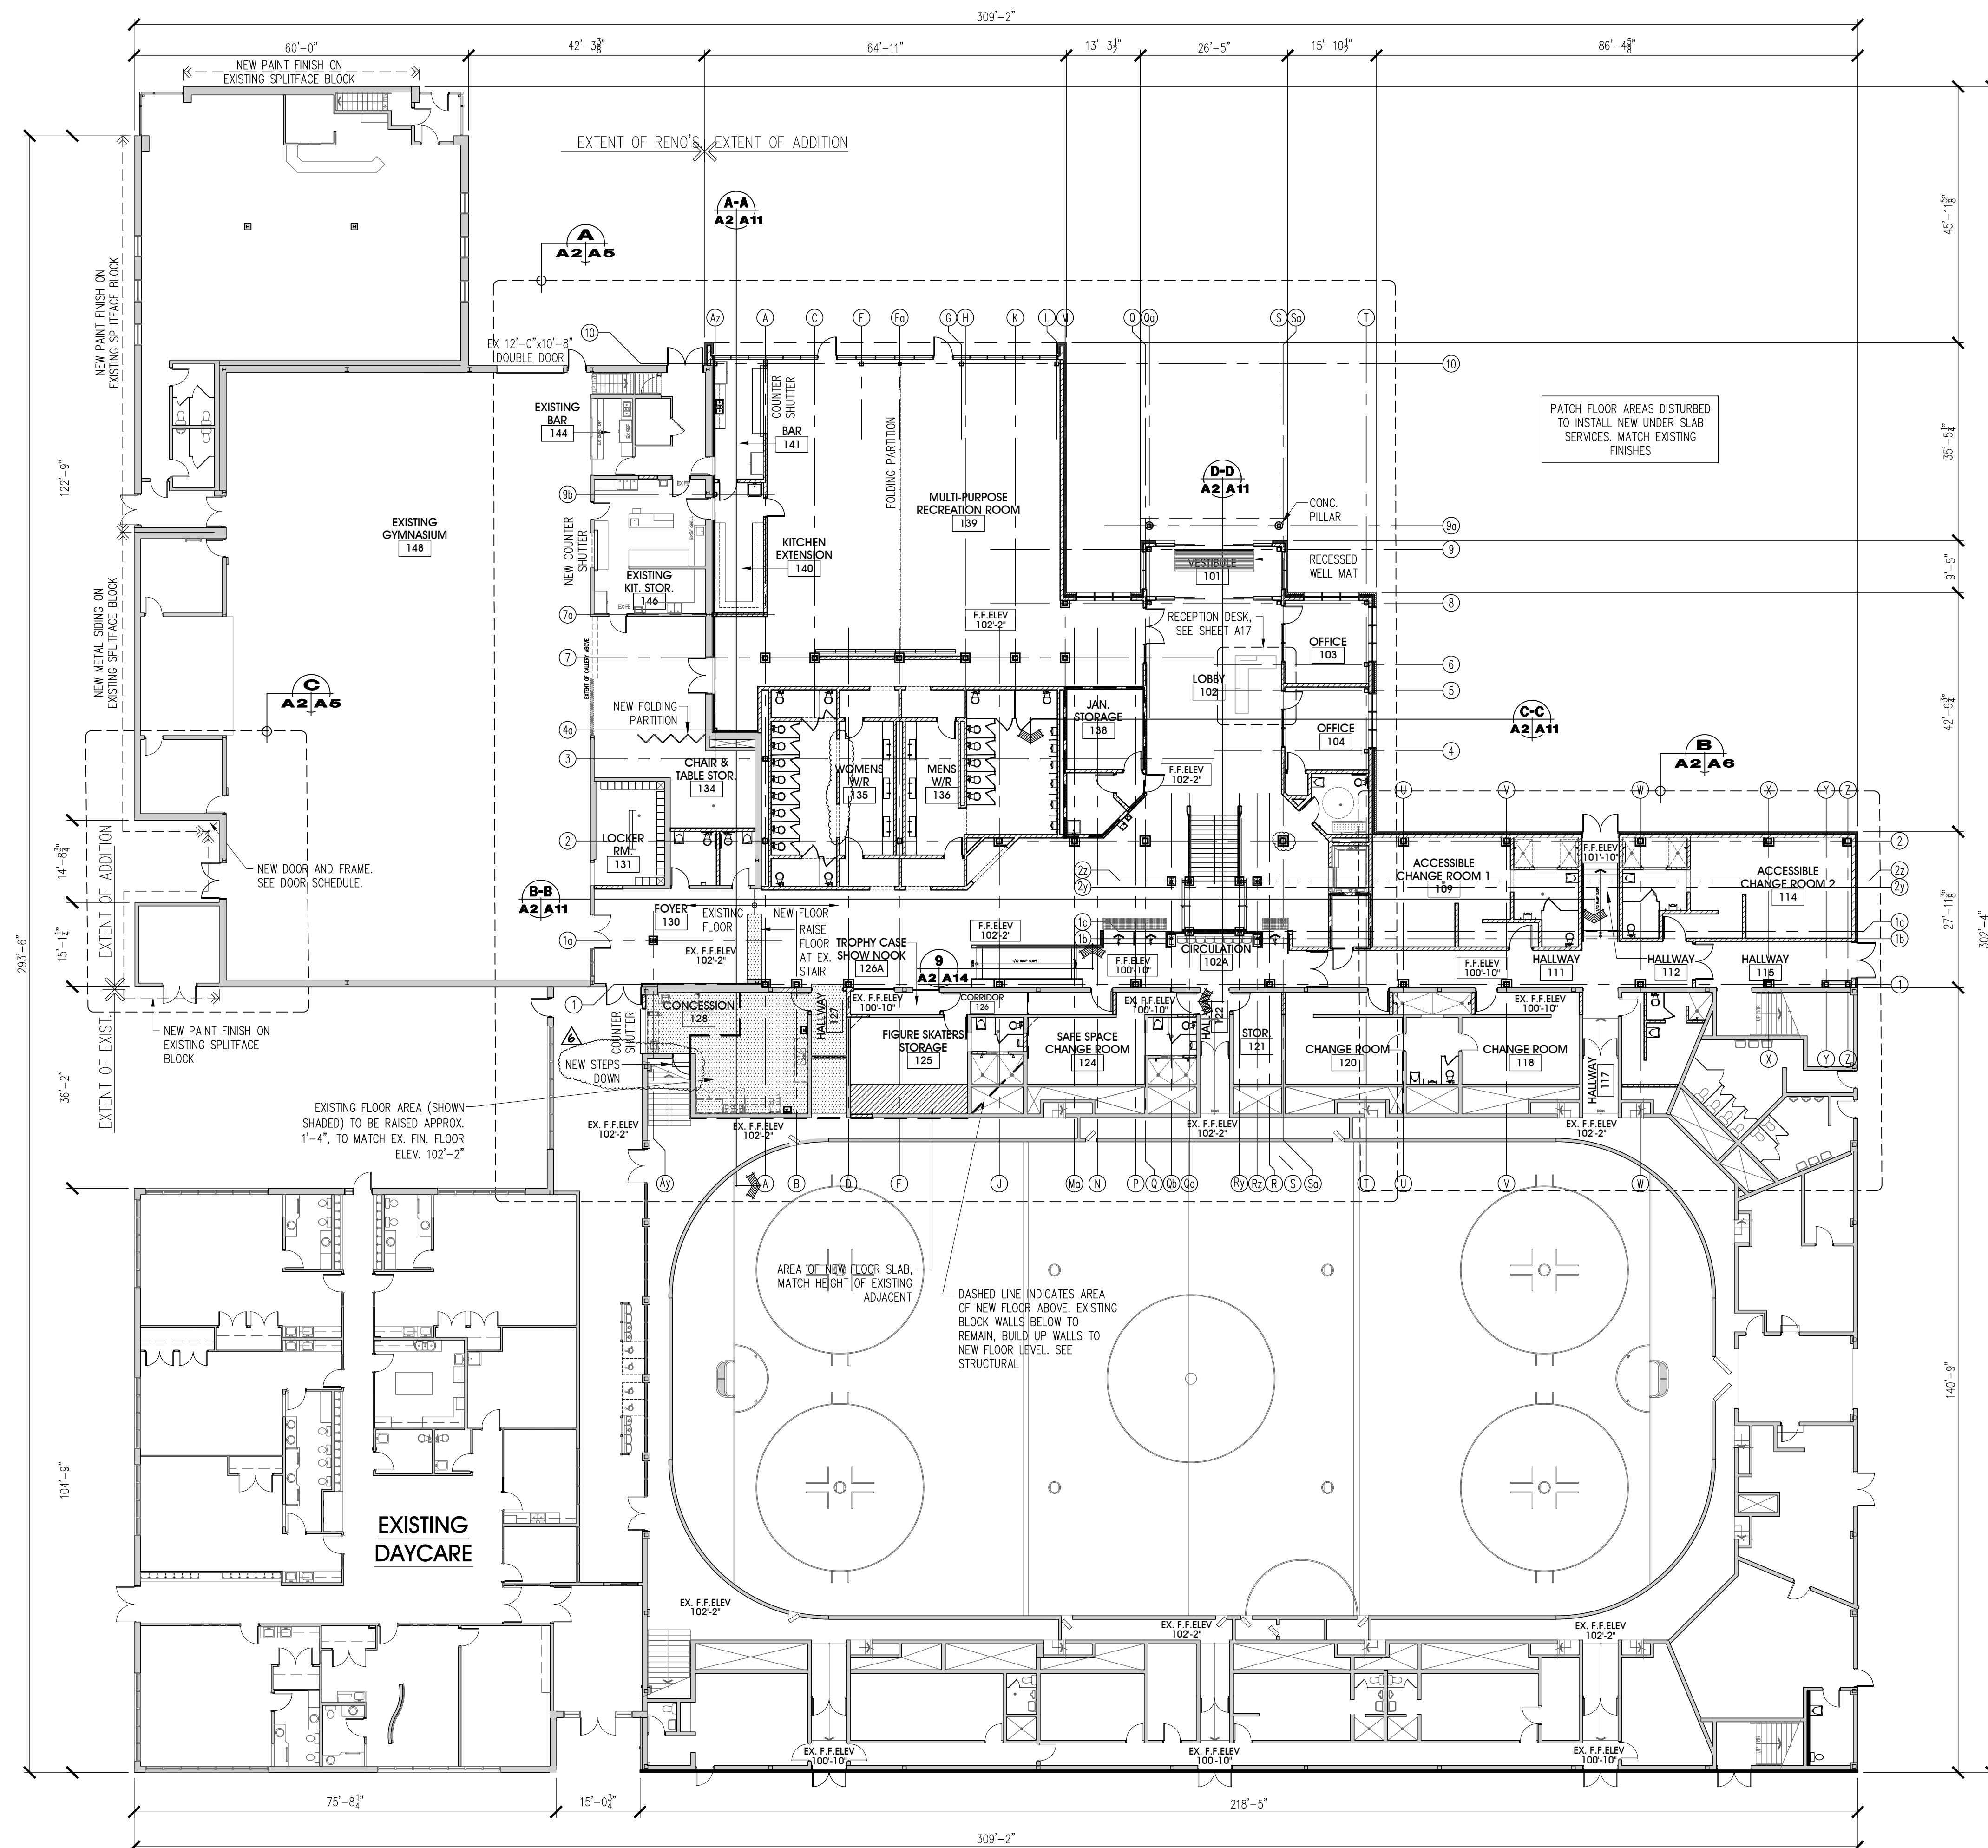



OVERALL GROUND FLOOR PLAN

SCALE: 1/16" = 1'-0"

ISSUED FOR PERMIT	FEB. 01/22	
ADDENDA #6	JAN. 7/22	
ADDENDA #2	DEC. 15/21	
ISSUED FOR TENDER	DEC. 01/21	
revisions	date	no.


**CONTRACTORS MUST CHECK AND
VERIFY ALL DIMENSIONS AND REPORT
ANY DISCREPANCY TO THIS FIRM
BEFORE PROCEEDING WITH THE WORK**

A - detail no.
B - location sheet
C - detail sheet

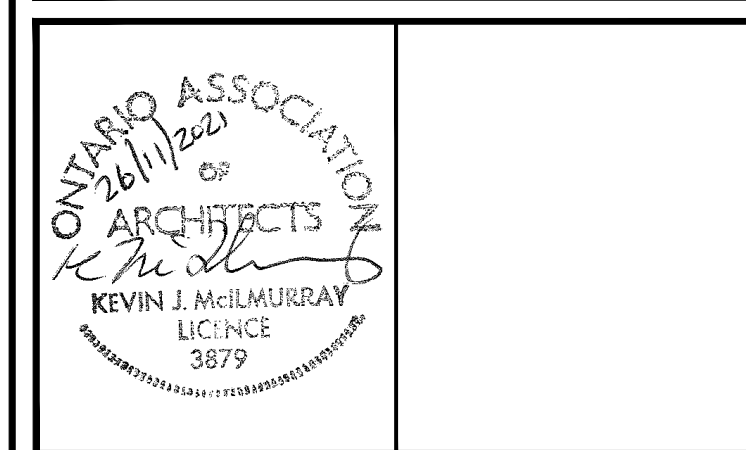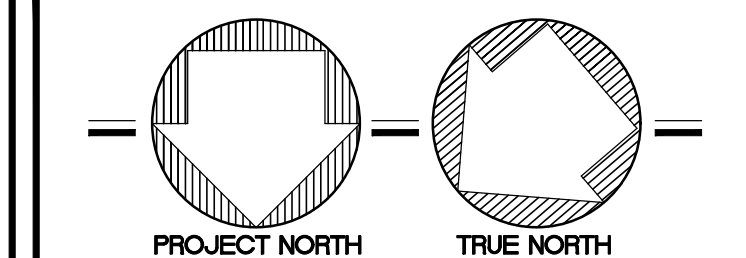
SPRIET
ASSOCIATES

**LUCAN BIDDULPH
COMMUNITY
MEMORIAL CENTRE
PHASE 2 - LUCAN ARENA
RENO'S & ARENA ADDITION**
263 & 265 MAIN STREET, LUCAN, ONTARIO

drawing title :		drawing no. : A2
OVERALL GROUND FLOOR PLAN		
date : NOV. 26, 2021		
scale : AS NOTED		
drawn by : RP		
project no. : 216255-2		

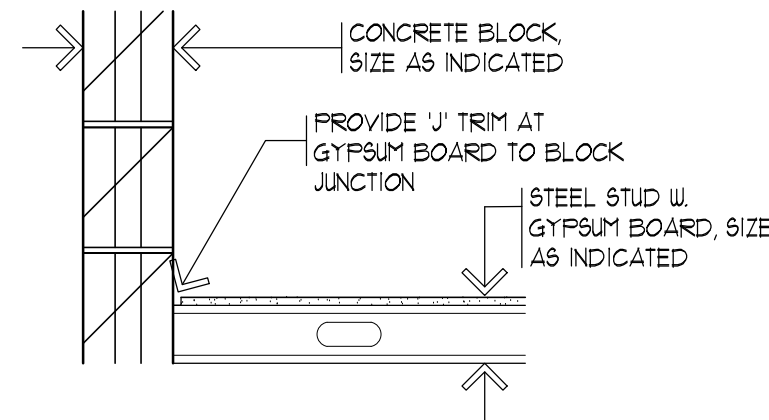

TYPICAL BLOCK TO GYPSUM BOARD JUNCTION

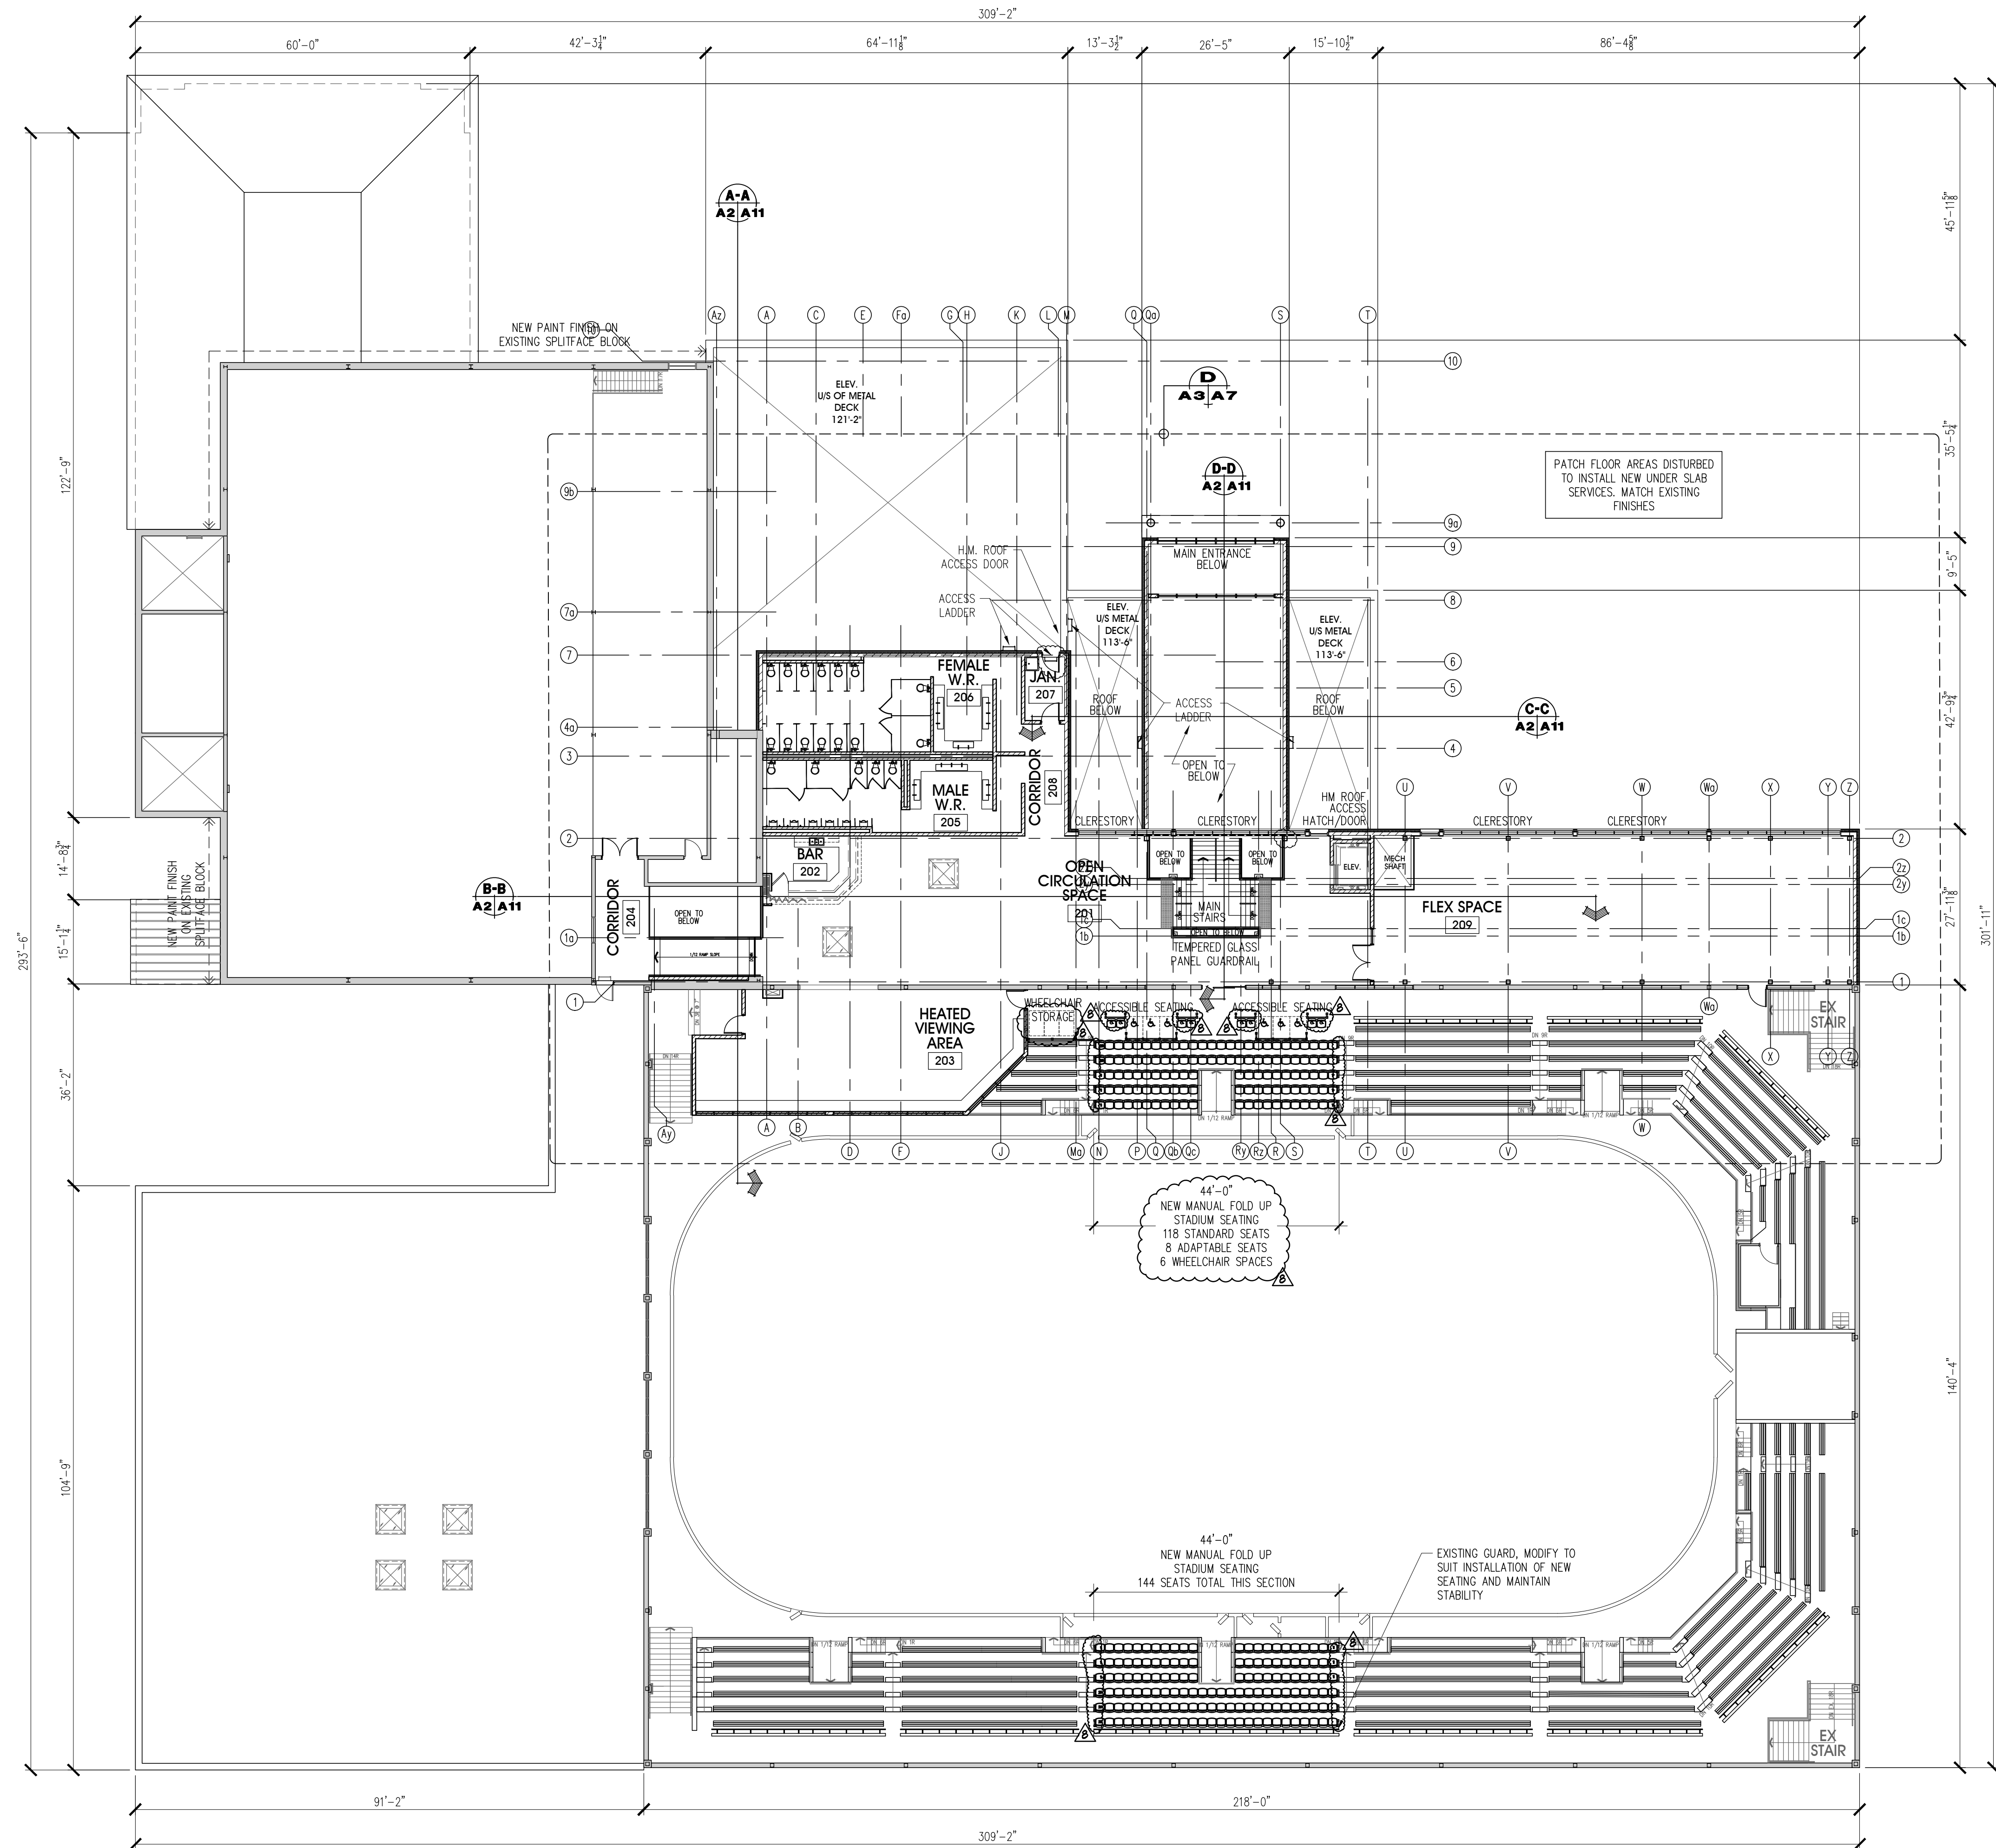



OVERALL SECOND FLOOR PLAN

SCALE: 1/16" = 1'-0"

ISSUED FOR PERMIT	FEB. 01/22	
ADDENDA #8	JAN. 31/22	8
ADDENDA #2	DEC. 15/21	2
ISSUED FOR TENDER	DEC. 01/21	-
revisions	date	no.

CONTRACTORS MUST CHECK AND VERIFY ALL DIMENSIONS AND REPORT ANY DISCREPANCY TO THIS FIRM BEFORE PROCEEDING WITH THE WORK

A - detail no.
B - location sheet
C - detail sheet

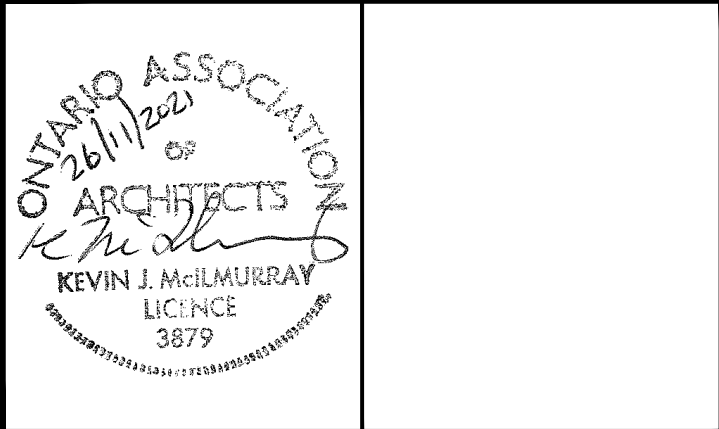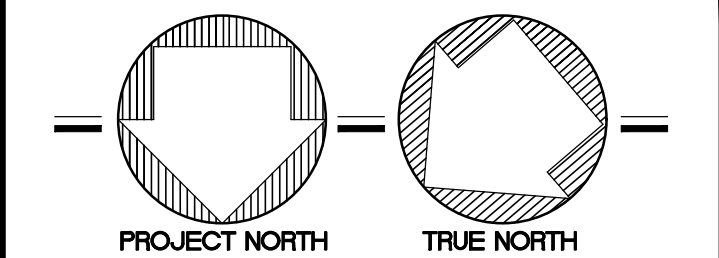


SPRIET ASSOCIATES

LIMITED architects
LONDON LTD. engineers
155 York Street - London - N6A 1A8
phone : (519) 672-4100 fax : (519) 433-9351
e-mail : mail@spriet.on.ca

LUCAN BIDDULPH COMMUNITY MEMORIAL CENTRE
PHASE 2 - LUCAN ARENA
RENO'S & ARENA ADDITION
263 & 265 MAIN STREET, LUCAN, ONTARIO

drawing title :	OVERALL SECOND FLOOR PLAN	drawing no. :	A3
date :	NOV. 26, 2021	scale :	AS NOTED
drawn by :	RP	project no. :	216255-2

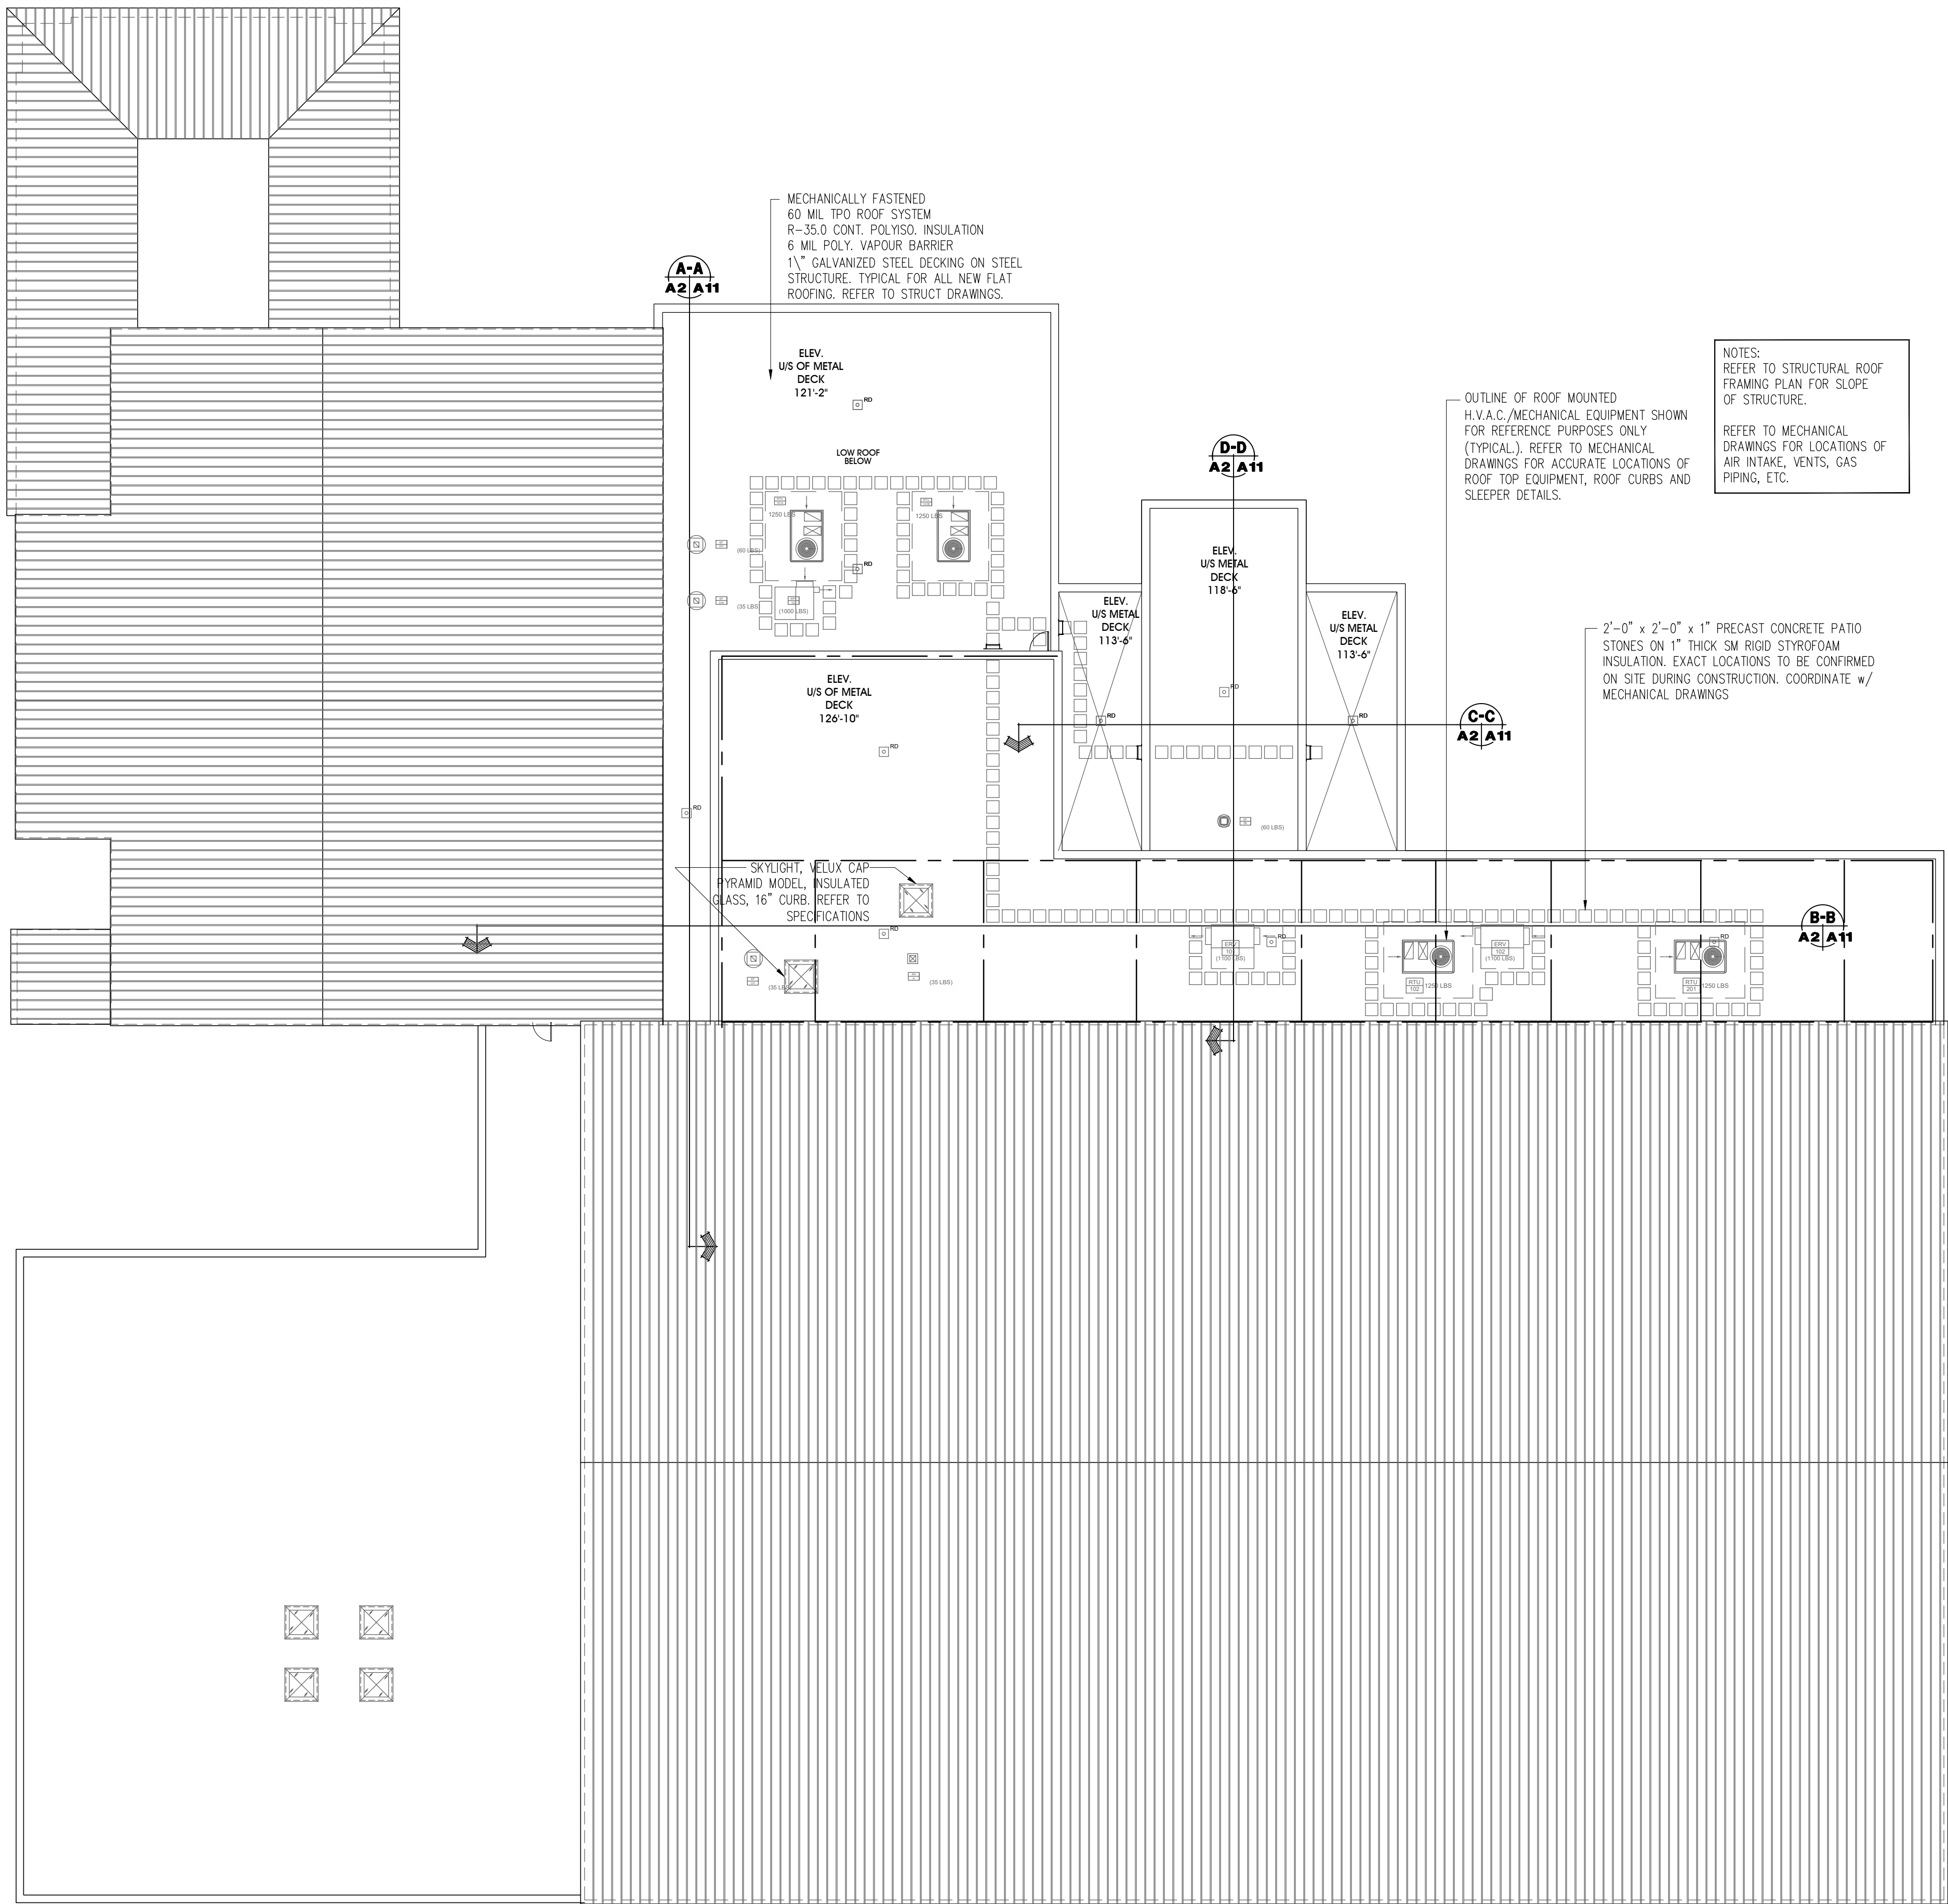



OVERALL ROOF FLOOR PLAN

SCALE: 1/16" = 1'-0"

ISSUED FOR PERMIT	FEB. 01/22	
ADDENDA #2	DEC. 15/21	
ISSUED FOR TENDER	DEC. 01/21	
revisions	date	no.

CONTRACTORS MUST CHECK AND VERIFY ALL DIMENSIONS AND REPORT ANY DISCREPANCY TO THIS FIRM BEFORE PROCEEDING WITH THE WORK

A - detail no.
B - location sheet
C - detail sheet

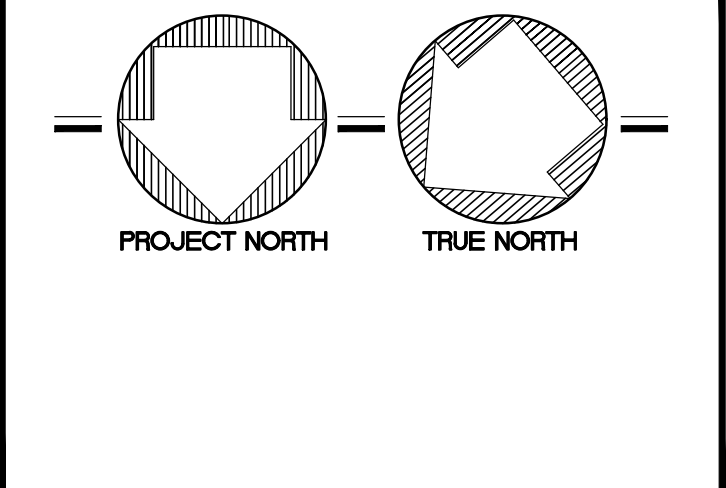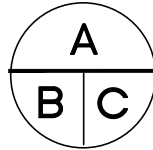




SPRIET ASSOCIATES

LIMITED architects
LONDON LTD. engineers







155 york street - london - N6A 1A8
phone : (519) 672-4100 fax : (519) 433-9351
e-mail : mail@spriet.on.ca

LUCAN BIDDULPH COMMUNITY MEMORIAL CENTRE
PHASE 2 - LUCAN ARENA
RENO'S & ARENA ADDITION
263 & 265 MAIN STREET, LUCAN, ONTARIO

drawing title : OVERALL ROOF PLAN	
date : NOV. 26, 2021	drawing no. : A4
scale : AS NOTED	
drawn by : RP	
project no. : 216255-2	

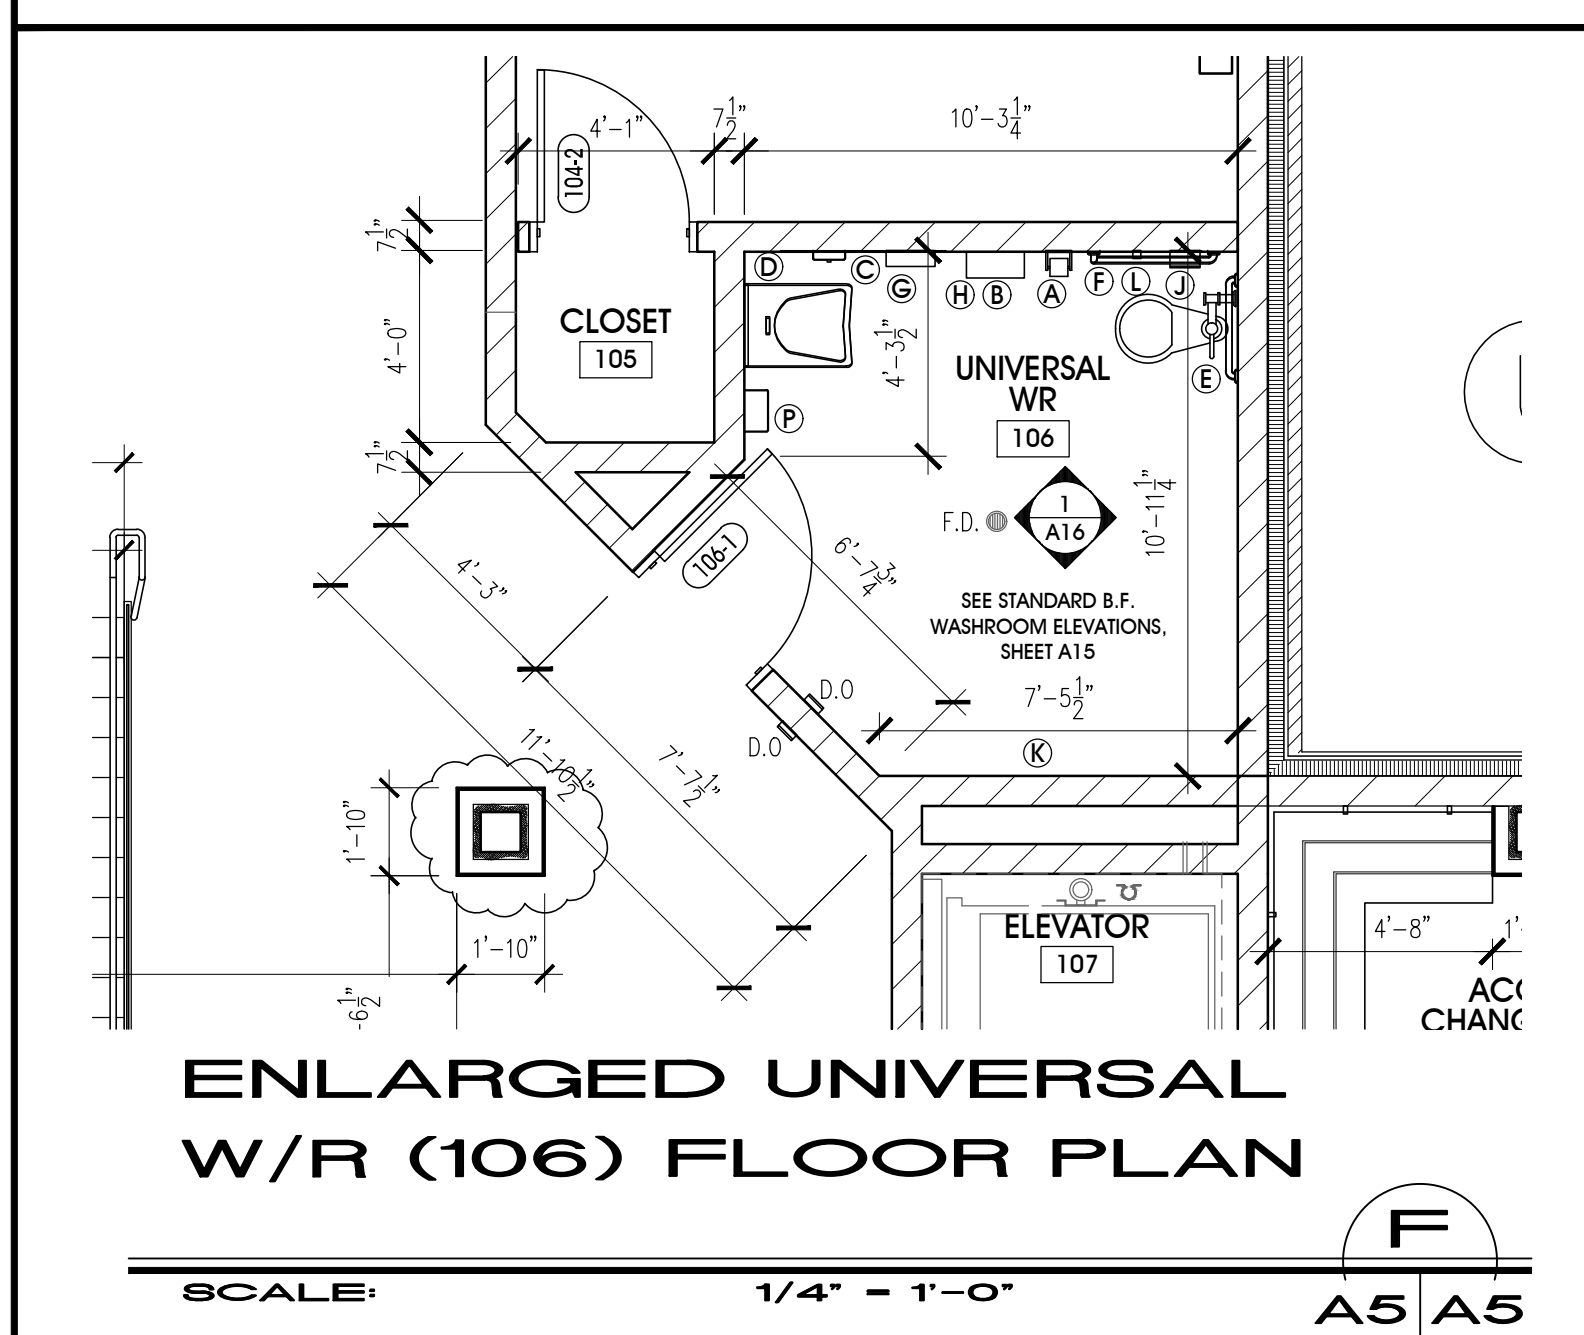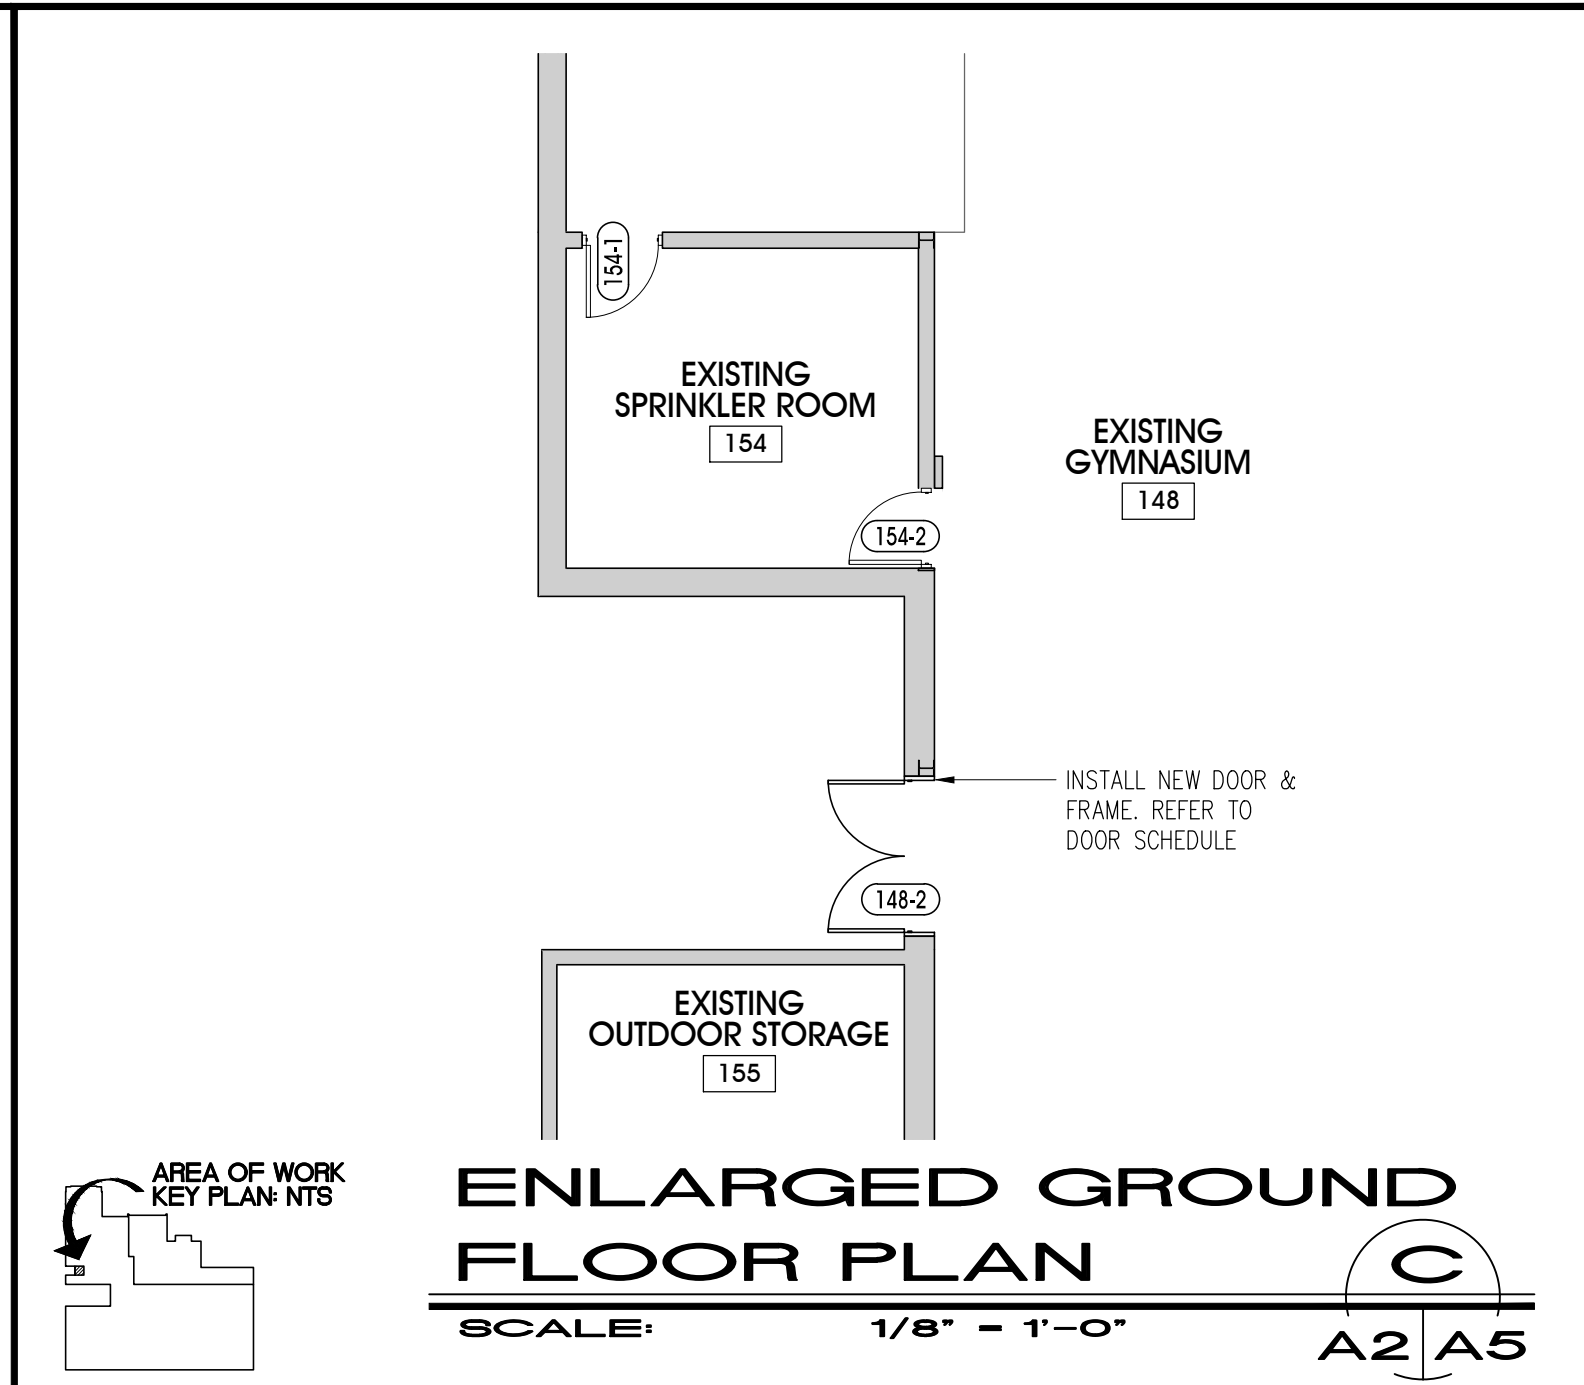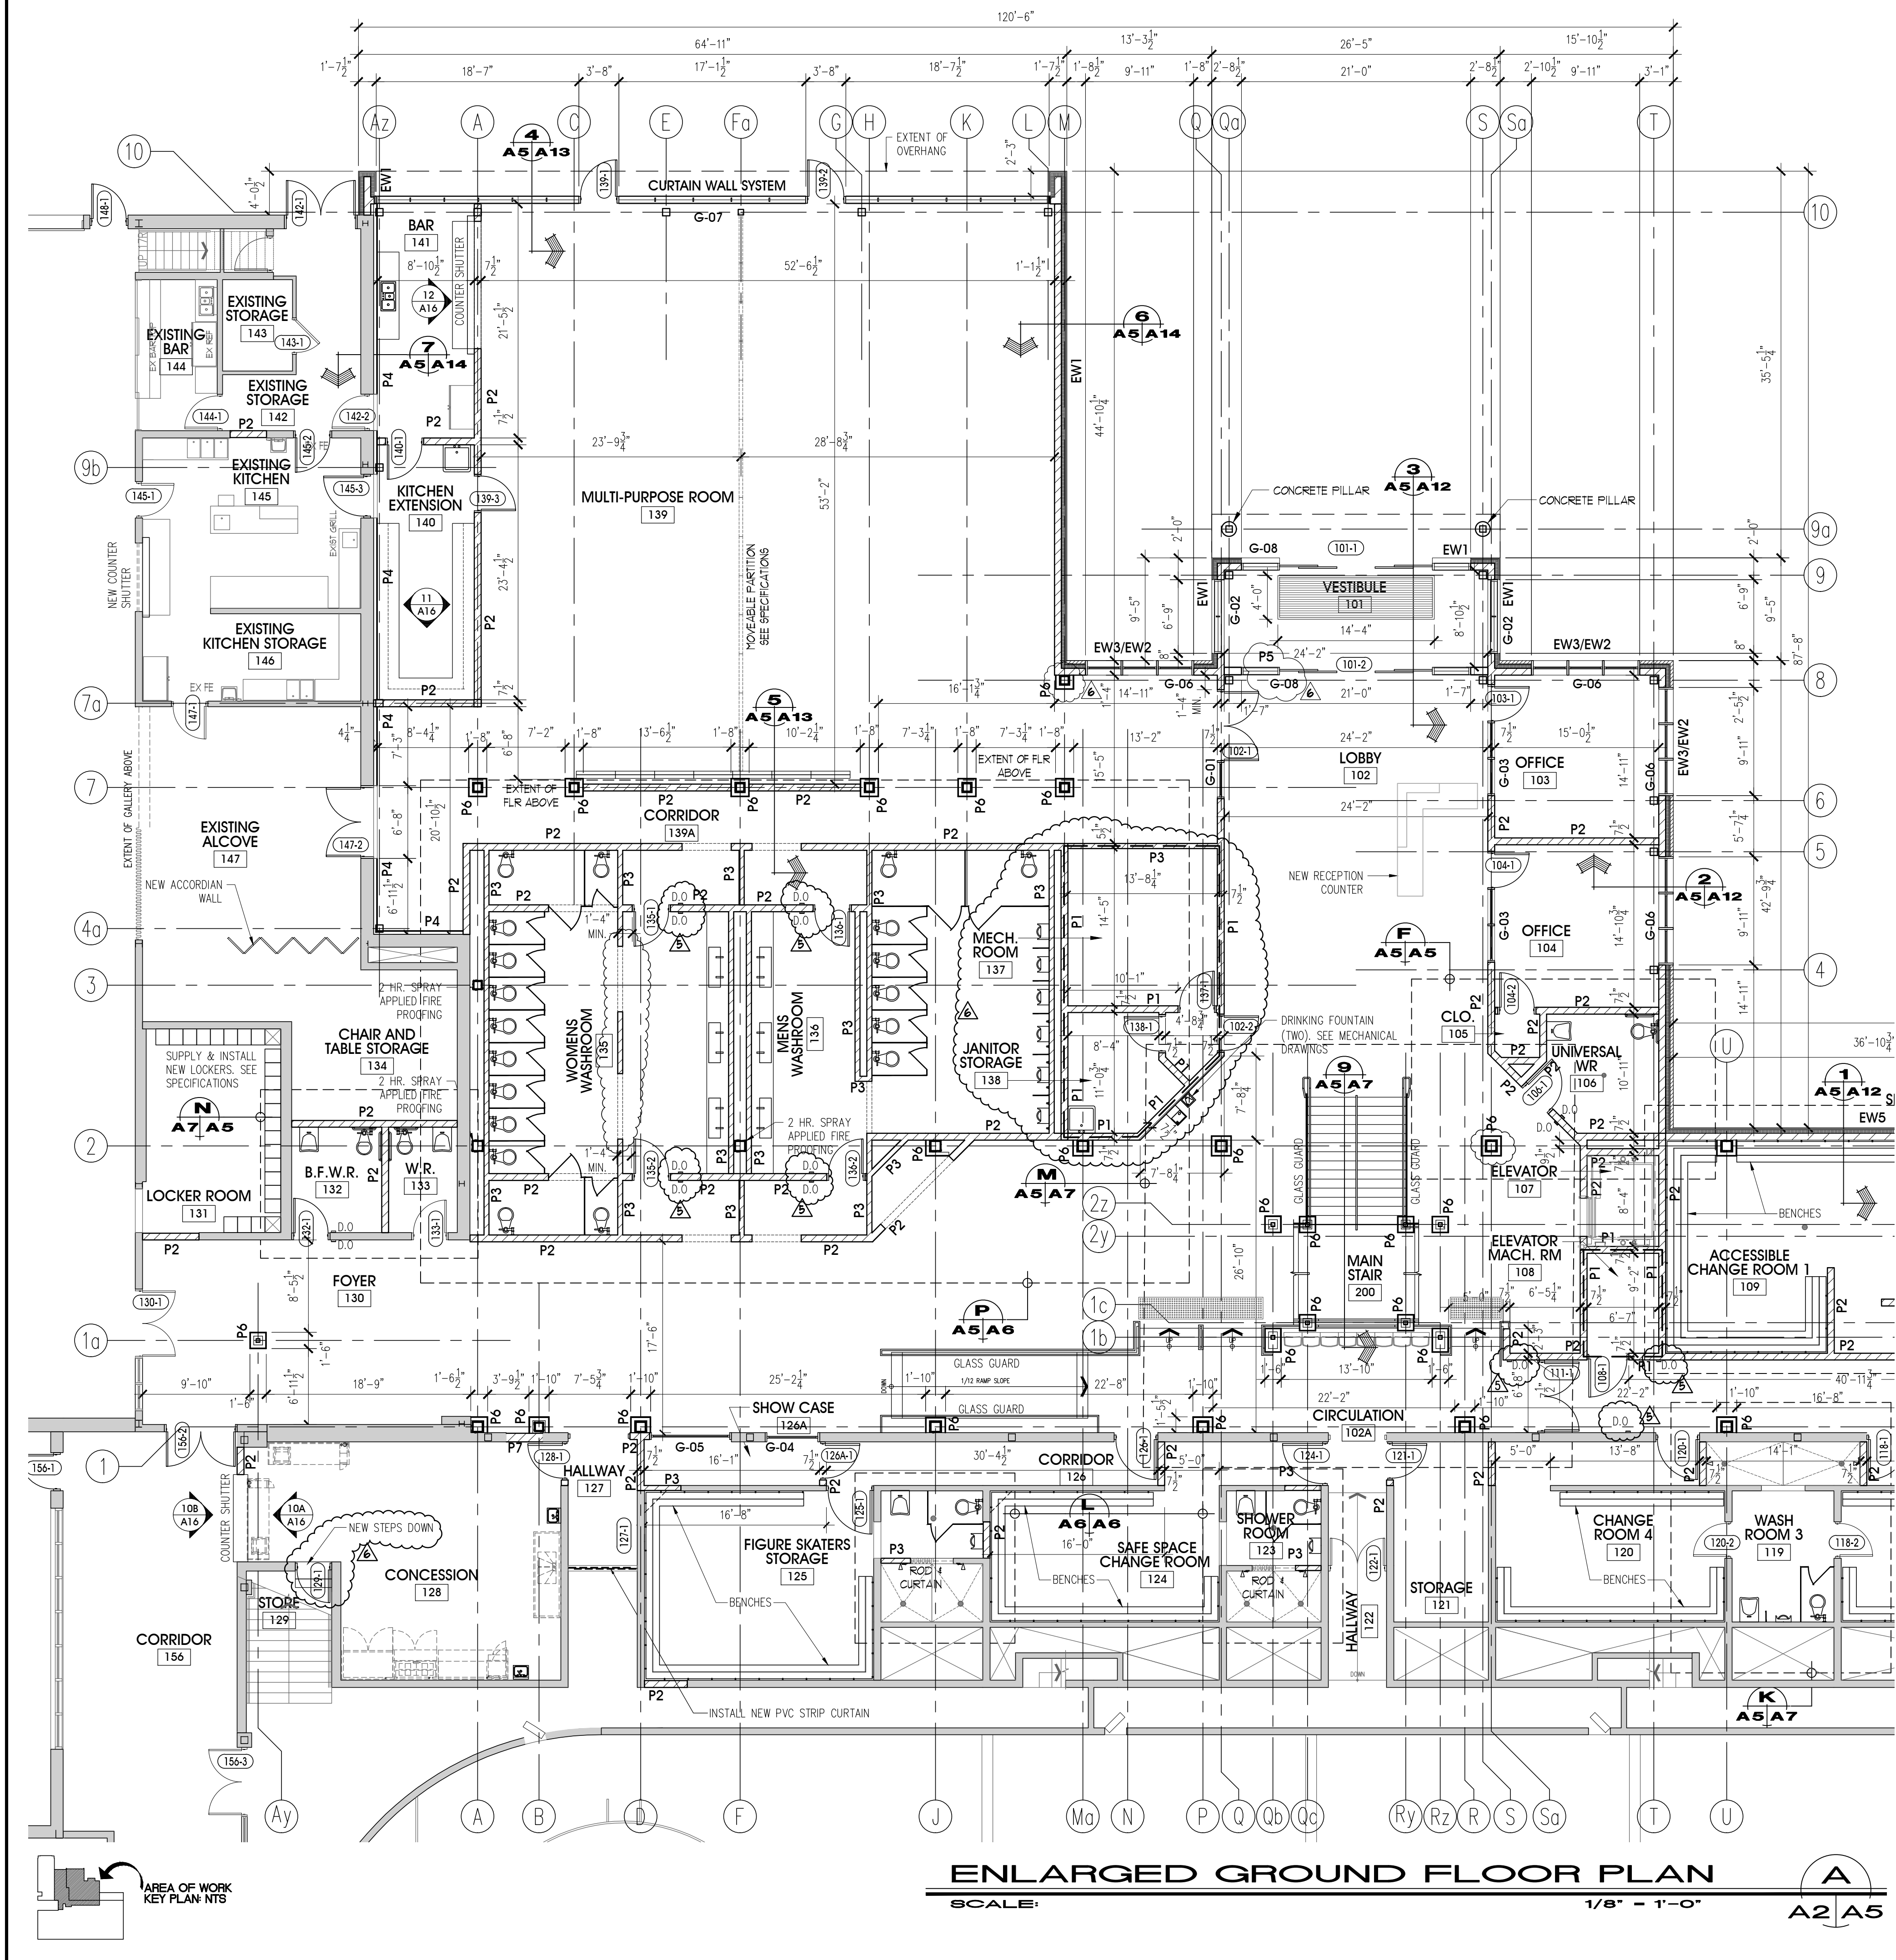



WASHROOM ACCESSORIES LEGEND:	
REFER TO INTERIOR ELEVATIONS FOR MOUNTING HEIGHTS & LOCATIONS. REFER TO PROJECT SPECIFICATIONS FOR PRODUCT INFORMATION ALL ITEMS TO BE INSTALLED IN ACCORDANCE WITH CURRENT O.B.C. REQUIREMENTS, WHERE APPLICABLE	
(A) TOILET TISSUE DISPENSER	(Q) TOWEL BAR
(B) PAPER TOWEL DISPENSER / GARBAGE	(R) FOLD DOWN SHOWER SEAT, MANUAL OPER.
(C) SOAP DISPENSER	(S) FULLY RECESSED SOAP HOLDER
(D) MIRROR	(T) 48" GRAB BAR (VERTICAL)
(E) 24" GRAB BAR	
(F) CONTINUOUS 'L-SHAPED' GRAB BAR	
(G) SHELF	
(H) COAT HOOK	
(J) SANITARY NAPKIN DISPOSAL	
(K) BABY CHANGE TABLE (FUTURE ADULT SIZE CHANGE TABLE, UNIVERSAL W.R. [106] ONLY)	
(L) EMERGENCY CALL BUTTON SYSTEM COMPLETE WITH AUDIBLE AND VISUAL SIGNAL DEVICES INSIDE & OUTSIDE OF THE WASHROOM. ACTIVATED BY A CONTROL DEVICE INSIDE THE WASHROOM. EMERGENCY SIGN THAT CONTAINS THE WORDS "IN THE EVENT OF AN EMERGENCY PUSH EMERGENCY BUTION AND AUDIBLE AND VISUAL SIGN WILL ACTIVATE" IN LETTERS AT LEAST 25 mm (1") HIGH W/ A 5 mm (3/16") STROKE AND THAT IS POSTED ABOVE THE EMERGENCY BUTTON. REFER ALSO TO ELECT. DUGS DRAWINGS, UNIVERSAL WASHROOM ELEVATIONS & STANDARD MOUNTING HEIGHTS FOR MORE INFO.	
(M) MOTION SENSOR LIGHTING TO BE CONTROLLED BY A MOTION SENSOR CONFORMING TO SENTENCE 122.41. (2) MOTION SENSORS SHALL BE INSTALLED W/ SWITCH CONTROLLERS EQUIPPED FOR FAIL-SAFE OPERATION & ILLUMINATION TIMERS SET FOR A MINIMUM 15 MINUTE DURATION. REFER TO ELECTRICAL DRAWINGS FOR LOCATION TO BE INSTALLED (MAY BE WALL OR CEILING MOUNTED)	
(N) POWER DOOR OPERATOR (D.O.D.) REFER TO STANDARD MOUNTING HEIGHTS & ELECTRICAL DRAWINGS FOR MORE INFORMATION.	
(P) POWER OPERATED HAND DRYER, DYSON V BLADE (REFER TO ELECTRICAL)	

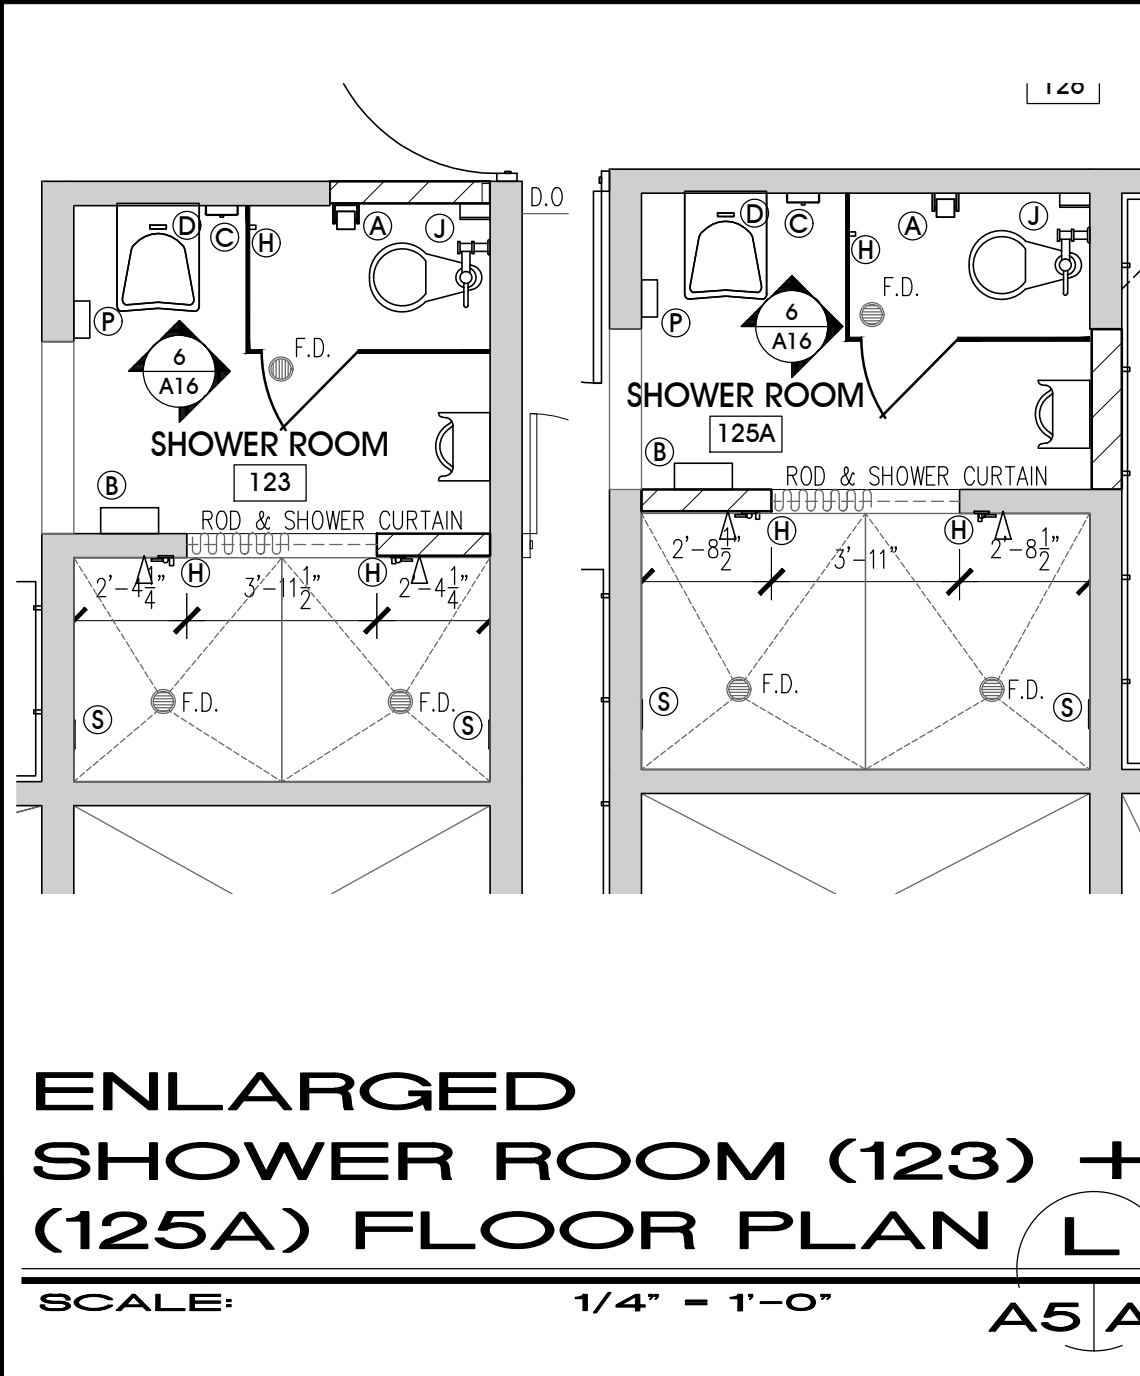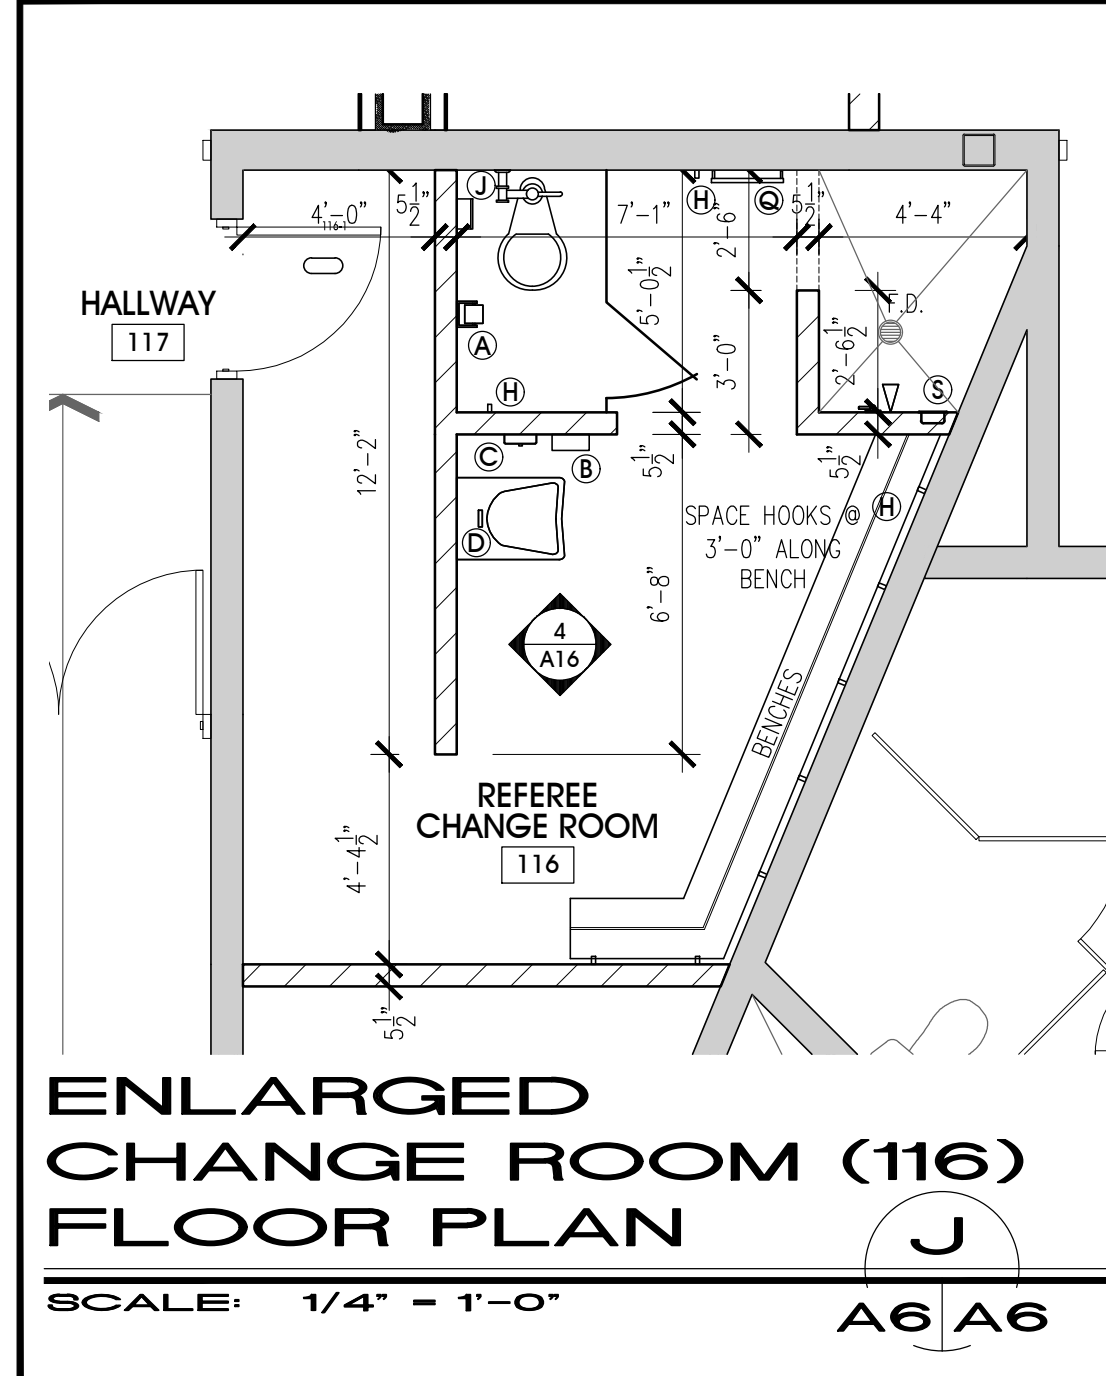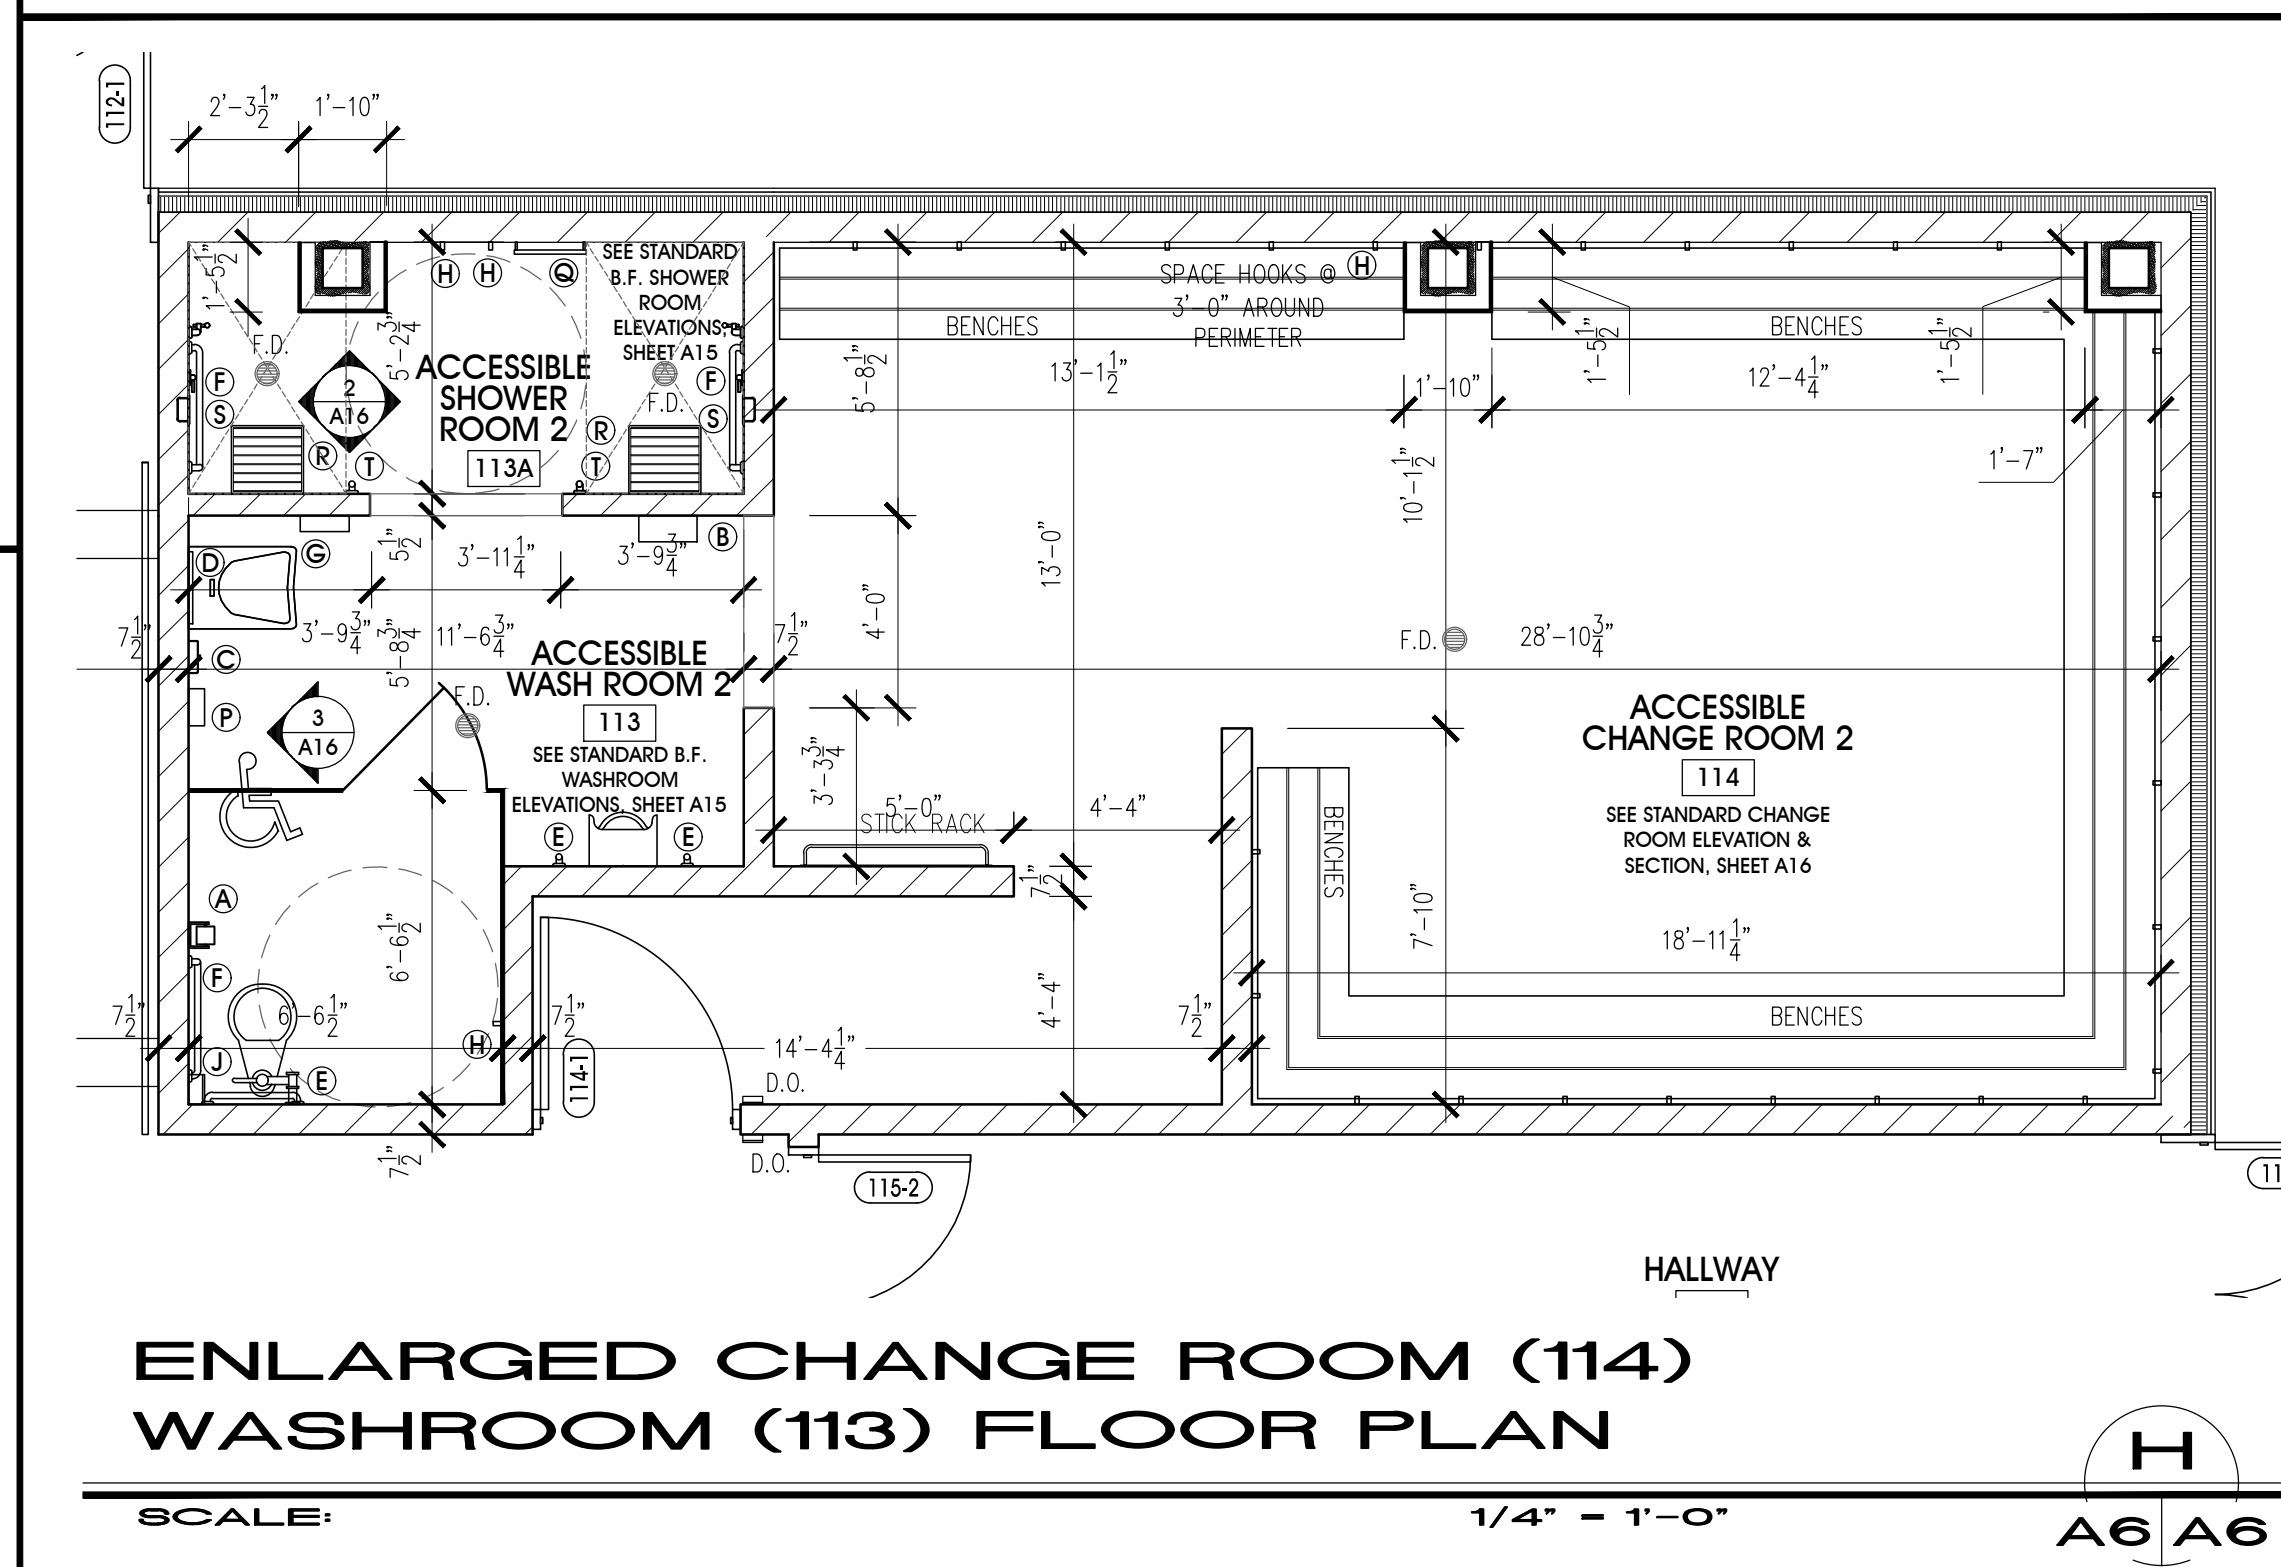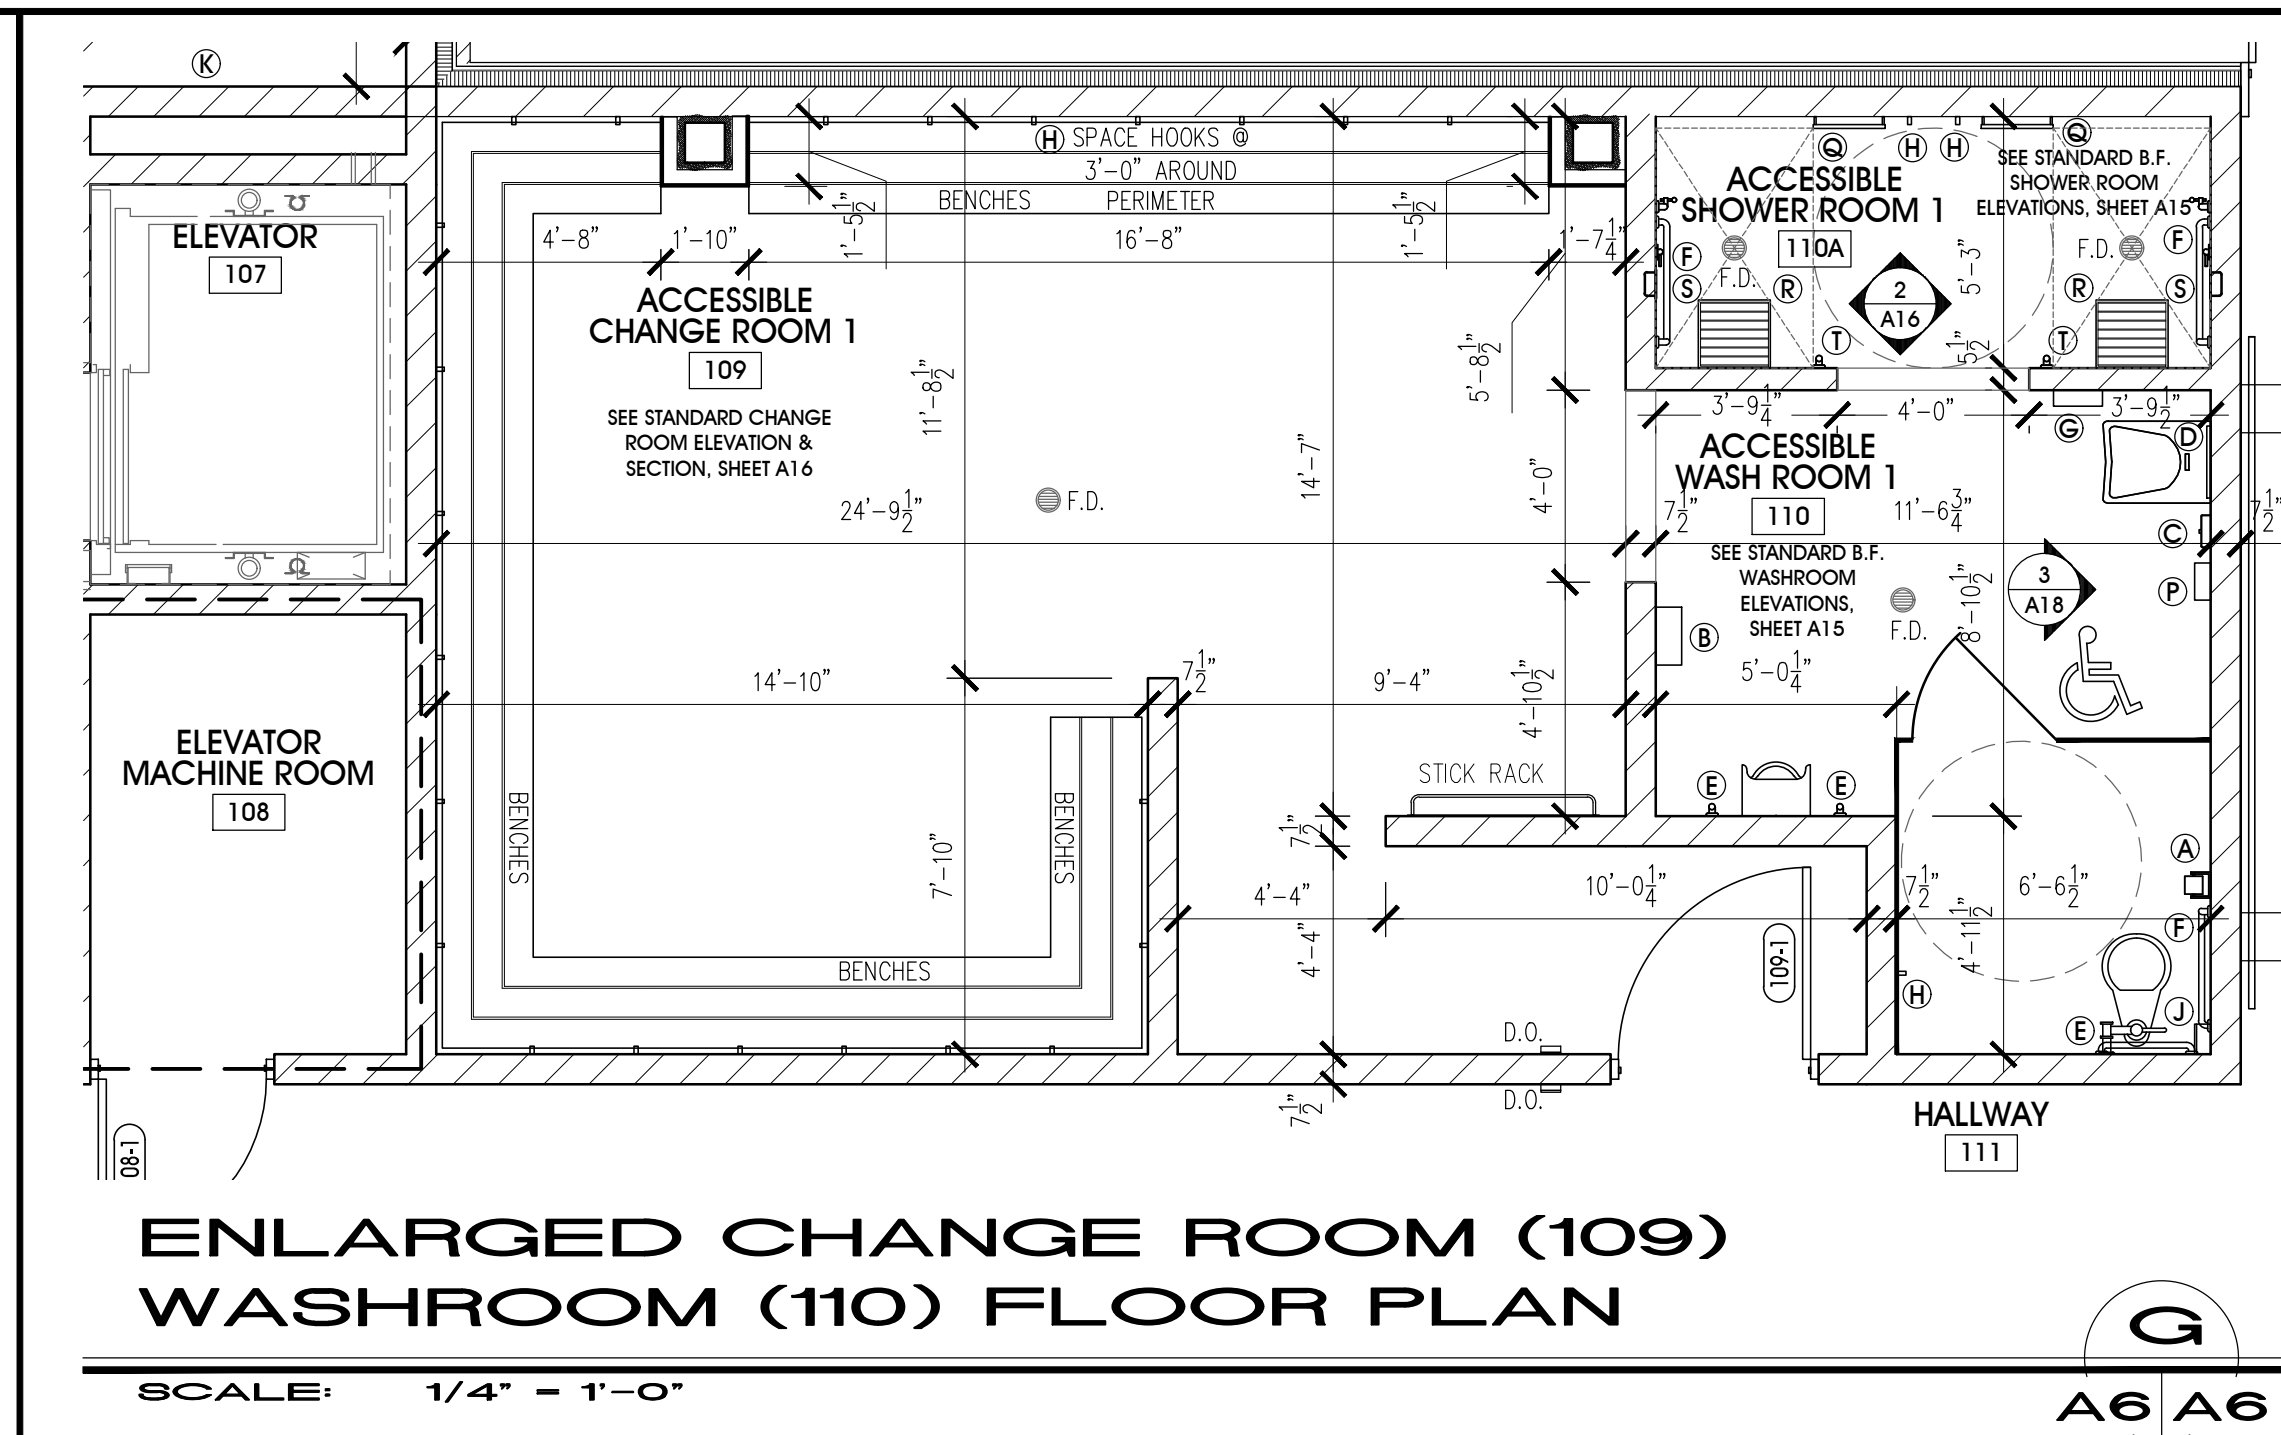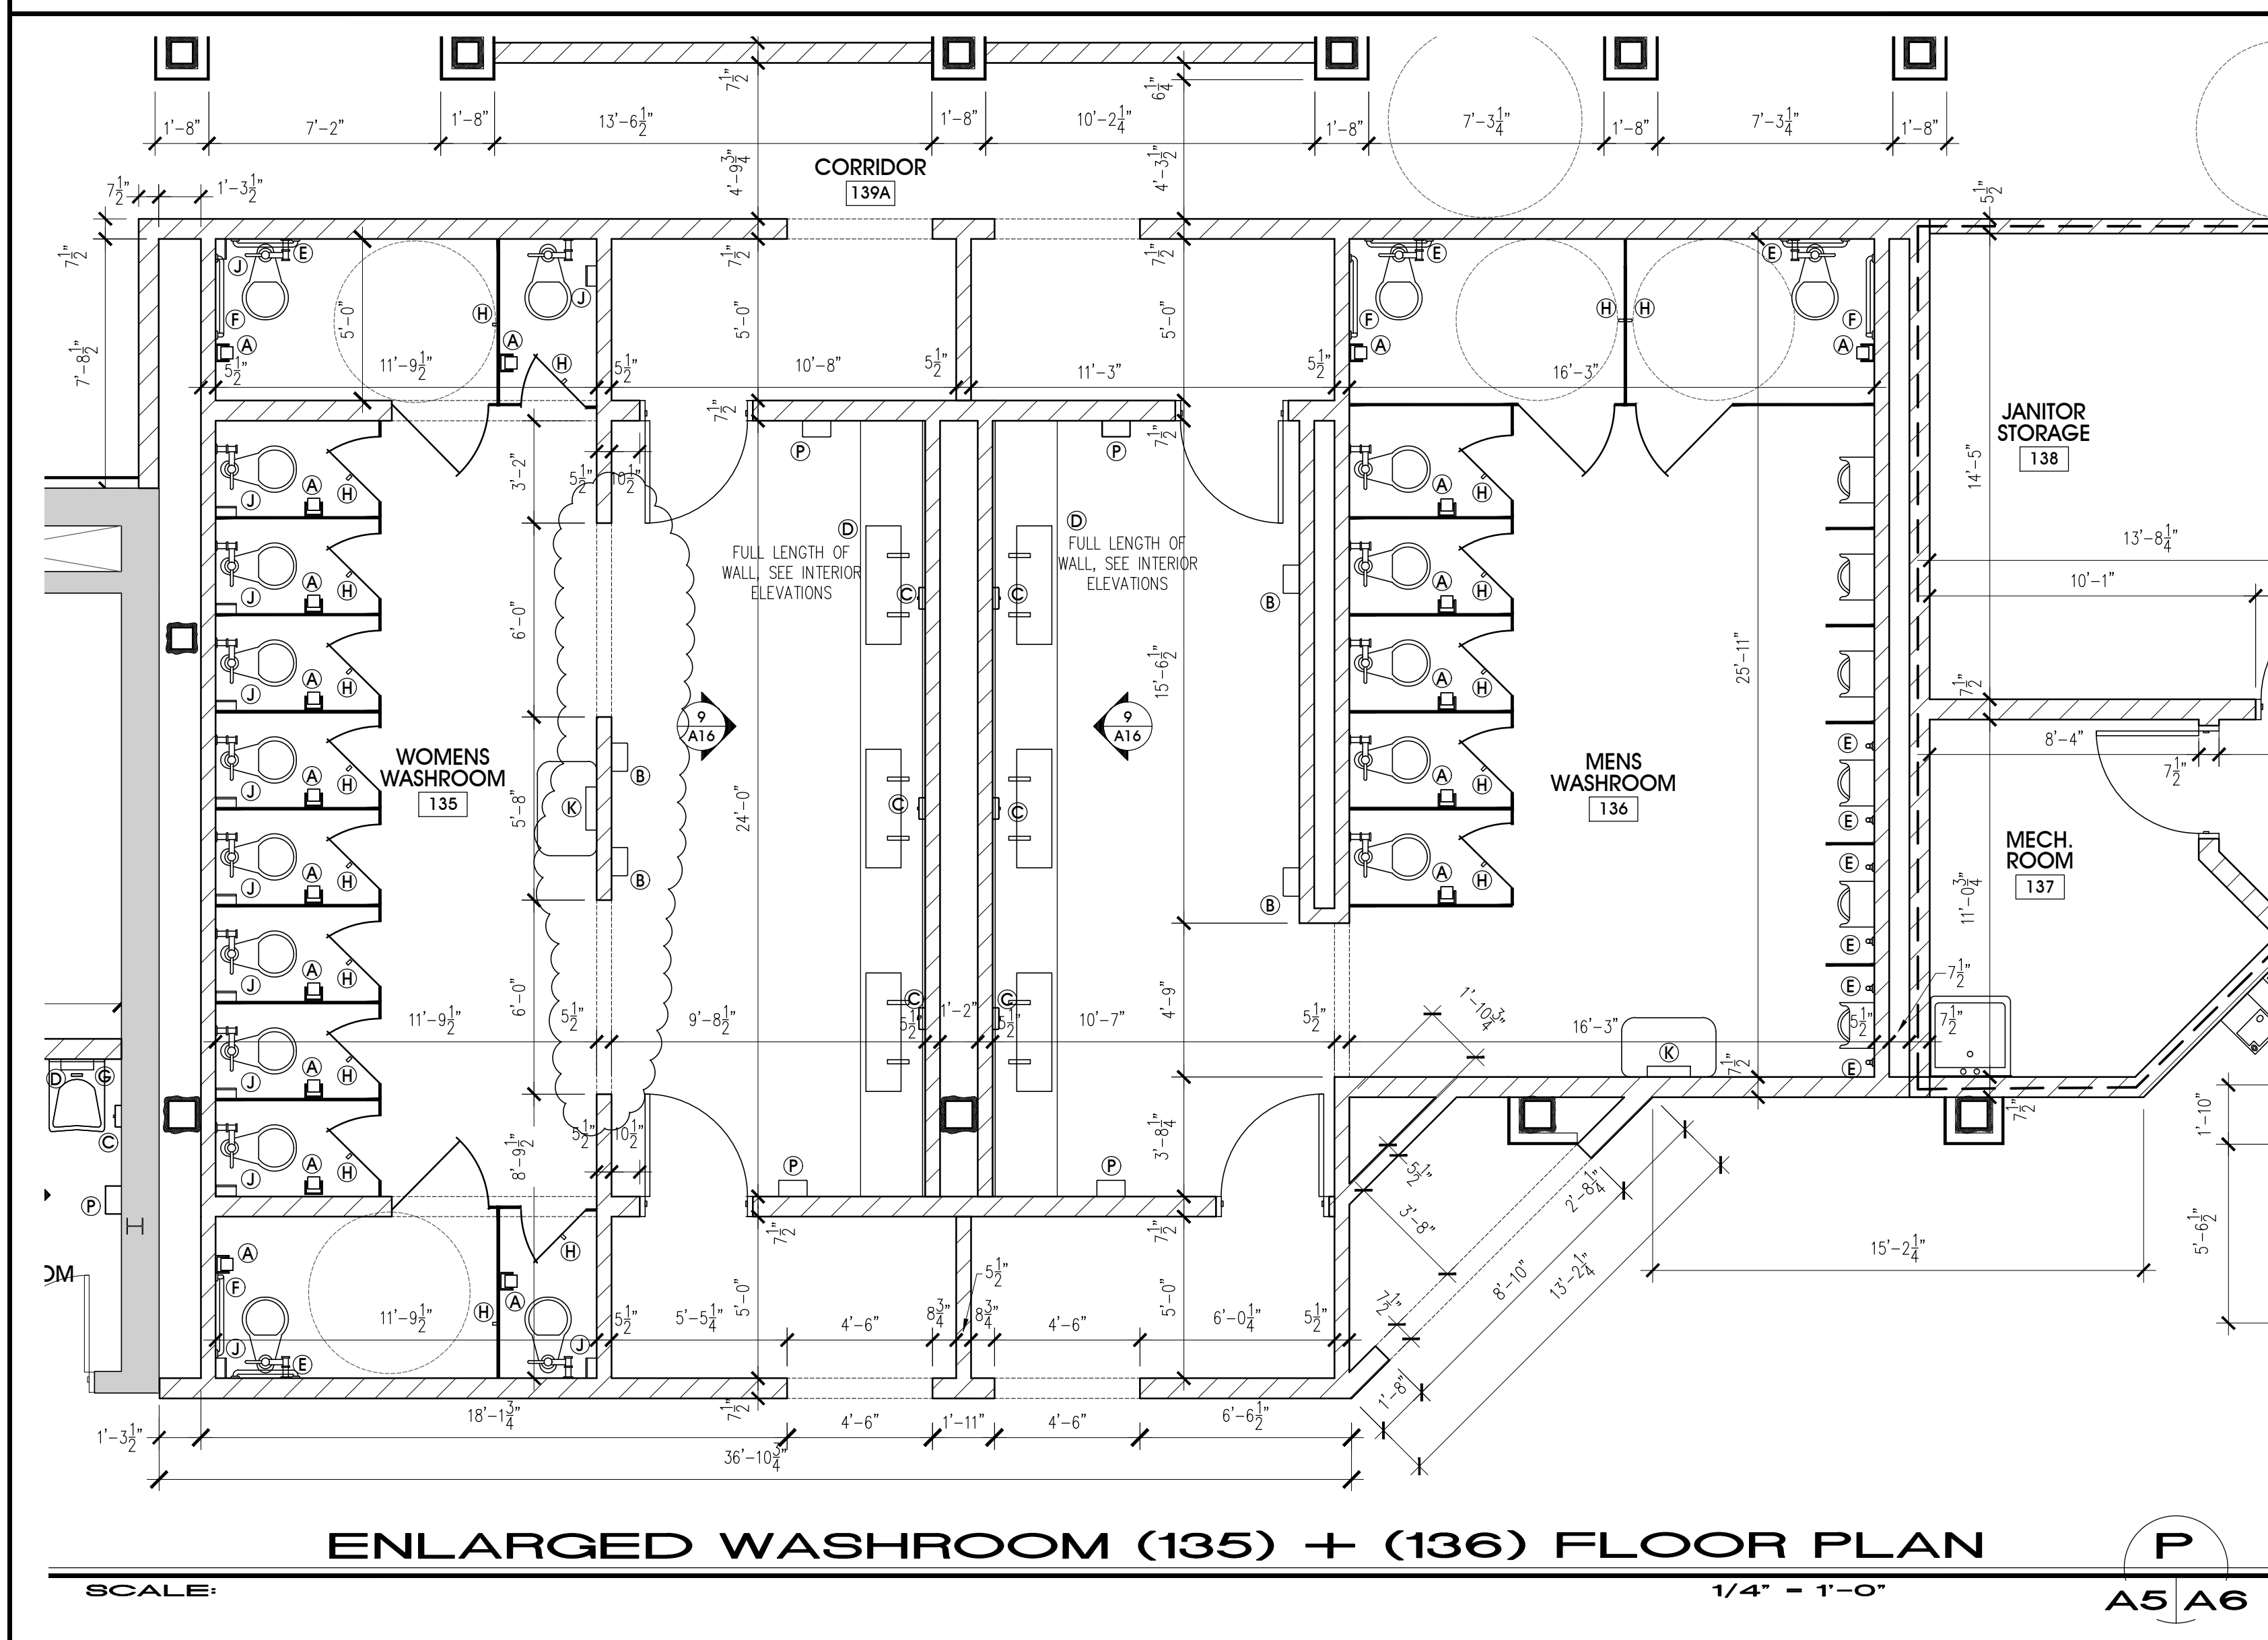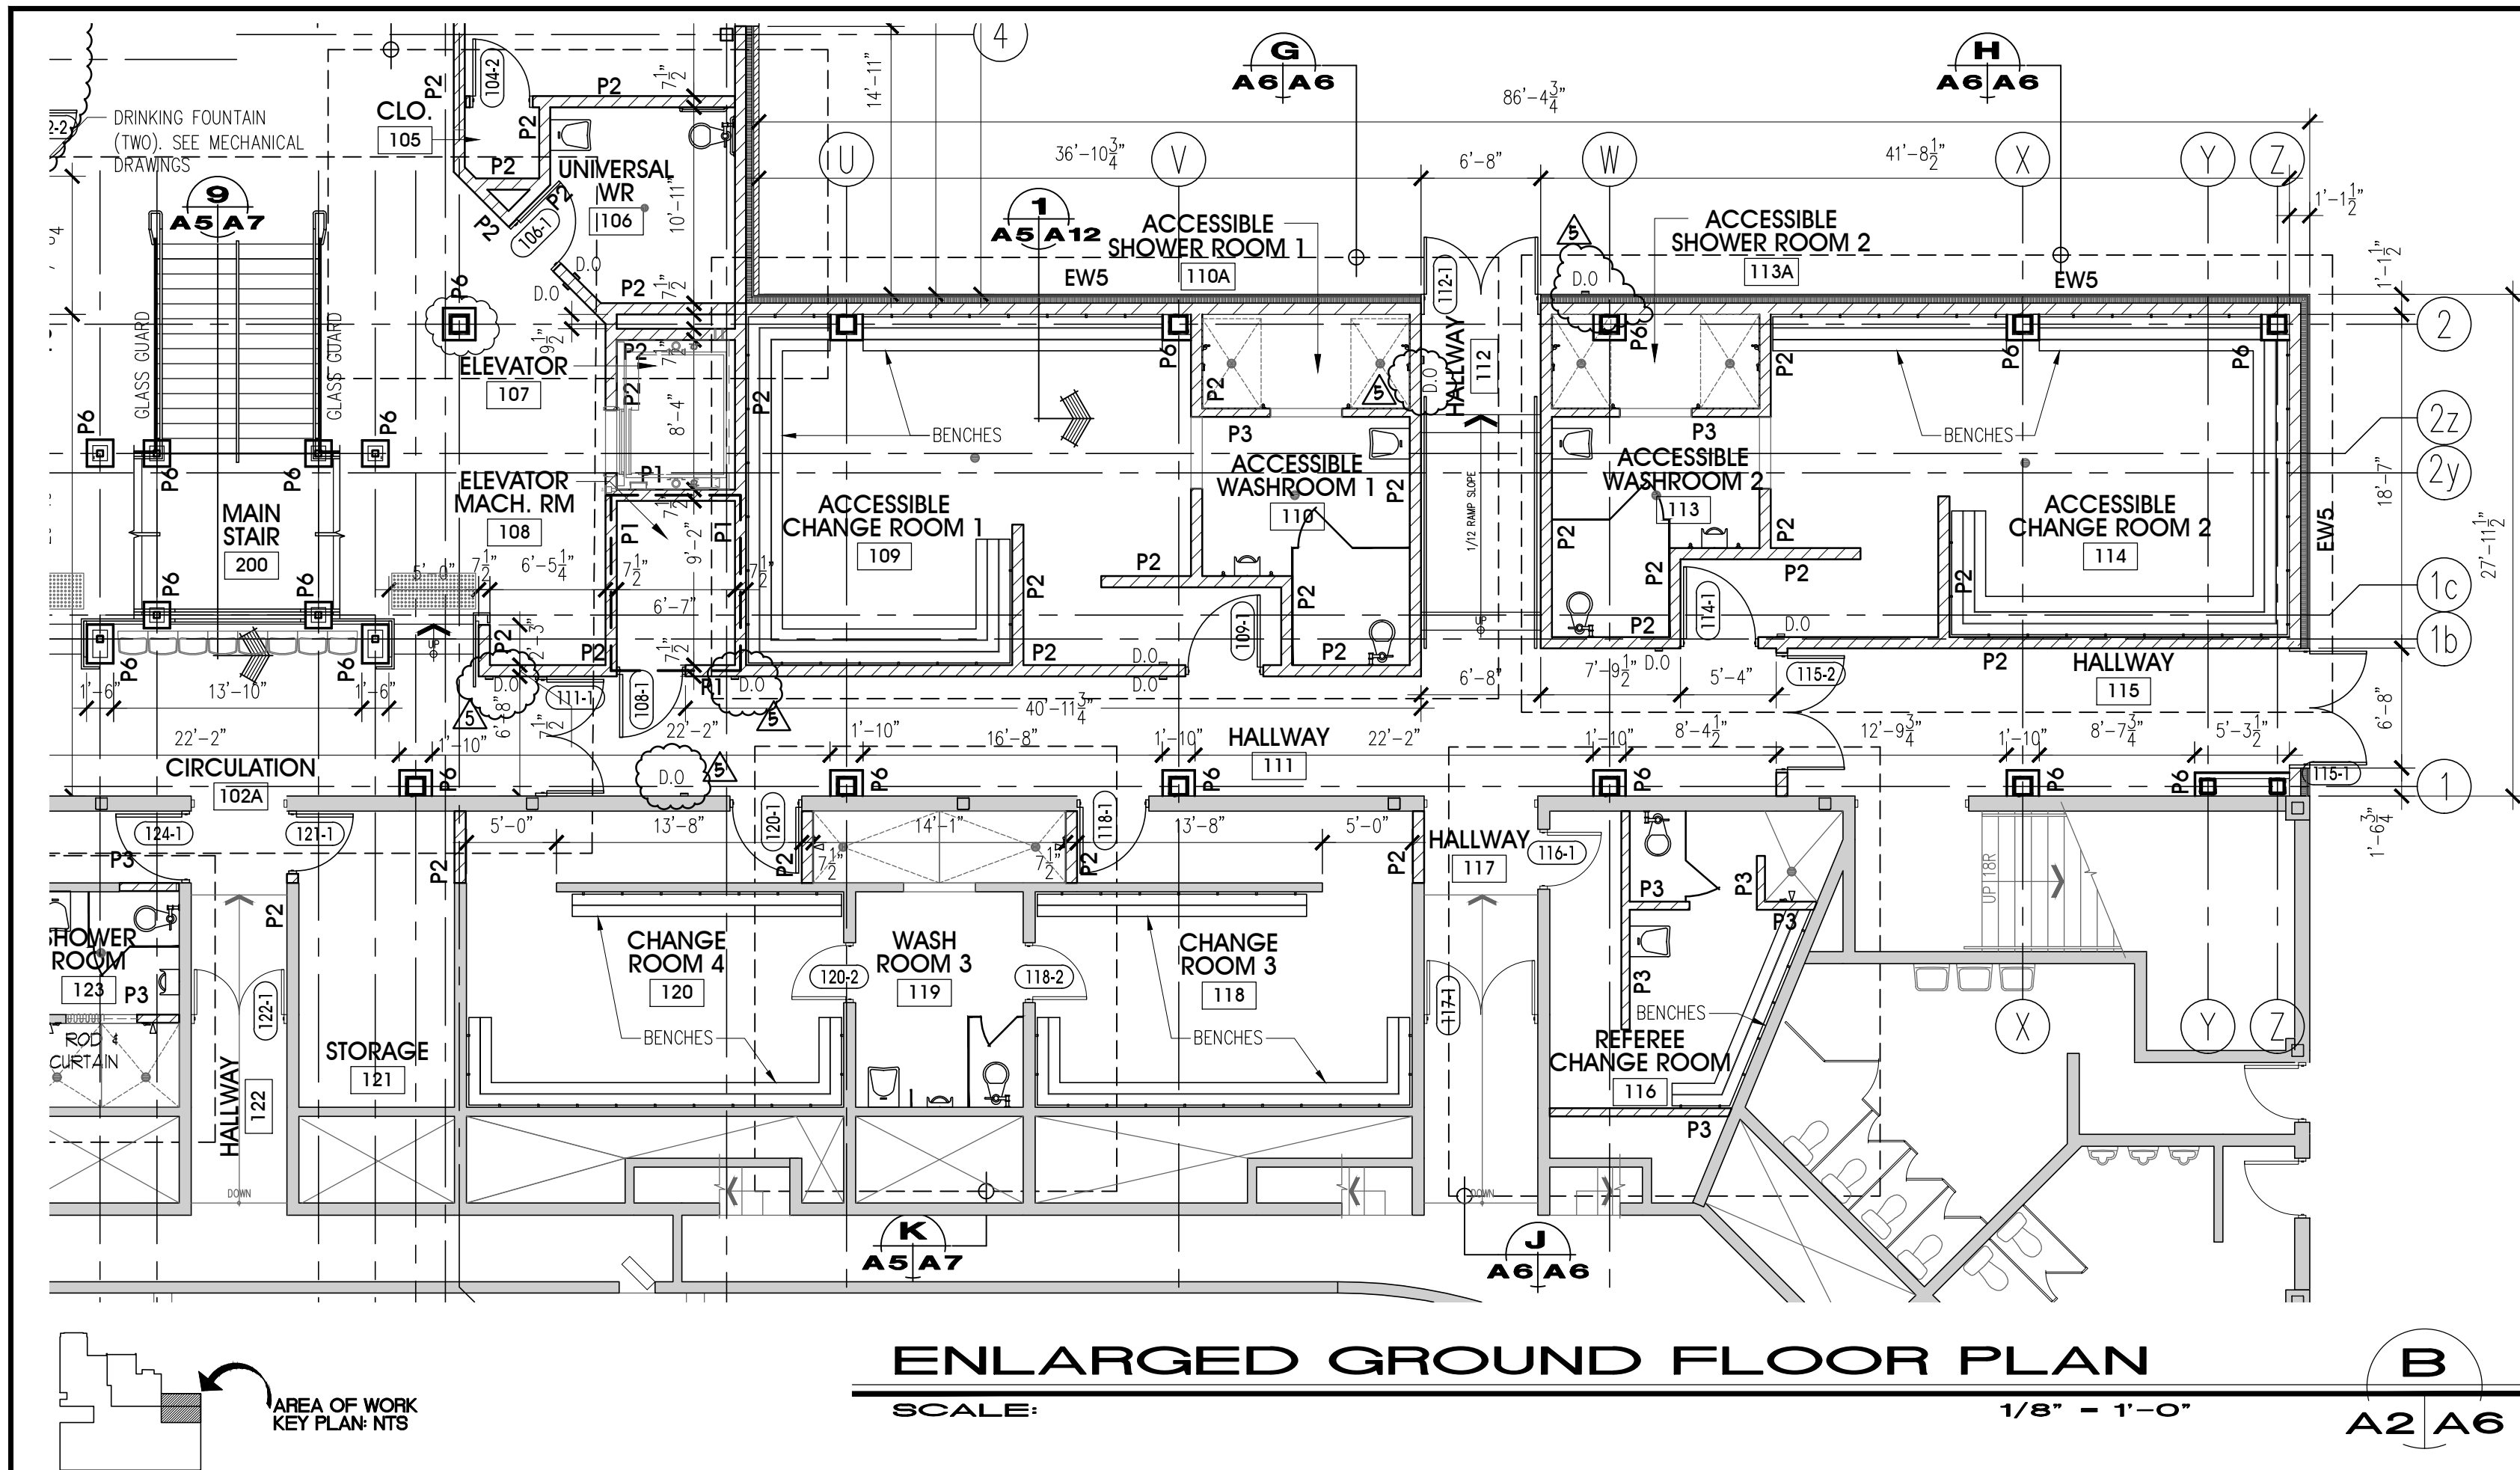

ISSUED FOR PERMIT	FEB. 01/22	
ADDENDA #6	JAN. 07/22	△
ADDENDA #5	DEC. 24/21	△
ISSUED FOR TENDER	DEC. 01/21	△
revisions	date	no.

CONTRACTORS MUST CHECK AND VERIFY ALL DIMENSIONS AND REPORT ANY DISCREPANCY TO THIS FIRM BEFORE PROCEEDING WITH THE WORK

A - detail no.
B - location sheet
C - detail sheet

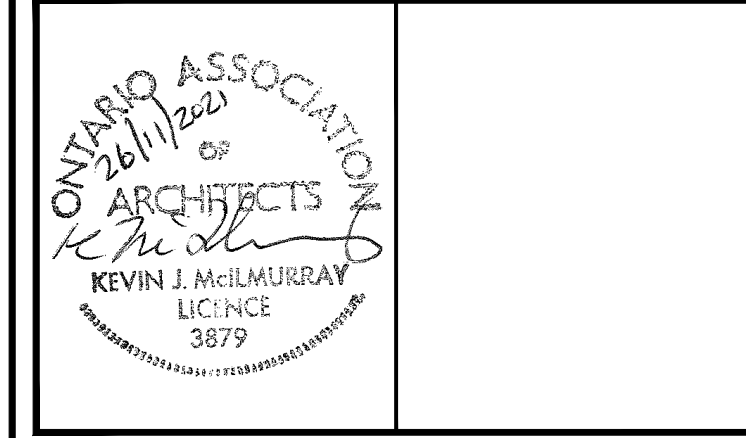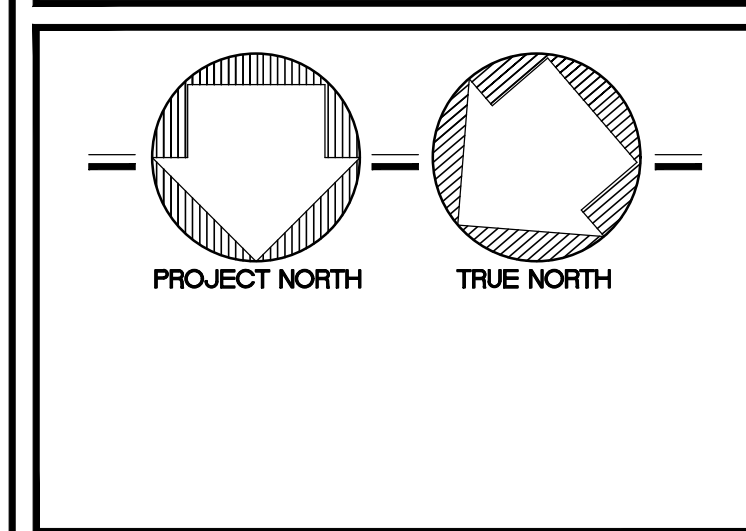

SPRIET ASSOCIATES

LIMITED architects
LONDON LTD. engineers



155 york street - london - N6A 1A8
phone : (519) 672-4100 fax : (519) 433-9351
e-mail : mail@spriet.on.ca

LUCAN BIDDULPH COMMUNITY MEMORIAL CENTRE PHASE 2 - LUCAN ARENA RENO'S & ARENA ADDITION
263 & 265 MAIN STREET, LUCAN, ONTARIO

drawing title :
ENLARGED FLOOR PLANS



date : NOV. 26, 2021
scale : AS NOTED
drawn by : RP
project no. : 216255-2

drawing no. :
A6

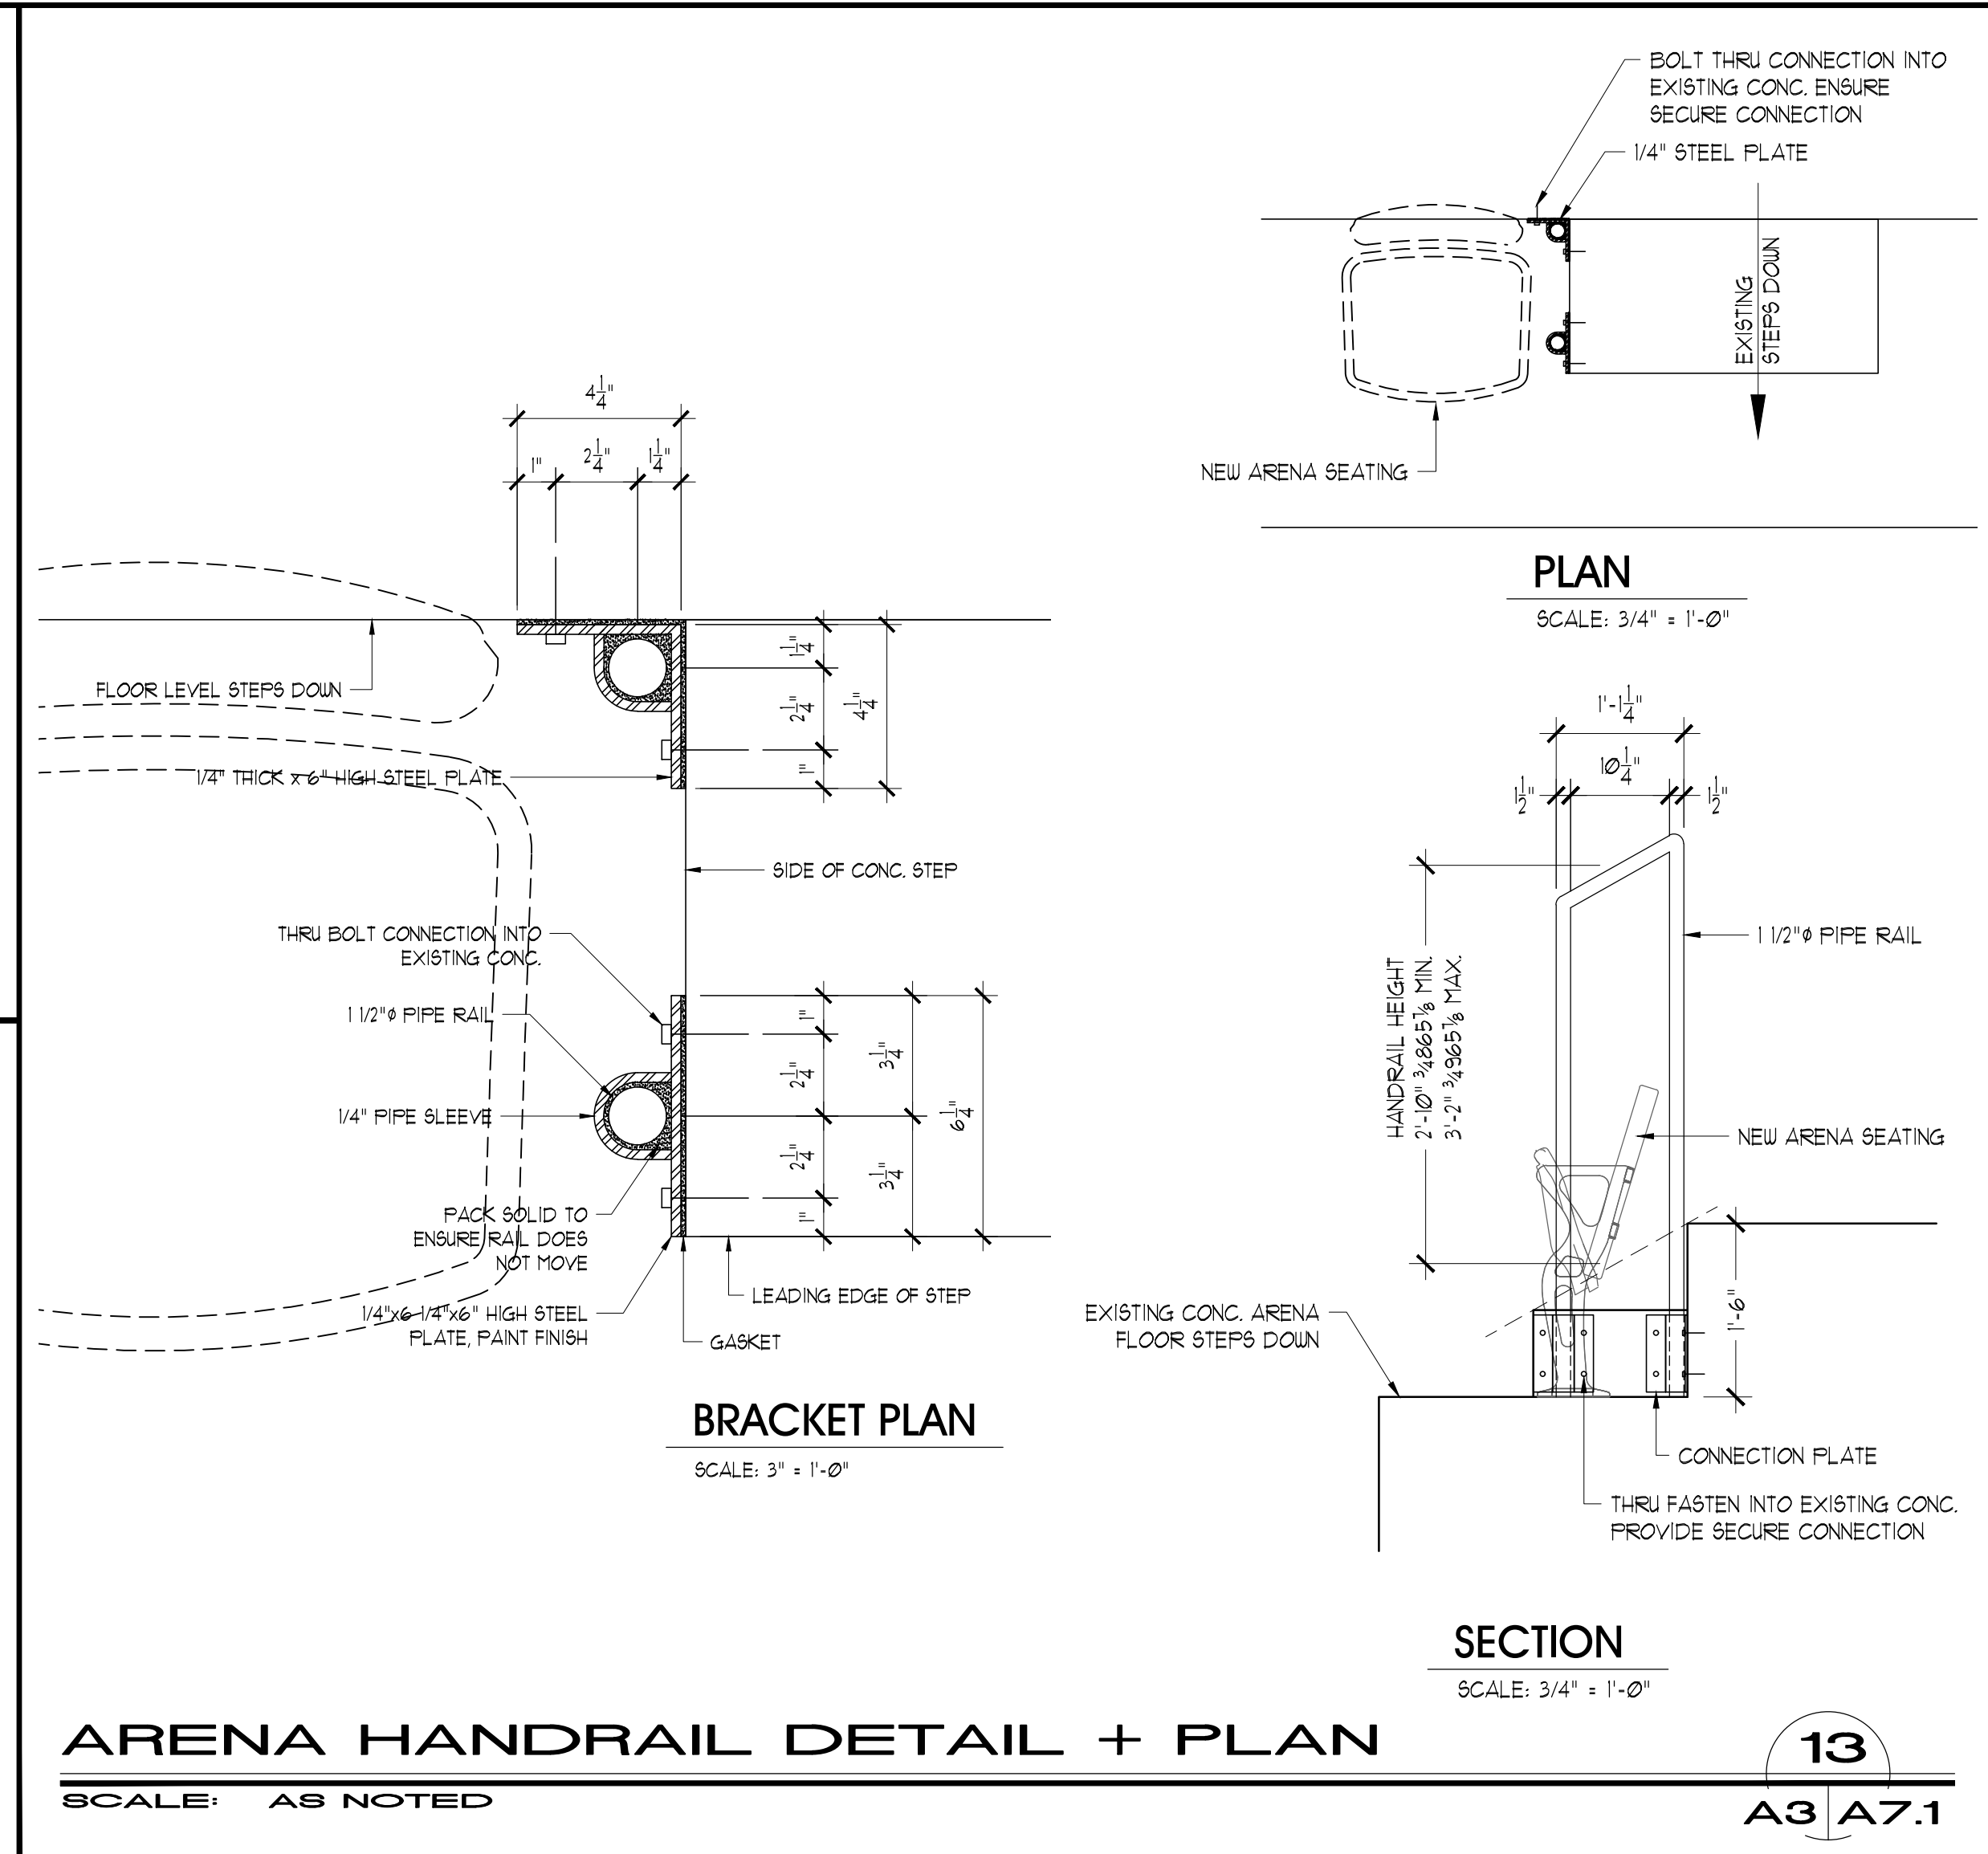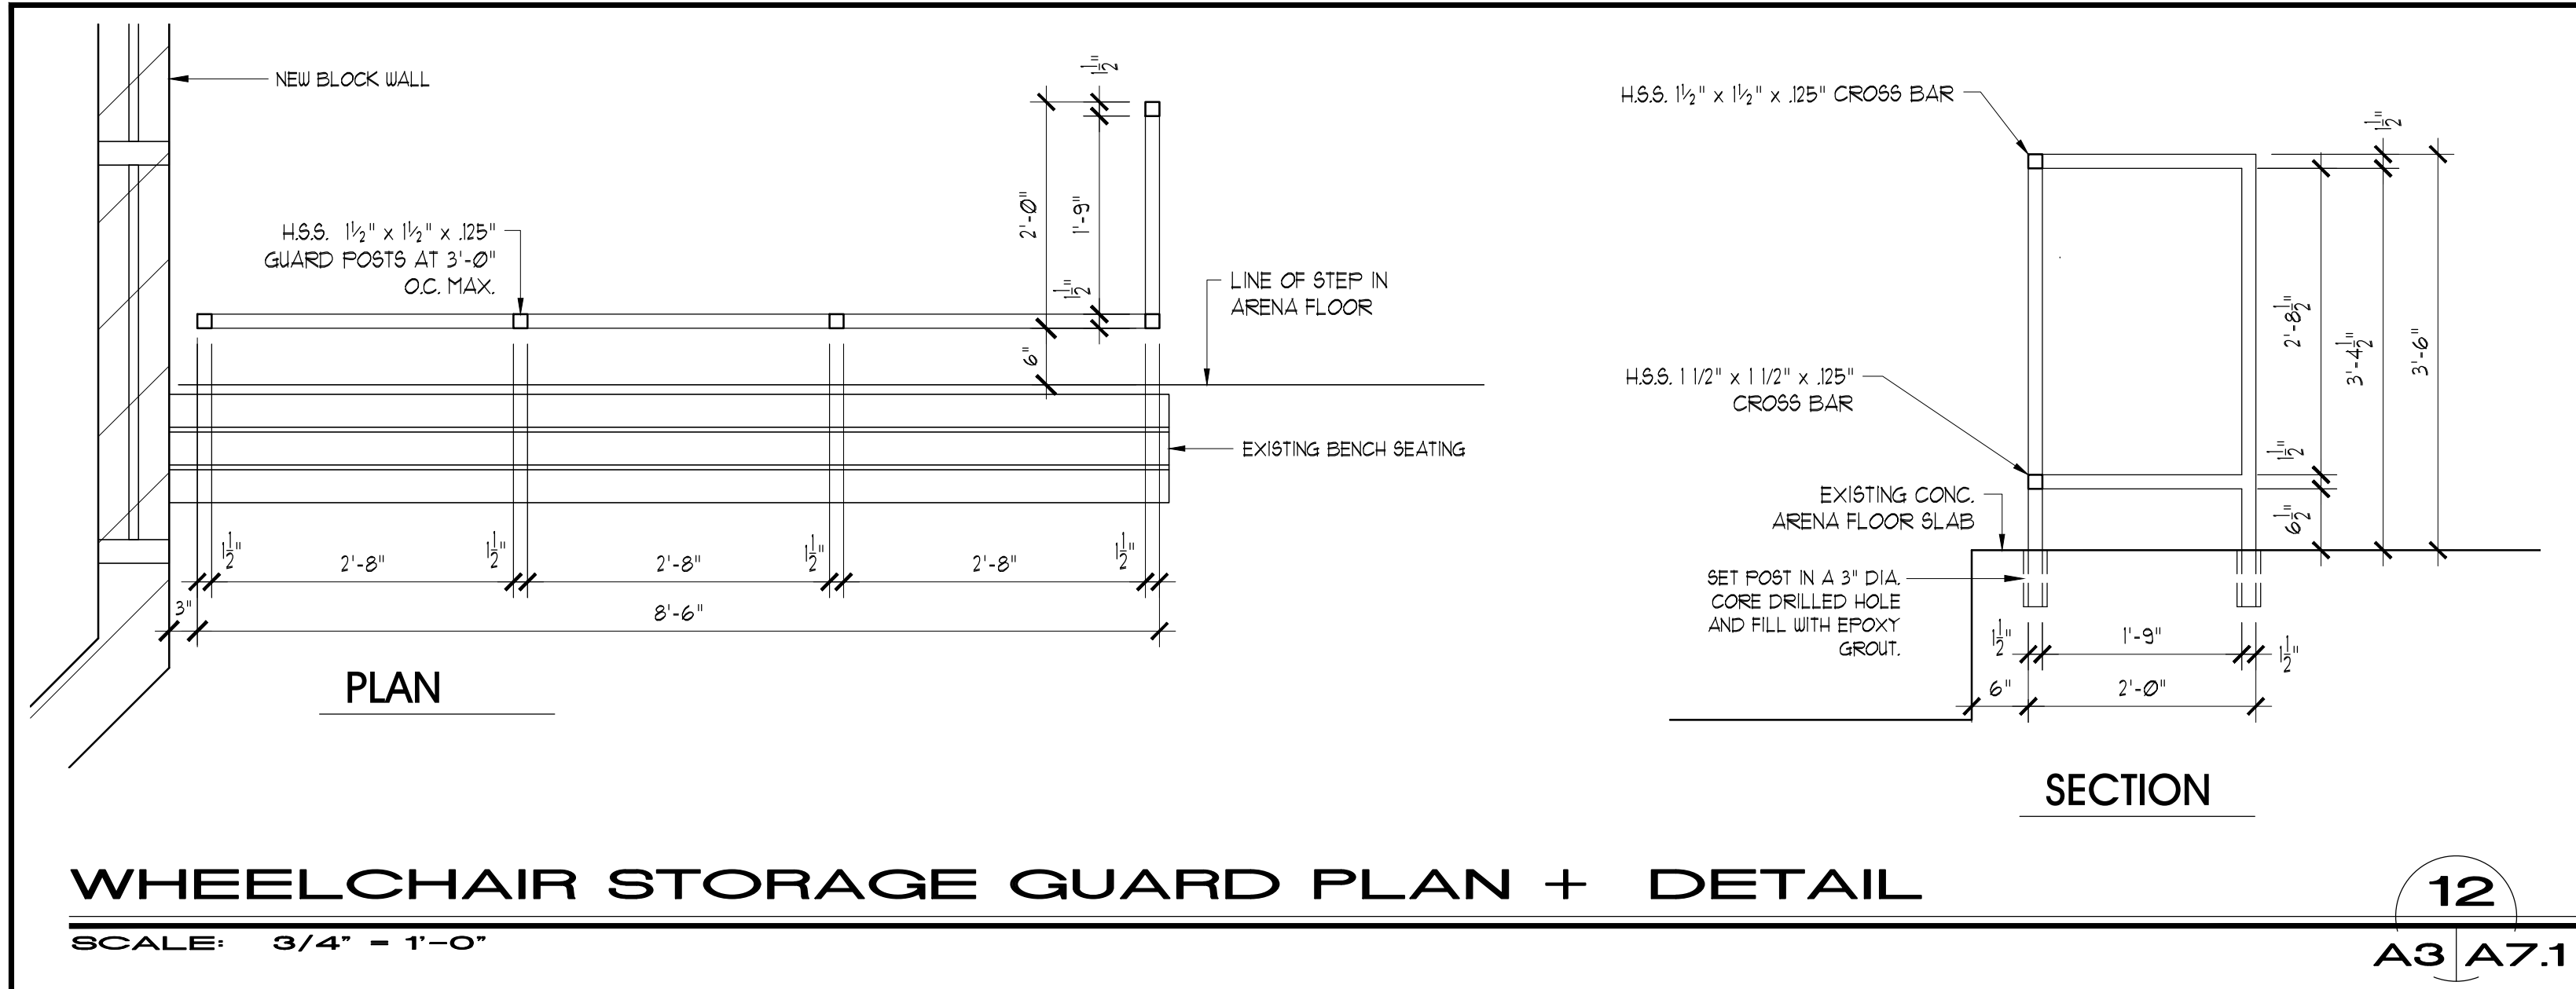


ISSUED FOR PERMIT	FEB. 01/22	
ADDENDA #8	JAN. 31/22	8
revisions	date	no.

CONTRACTORS MUST CHECK AND VERIFY ALL DIMENSIONS AND REPORT ANY DISCREPANCY TO THIS FIRM BEFORE PROCEEDING WITH THE WORK		
A - detail no.	A B C	
B - location sheet		
C - detail sheet		

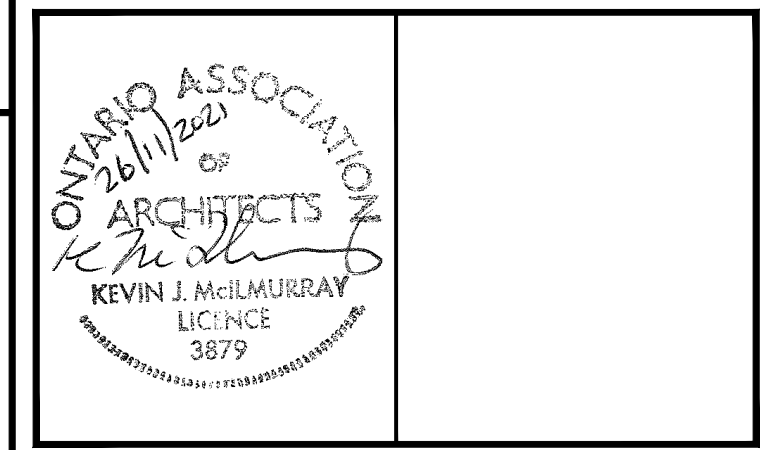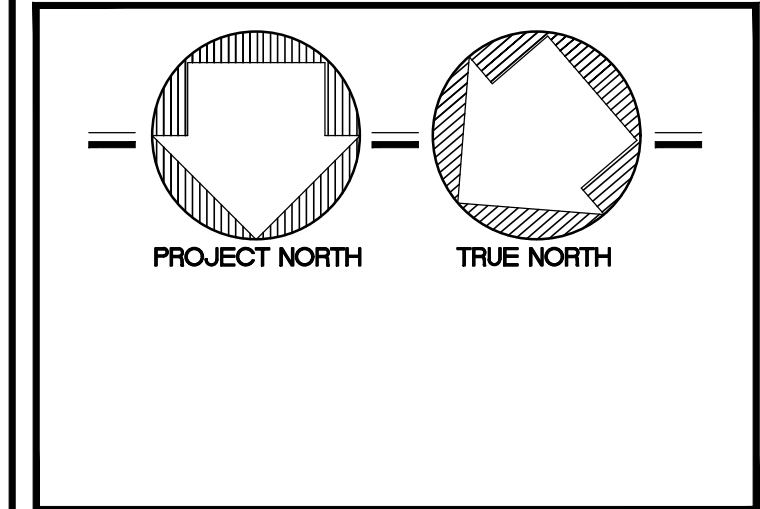

SPRIET ASSOCIATES

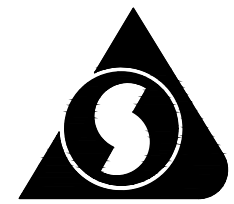

LIMITED architects

LONDON LTD. engineers

155 york street - london - N6A 1A8
phone : (519) 672-4100 fax : (519) 433-9351
e-mail : mail@spriet.on.ca

LUCAN BIDDULPH COMMUNITY MEMORIAL CENTRE

PHASE 2 - LUCAN ARENA RENO'S & ARENA ADDITION




263 & 265 MAIN STREET, LUCAN, ONTARIO

drawing title : DETAILS

date : NOV. 26, 2021	drawing no. :
scale : AS NOTED	
drawn by : MH	
project no. : 216255-2	

A7.1

drawing title :	
ENLARGED FLOOR PLANS	
date : NOV. 26, 2021	drawing no. : A7
scale : AS NOTED	
drawn by : RP	
project no. : 216255-2	

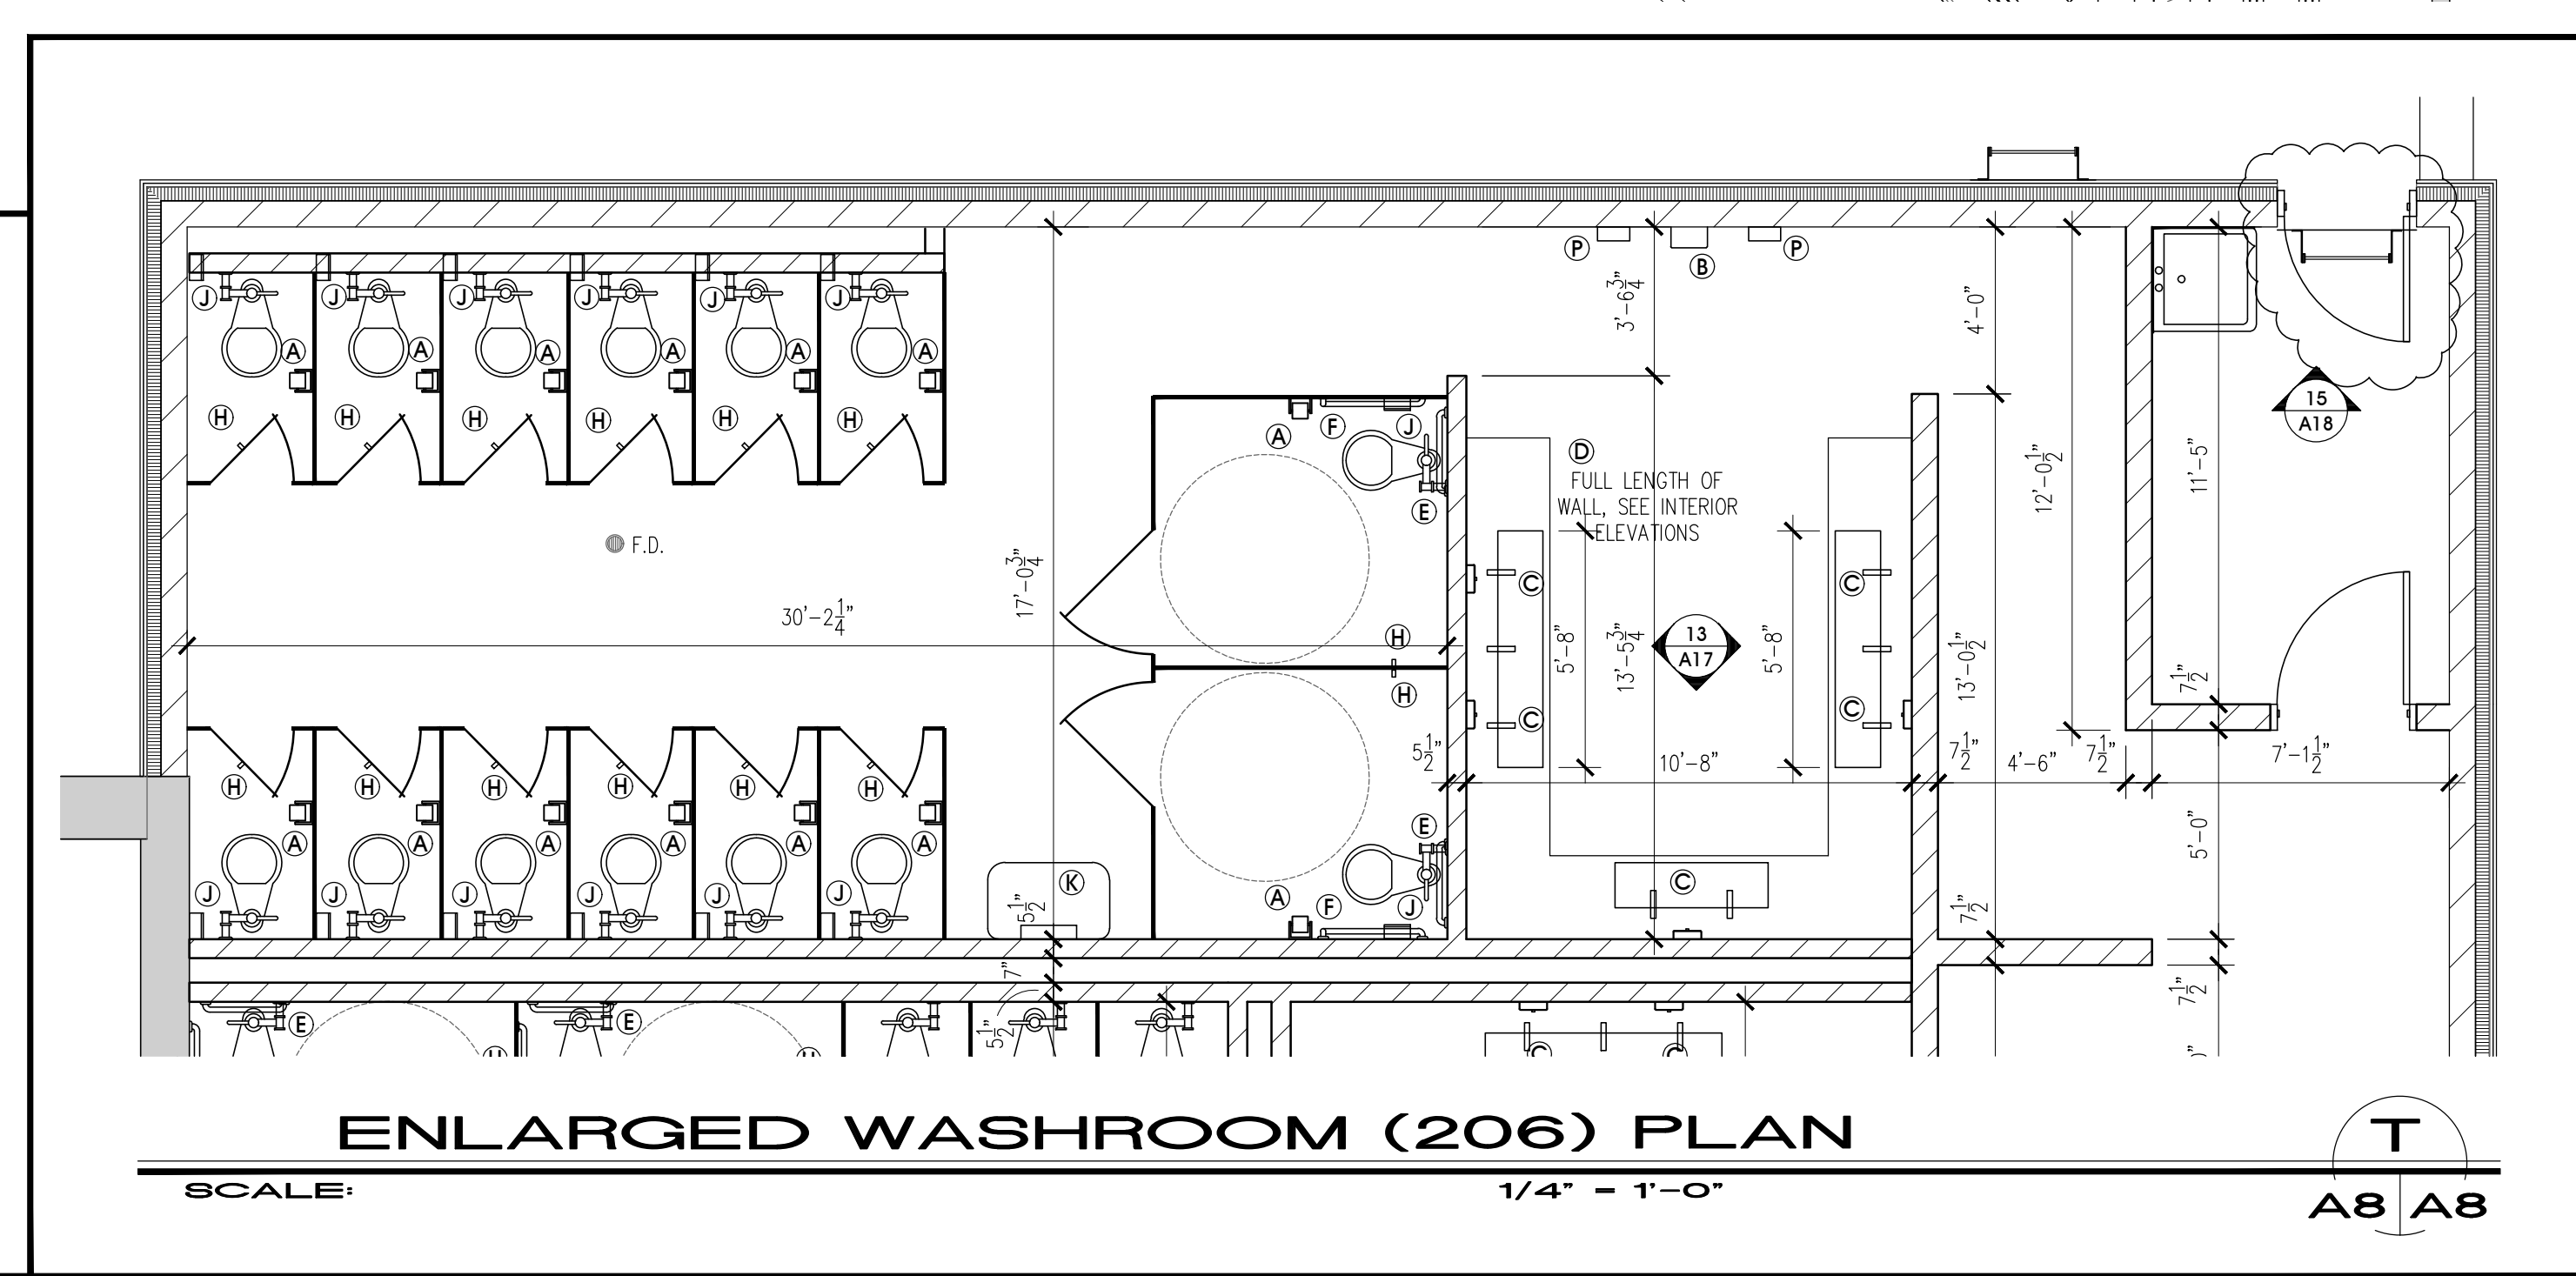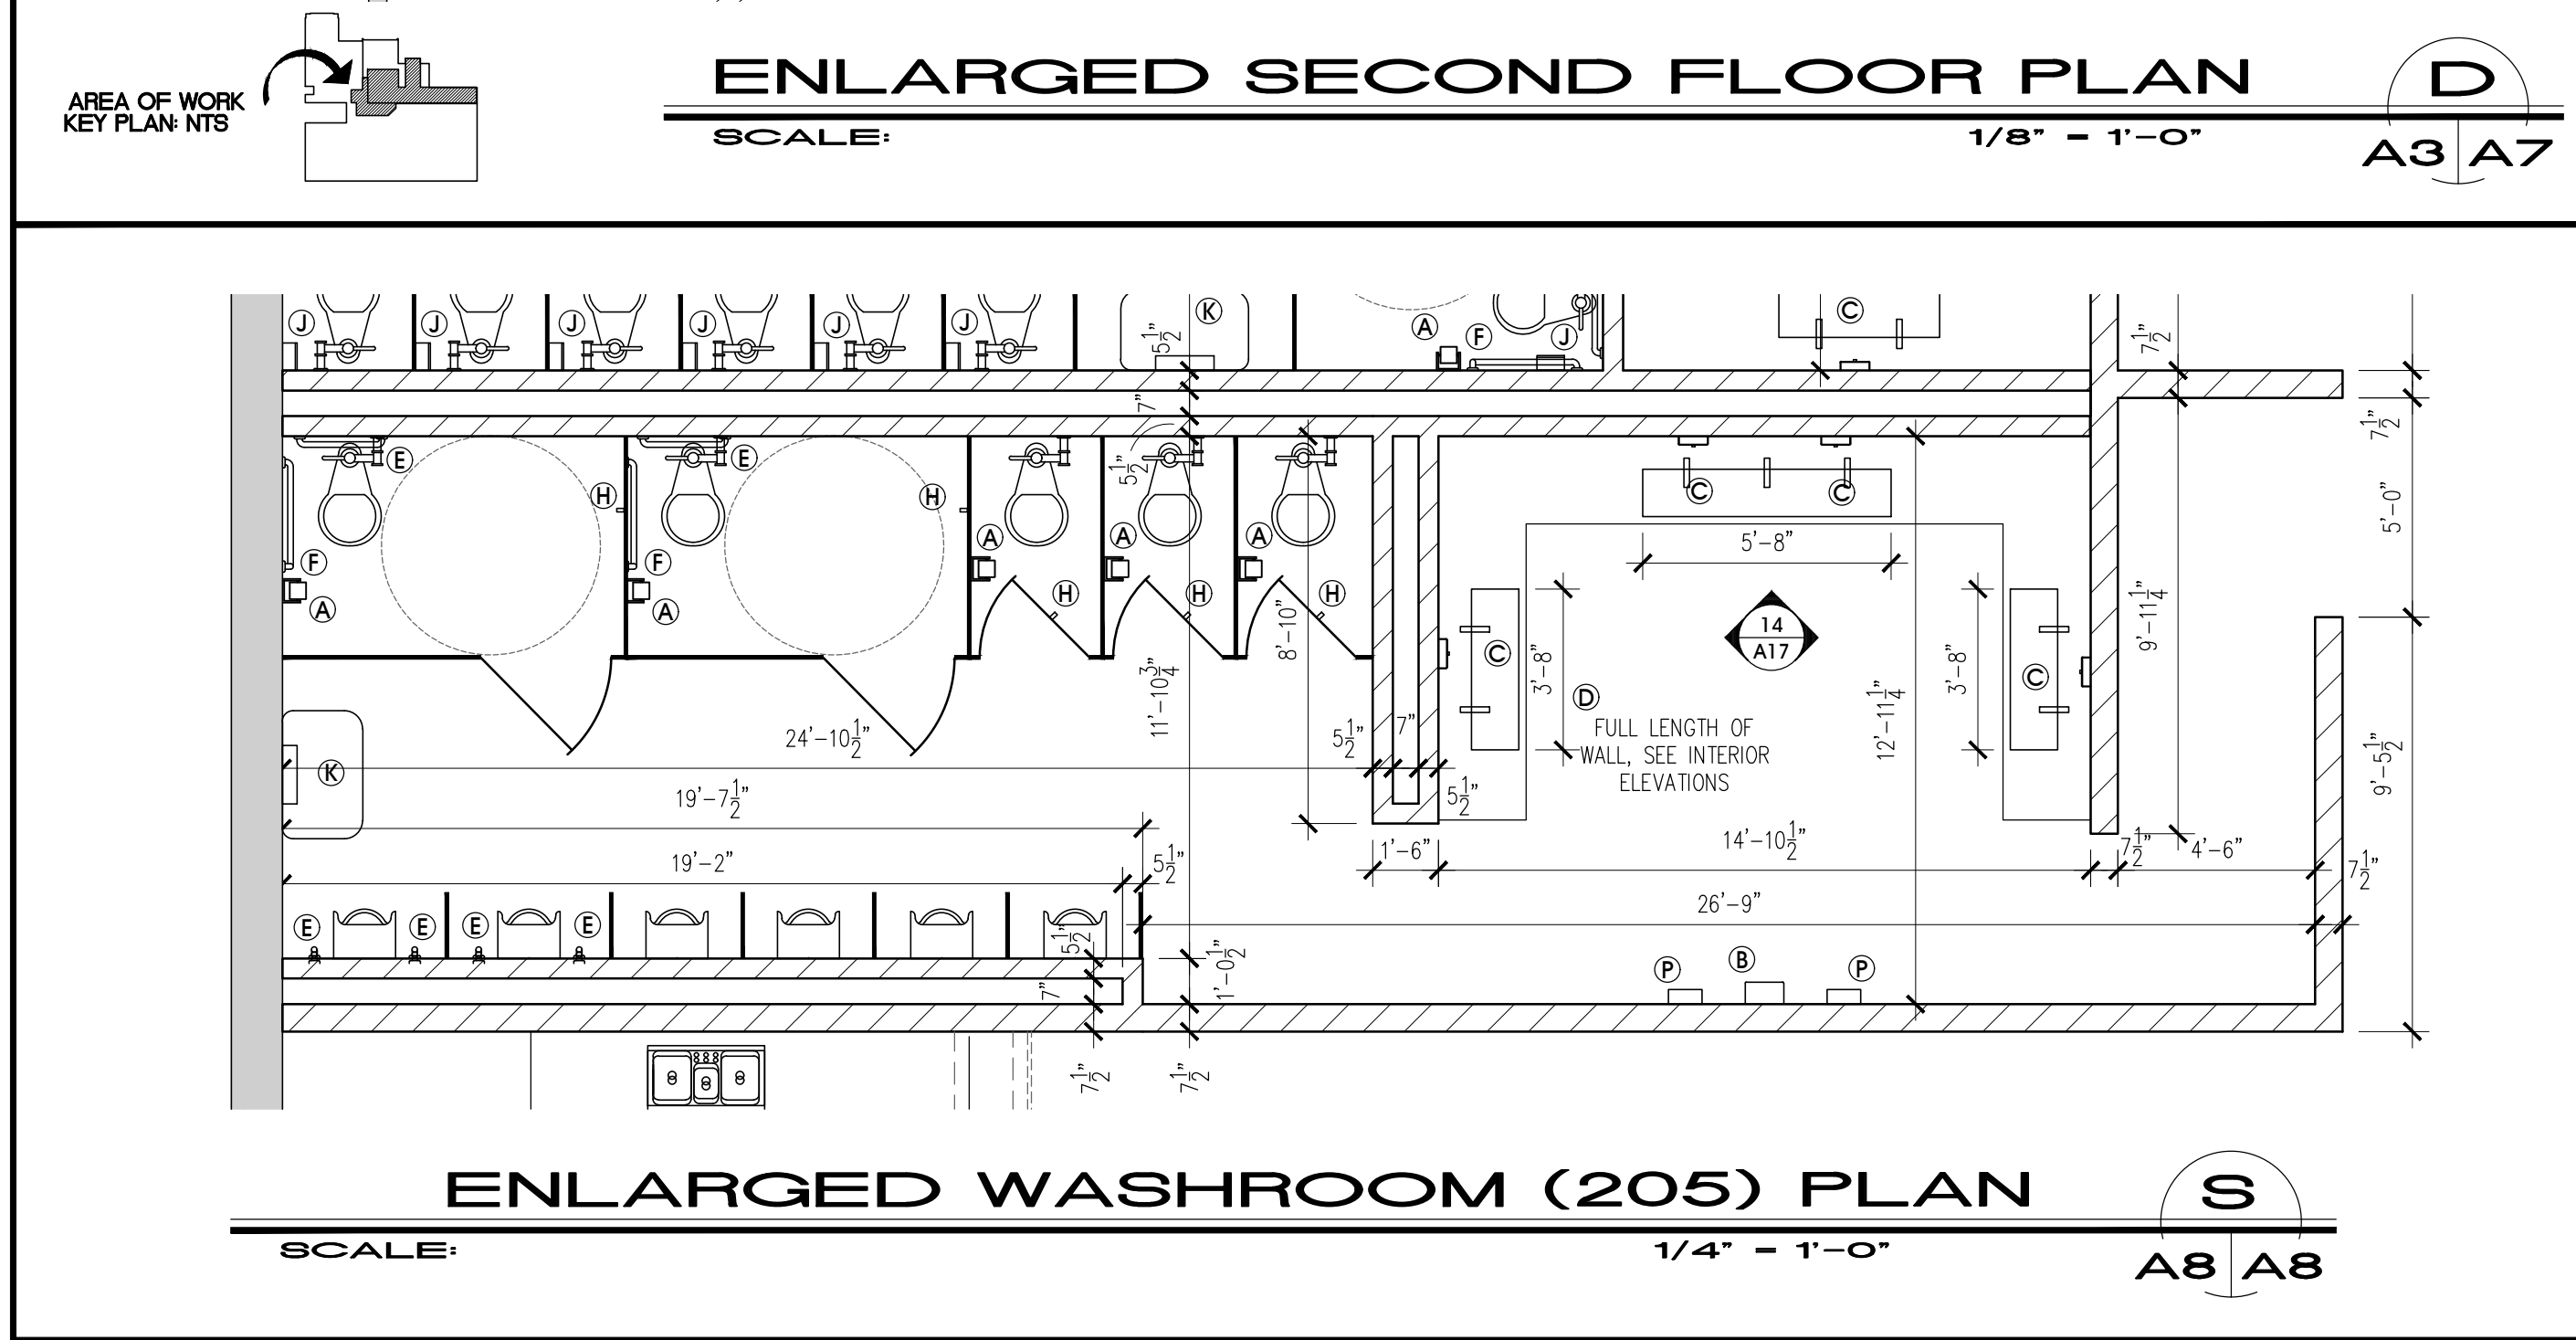
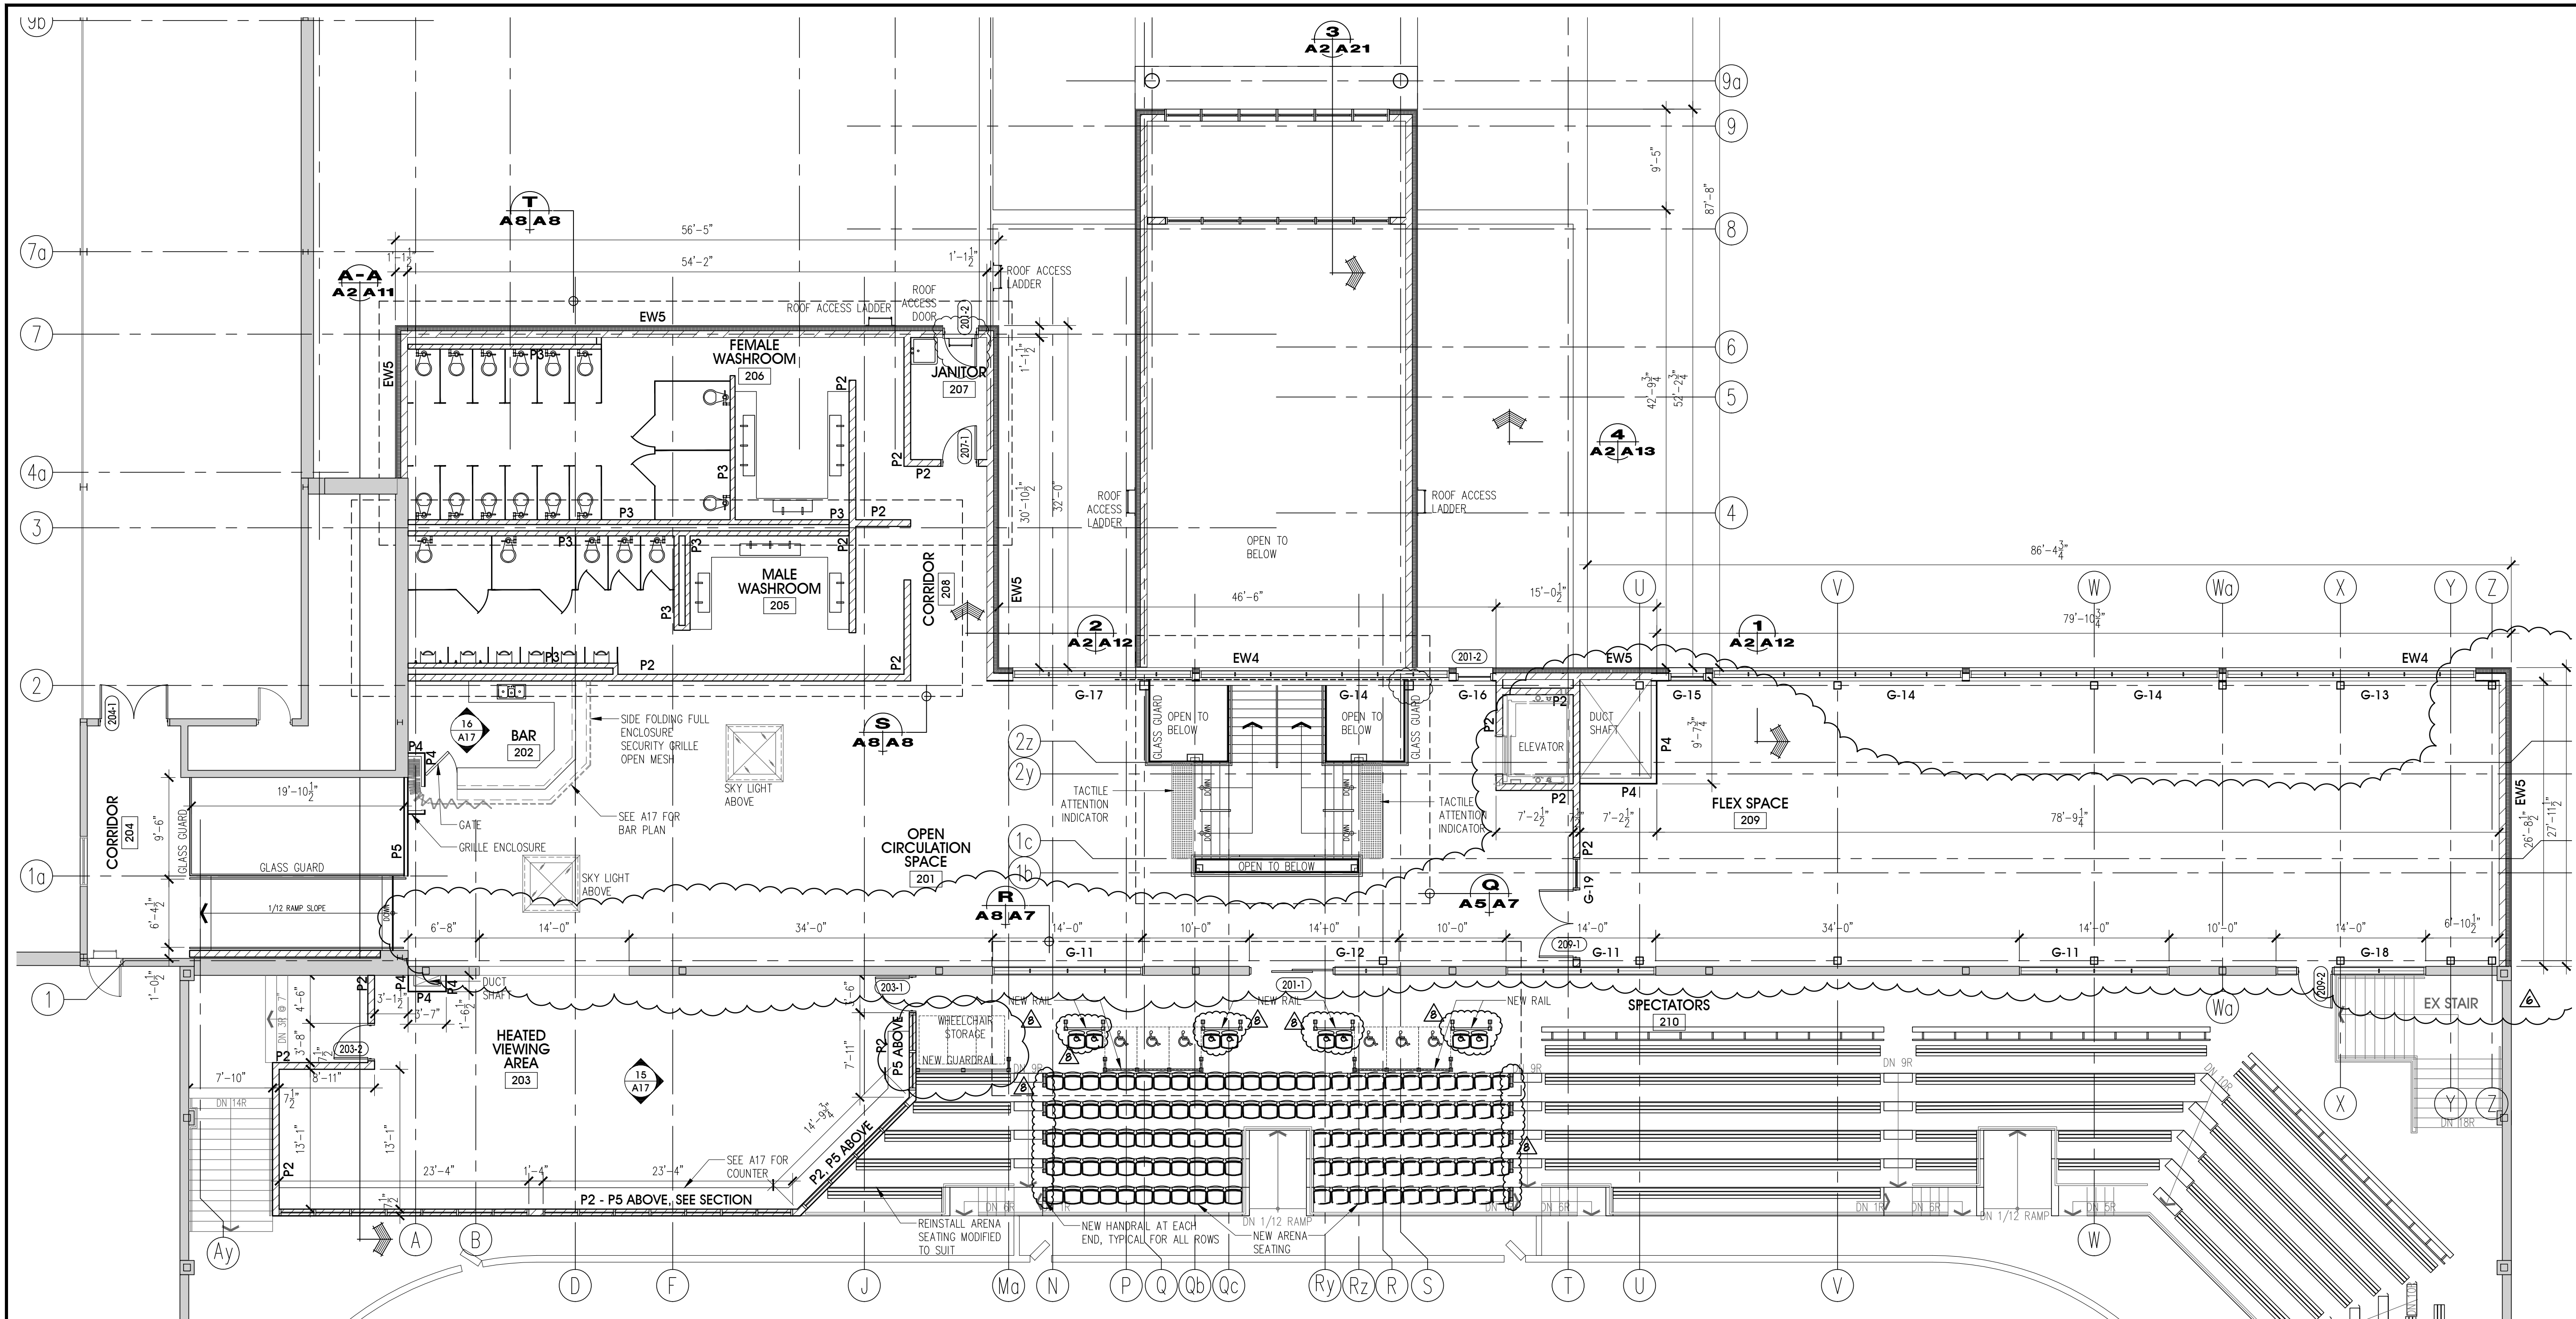


ISSUED FOR PERMIT	FEB. 01/22	
ADDENDA #8	JAN. 31/22	△
ADDENDA #6	JAN. 07/22	△
ADDENDA #2	DEC. 15/21	△
ISSUED FOR TENDER	DEC. 01/21	△
revisions	date	no.

CONTRACTORS MUST CHECK AND VERIFY ALL DIMENSIONS AND REPORT ANY DISCREPANCY TO THIS FIRM BEFORE PROCEEDING WITH THE WORK

A - detail no.
B - location sheet
C - detail sheet

A
B C

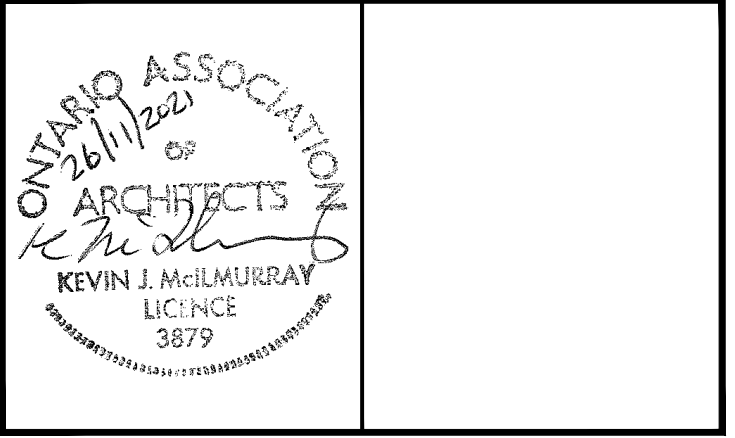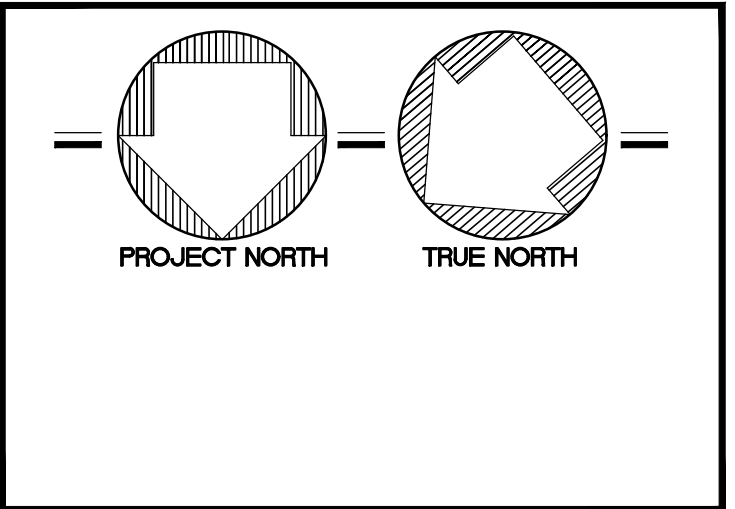

SPRIET ASSOCIATES

LIMITED architects LONDON LTD. engineers


155 york street - london - N6A 1A8
phone : (519) 672-4100 fax : (519) 433-9351
e-mail : mail@spriet.on.ca

LUCAN BIDDULPH COMMUNITY MEMORIAL CENTRE PHASE 2 - LUCAN ARENA RENO'S & ARENA ADDITION
263 & 265 MAIN STREET, LUCAN, ONTARIO


drawing title :
ENLARGED FLOOR PLANS

date : NOV. 26, 2021
scale : AS NOTED
drawn by : RP
project no. : 216255-2

drawing no. :
A8

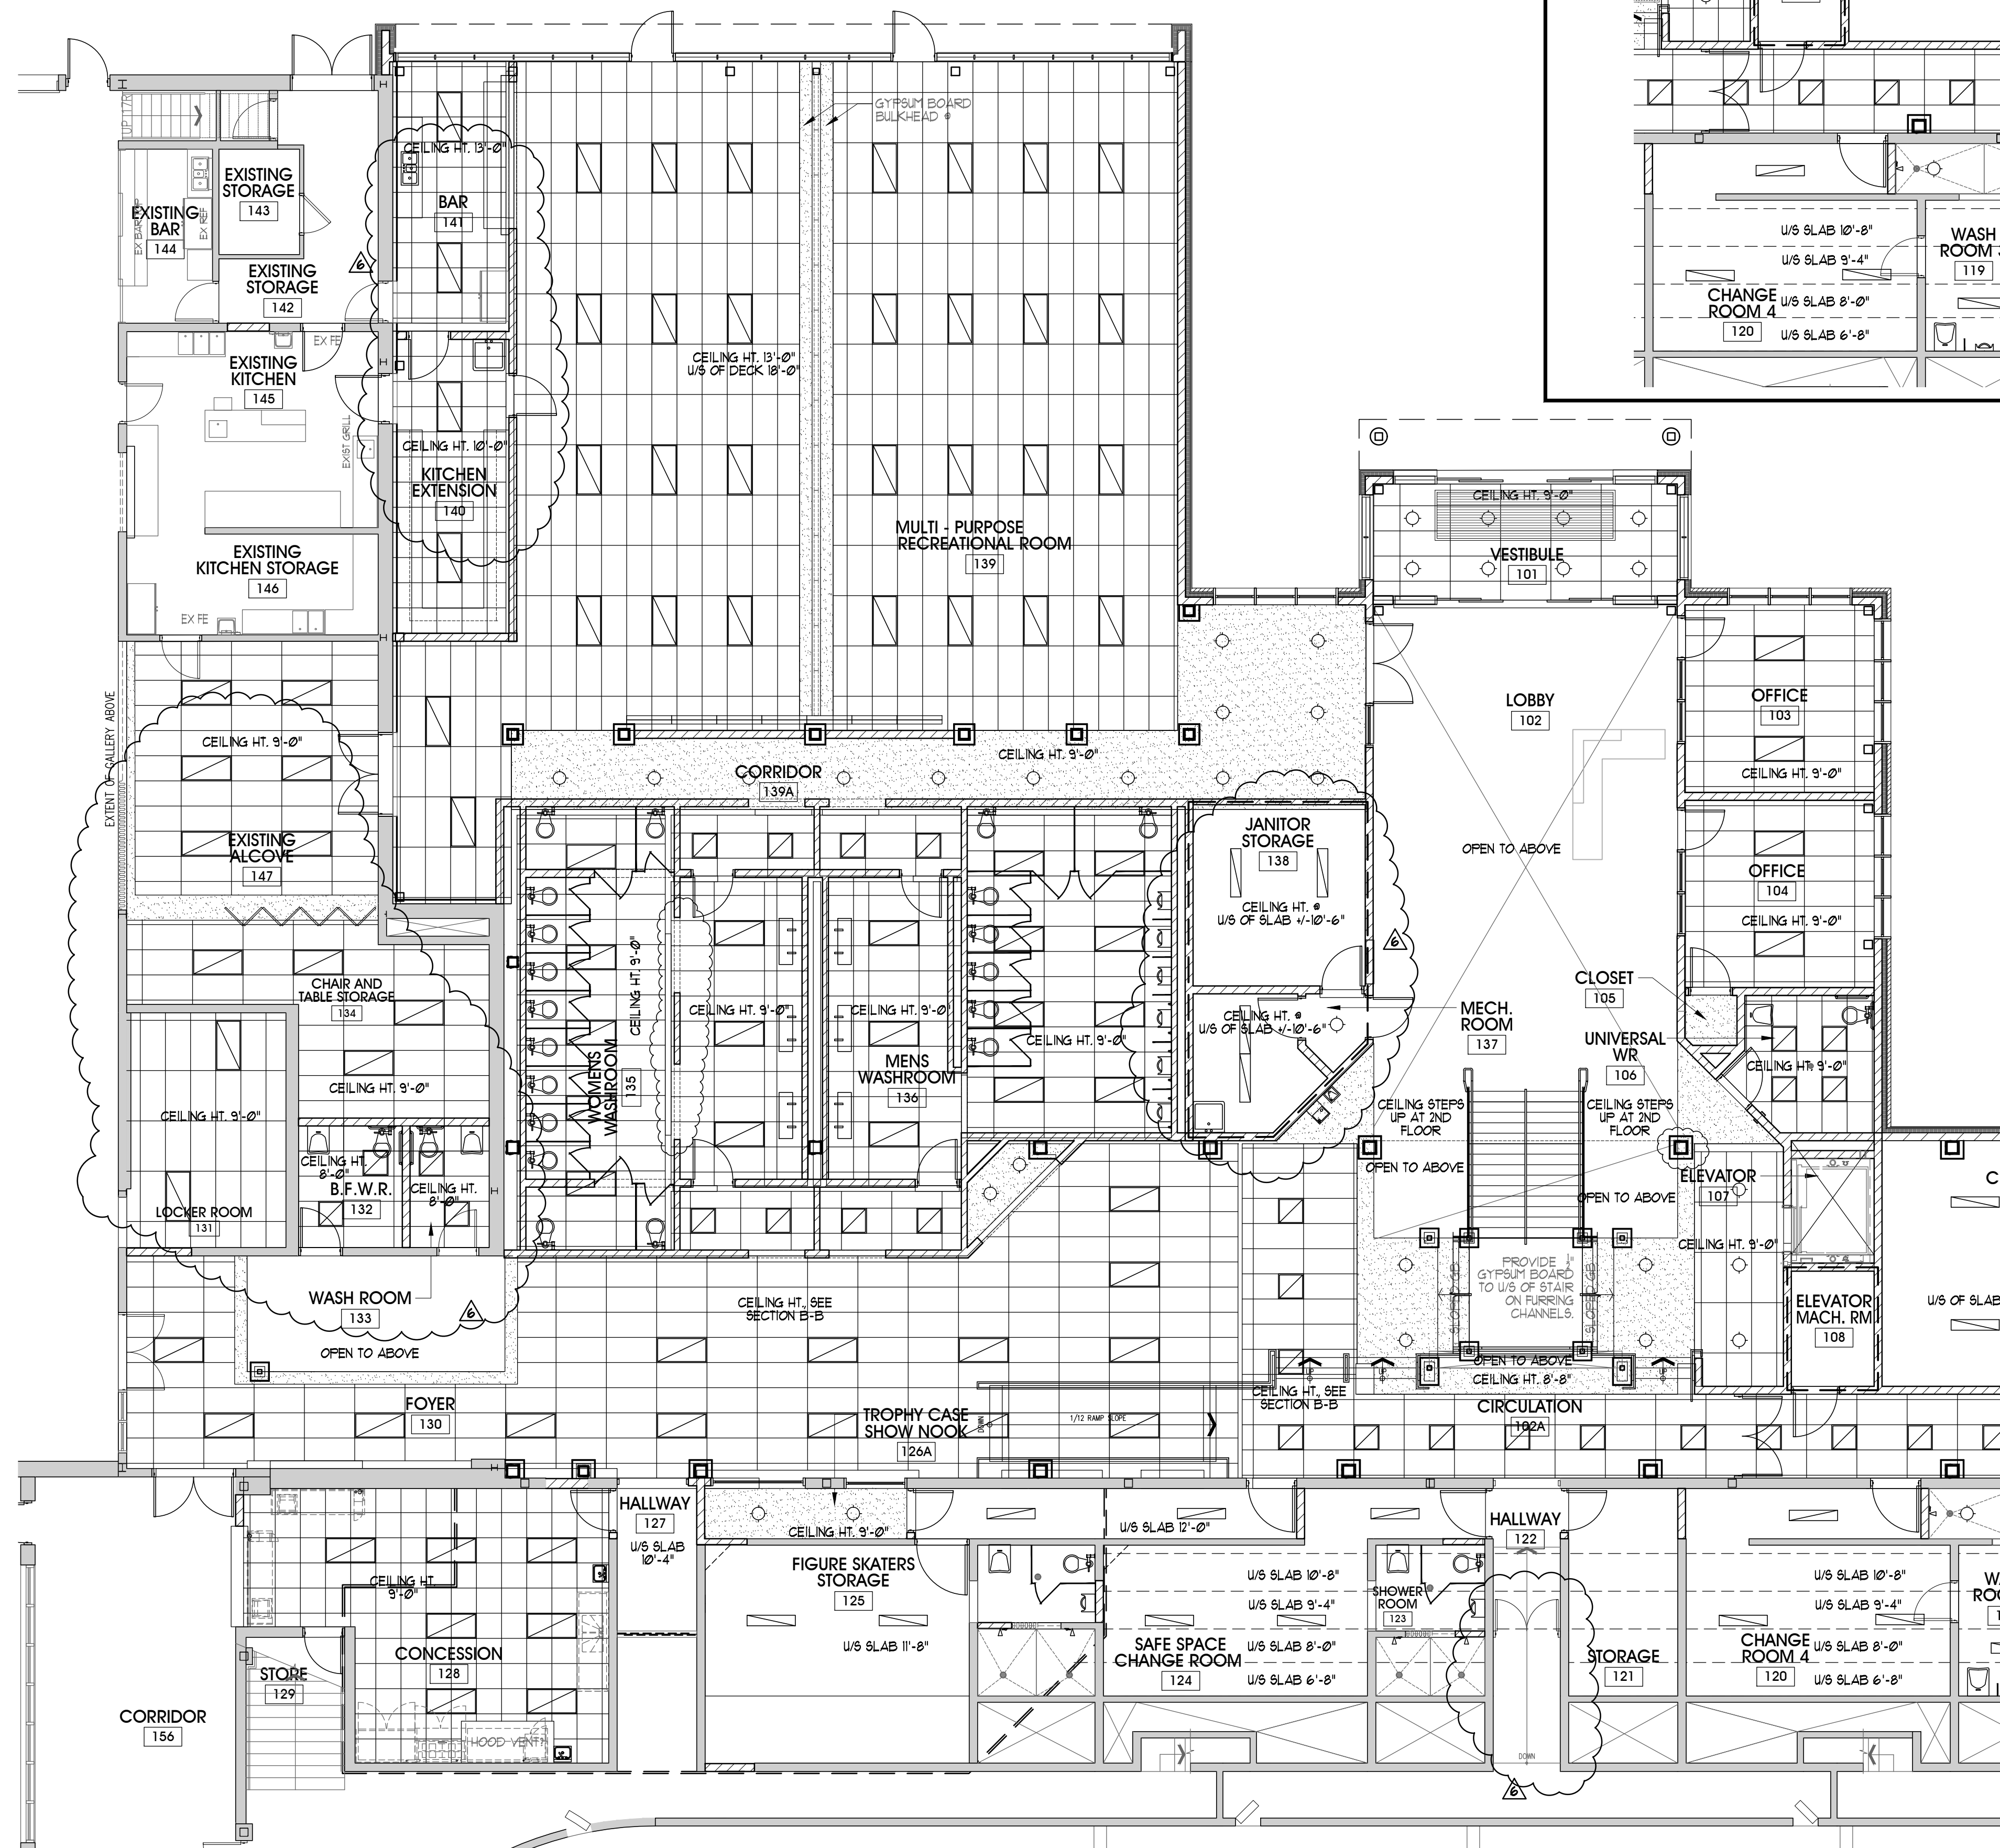

GROUND FLOOR RCP
SCALE: 1/8" = 1'-0"

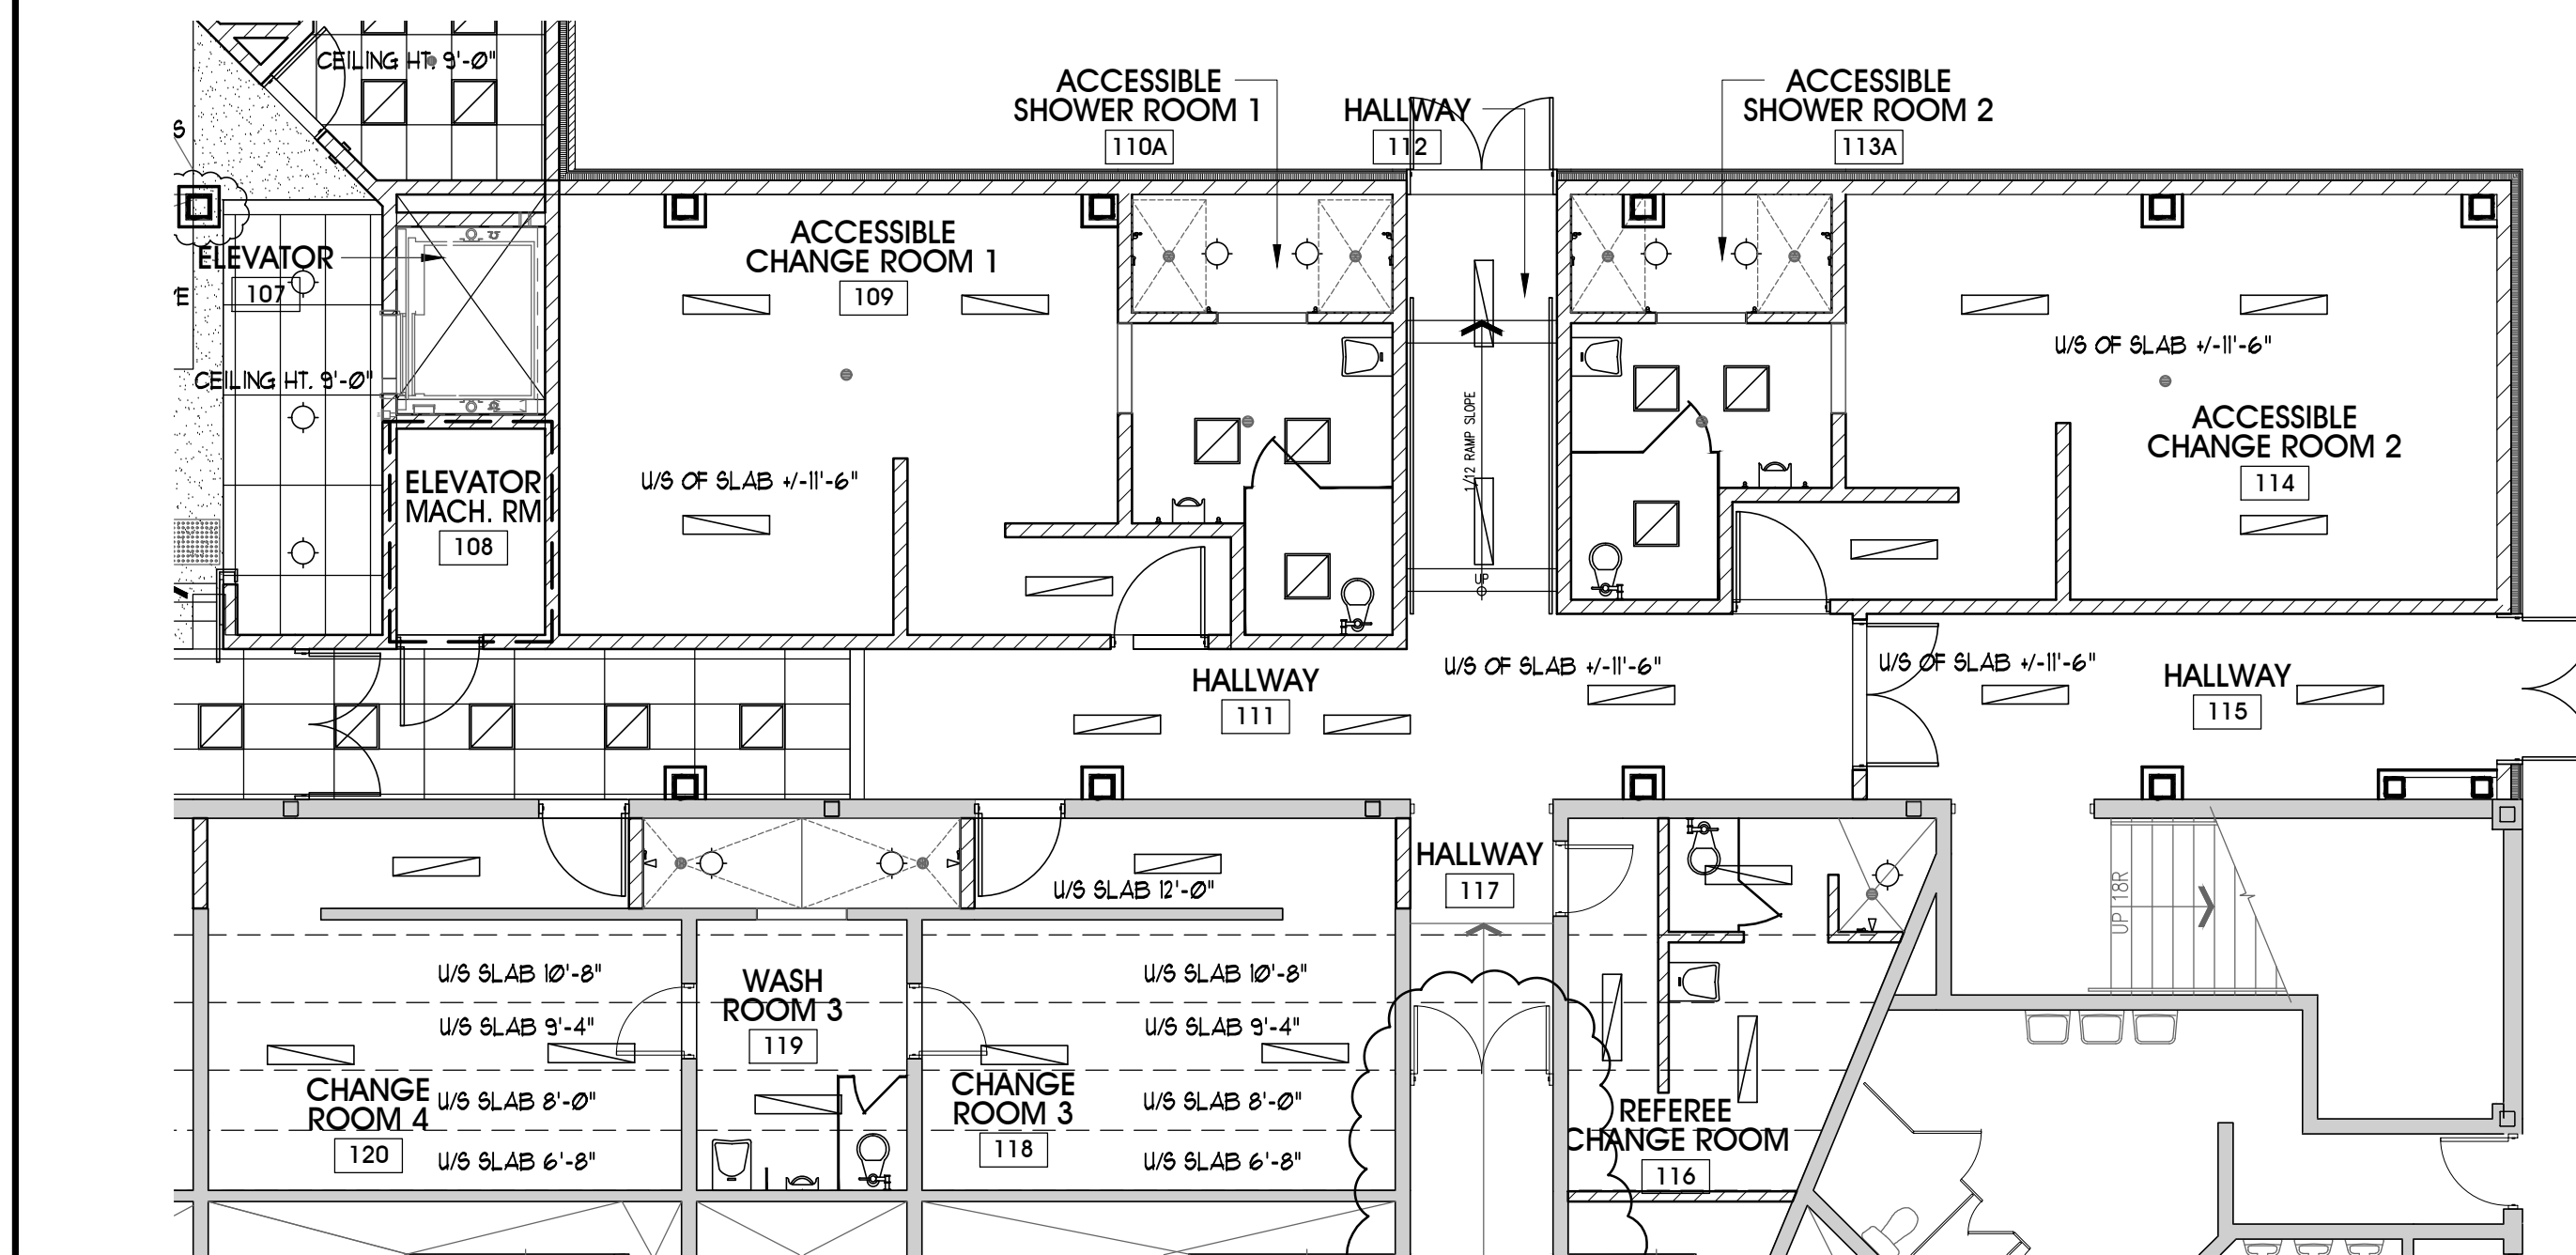

GROUND FLOOR RCP
SCALE: 1/8" = 1'-0"

REFLECTED CEILING PLAN LEGEND:

ROOM NAME 101	TAG DENOTES ROOM NAME		24"x24" ACOUSTIC CEILING TILE REFER ALSO TO ROOM FINISH SCHEDULE.
	DENOTES WALL		24"x48" ACOUSTIC CEILING TILE REFER ALSO TO ROOM FINISH SCHEDULE.
	DENOTES OPENING IN WALL		GYPSUM BOARD CEILING. MAKE GOOD TO RECEIVE NEW PAINT FINISH. SEE SCHED.
	ELECTRICAL FIXTURES, REFER TO ELECTRICAL DRAWINGS		EXPOSED METAL DECK PAINT
	MECHANICAL FIXTURES, REFER TO MECHANICAL DRAWINGS		EMERGENCY LIGHTING OR EXIT SIGNAGE. REFER TO ELECT, DUGS FOR MORE INFO




REFLECTED CEILING PLAN NOTES:

- SEE WALL SECTIONS, WALL TYPE LEGEND, ELECTRICAL AND MECHANICAL DRAWINGS FOR MORE INFORMATION
- LOCATE/COORDINATE STRUCTURAL BRIDGING AS REQUIRED TO CLEAR LIGHT FIXTURES, OIL DOOR TRACKS, RADIANT HEATER, ETC. COORDINATE WITH STRUCTURAL DRAWINGS.
- U.N.O. UNDERSIDE OF ALL LIGHT FIXTURES IN ALL OPEN AREAS SHALL BE MOUNTED IN LINE WITH THE UNDERSIDE OF THE O.W.B.J. BOTTOM CHORD. REFER TO ELECTRICAL DRAWINGS FOR ADDITIONAL INFORMATION.
- ALL CONDUIT AND PIPING SHALL BE INSTALLED AGAINST UNDERSIDE OF ROOF DECK IN ALL OPEN AREAS. DUCTWORK, ETC. SHALL BE INSTALLED ABOVE BOTTOM CHORD OF JOIST, NO EXCEPTIONS.
- ALL CONDUIT AND PIPE RUNS SHALL BE RUN IN A STRAIGHT AND CONSISTENT CLEAN MANNER FROM DEVICES BACK TO WALL AND STUB-INS.
- EMERGENCY EXIT SIGNAGE TO BE LOCATED AND INSTALLED AS PER FIRE MARSHAL REQUIREMENTS, COORDINATE WITH ELECTRICAL DRAWINGS PRIOR TO INSTALLATION. WALL MOUNT AT EXIT DOORS.
- REFER TO MECHANICAL AND ELECTRICAL DRAWINGS FOR COORDINATION OF INSTALLATION OF DIFFUSERS, LIGHT FIXTURES, EXHAUST FANS, RECEPTACLES ETC. IN CEILING.
- PROVIDE 24" WIDE ACOUSTIC INSULATION AROUND PERIMETER ABOVE CEILING AS NOTED IN ROOM SCHEDULE.

ISSUED FOR PERMIT	FEB. 01/22	
ADDENDA #6	JAN. 07/22	6
ADDENDA #2	DEC. 15/21	2
ISSUED FOR TENDER	DEC. 01/21	1
revisions	date	no.

CONTRACTORS MUST CHECK AND VERIFY ALL DIMENSIONS AND REPORT ANY DISCREPANCY TO THIS FIRM BEFORE PROCEEDING WITH THE WORK

A - detail no.
B - location sheet
C - detail sheet

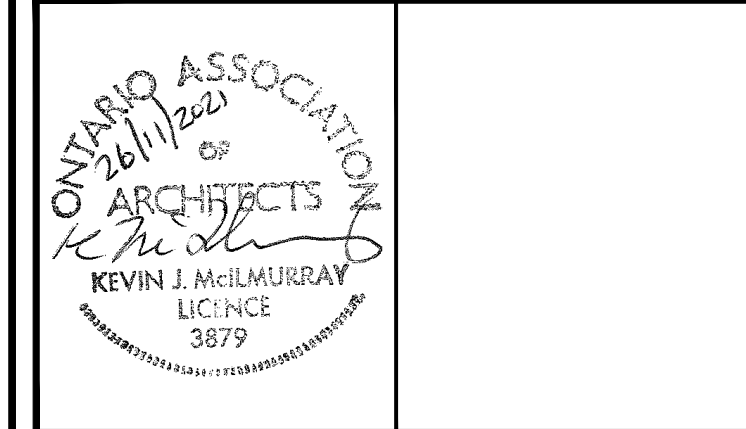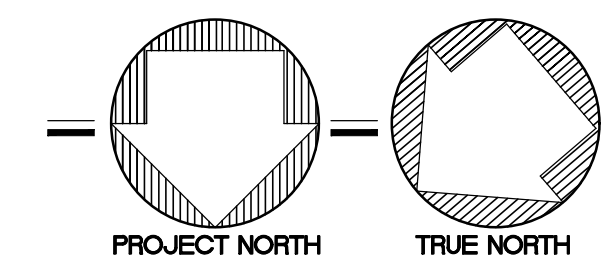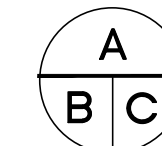


SPRIET ASSOCIATES

LIMITED architects
LONDON LTD. engineers


155 york street - london - N6A 1A8
phone : (519) 672-4100 fax : (519) 433-9351
e-mail : mail@spriet.on.ca

LUCAN BIDDULPH COMMUNITY MEMORIAL CENTRE
PHASE 2 - LUCAN ARENA
RENO'S & ARENA ADDITION
263 & 265 MAIN STREET, LUCAN, ONTARIO

drawing title :	GROUND FLOOR RCP	drawing no. :	A9
date :	NOV 26, 2021	project no. :	216255-2
scale :	AS NOTED		
drawn by :	MDO		

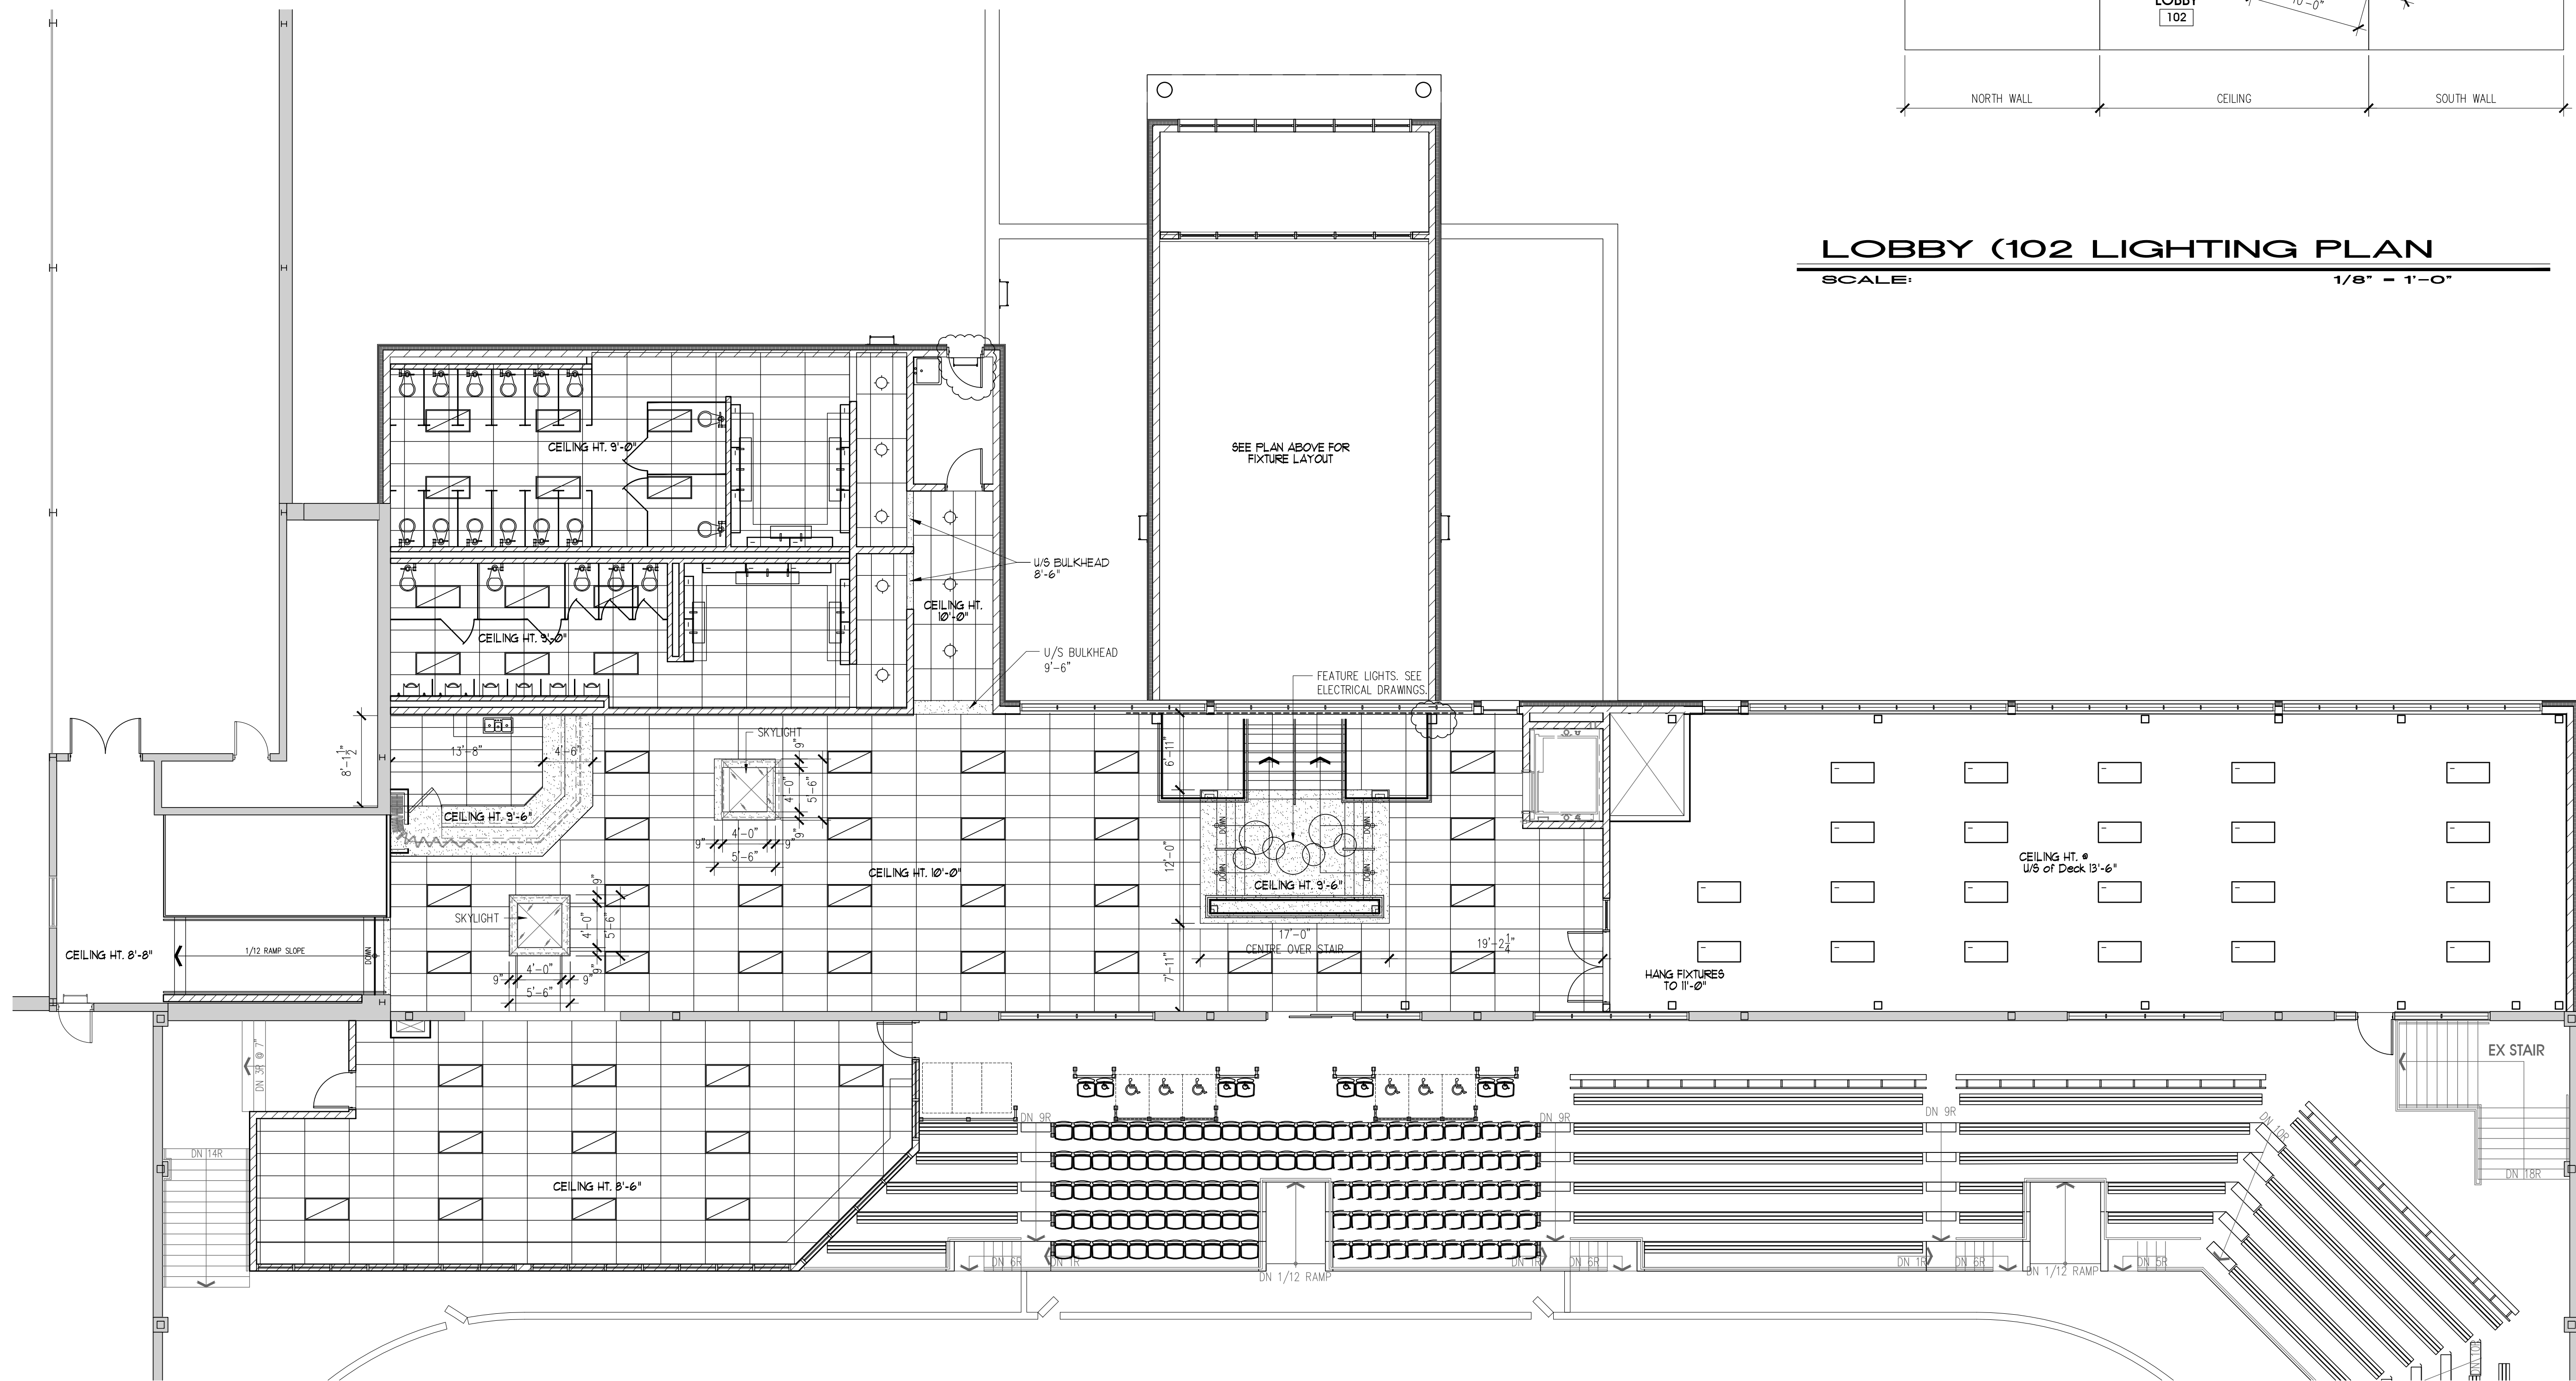

SECOND FLOOR RCP
SCALE: 1/8" = 1'-0"


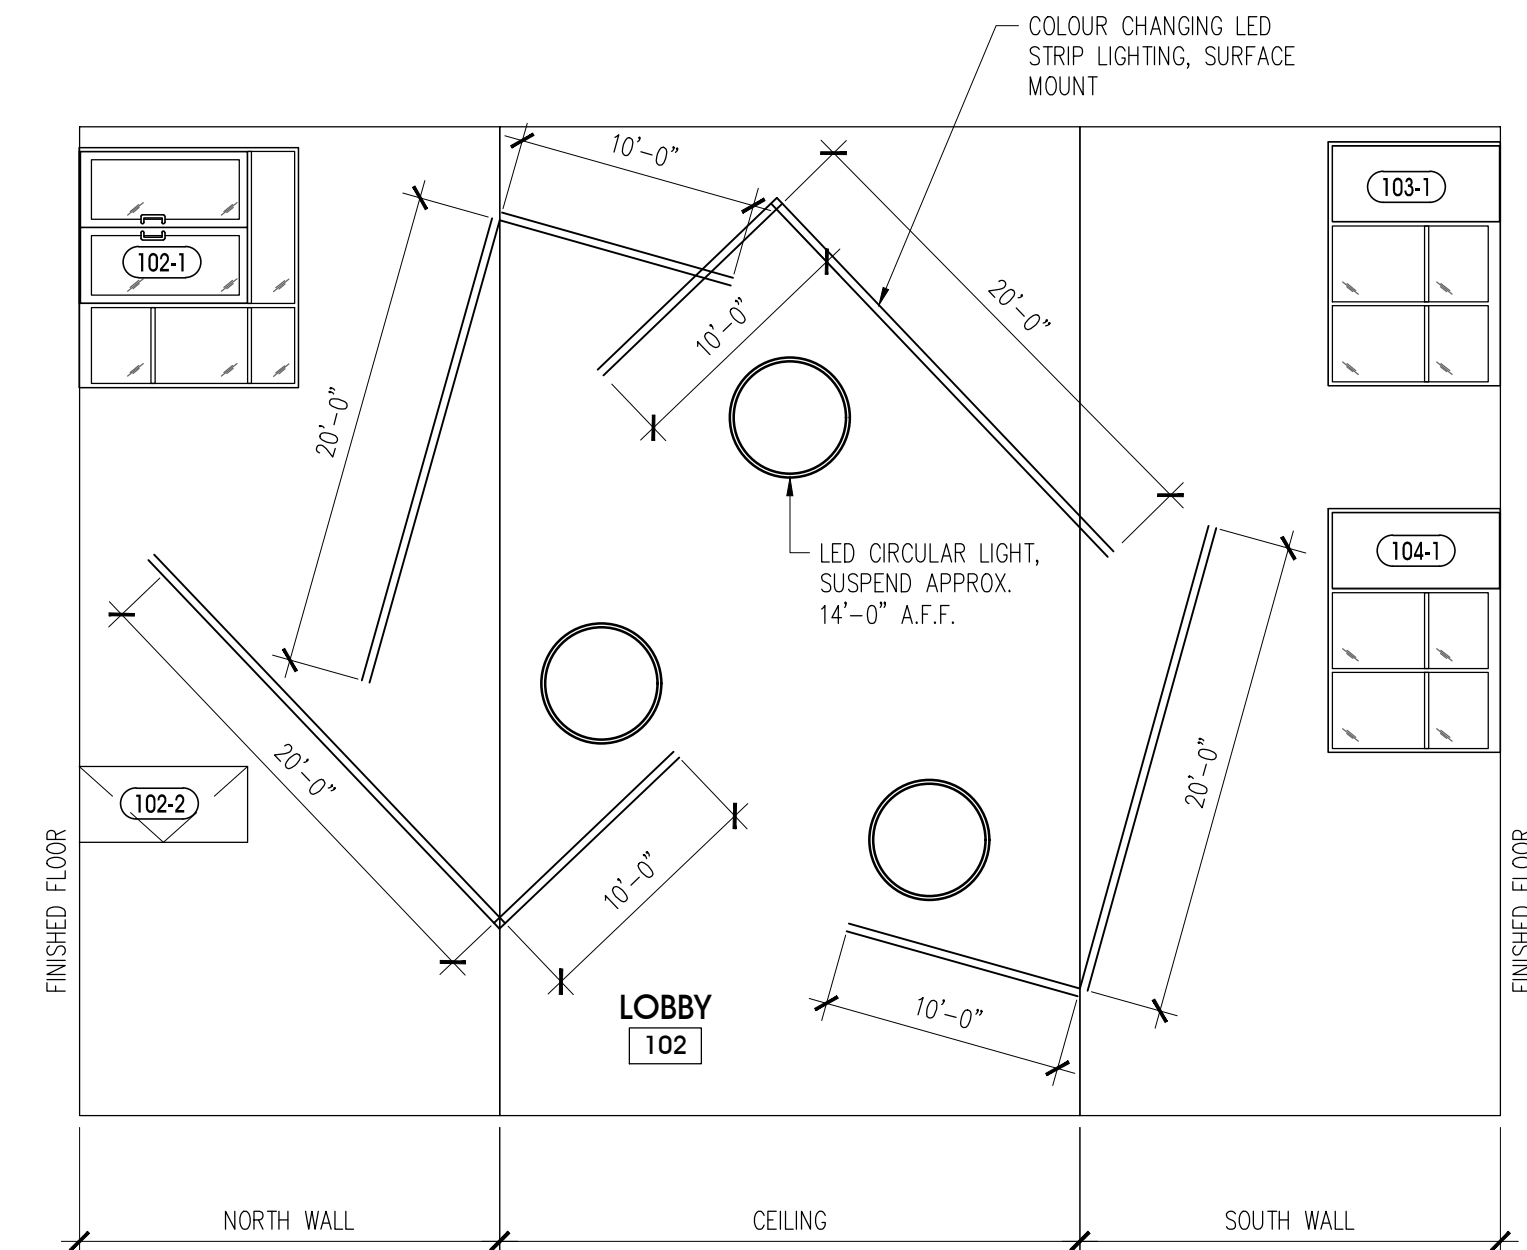


LOBBY (102 LIGHTING PLAN)
SCALE: 1/8" = 1'-0"

ISSUED FOR PERMIT	FEB. 01/22	
ADDENDA #2	DEC. 15/21	
ISSUED FOR TENDER	DEC. 01/21	
revisions	date	no.

CONTRACTORS MUST CHECK AND VERIFY ALL DIMENSIONS AND REPORT ANY DISCREPANCY TO THIS FIRM BEFORE PROCEEDING WITH THE WORK

A - detail no.
B - location sheet
C - detail sheet

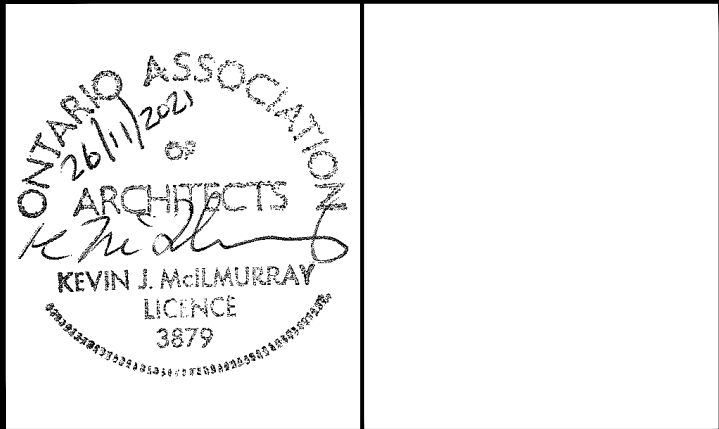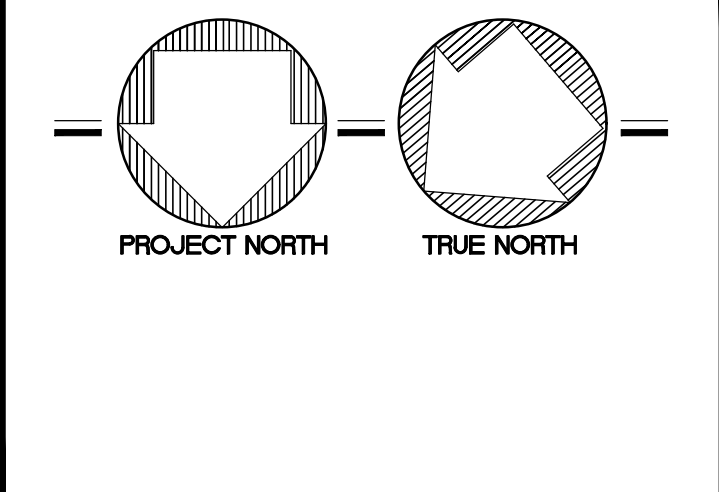

SPRIET ASSOCIATES


LIMITED architects
LONDON LTD. engineers

155 york street - london - N6A 1A8
phone : (519) 672-4100 fax : (519) 433-9351
e-mail : mail@spriet.on.ca

LUCAN BIDDULPH COMMUNITY MEMORIAL CENTRE
PHASE 2 - LUCAN ARENA
RENO'S & ARENA ADDITION
263 & 265 MAIN STREET, LUCAN, ONTARIO

drawing title :
SECOND FLOOR RCP

date : NOV 26, 2021	drawing no. :
scale : AS NOTED	A10
drawn by : MDO	
project no. : 216255-2	

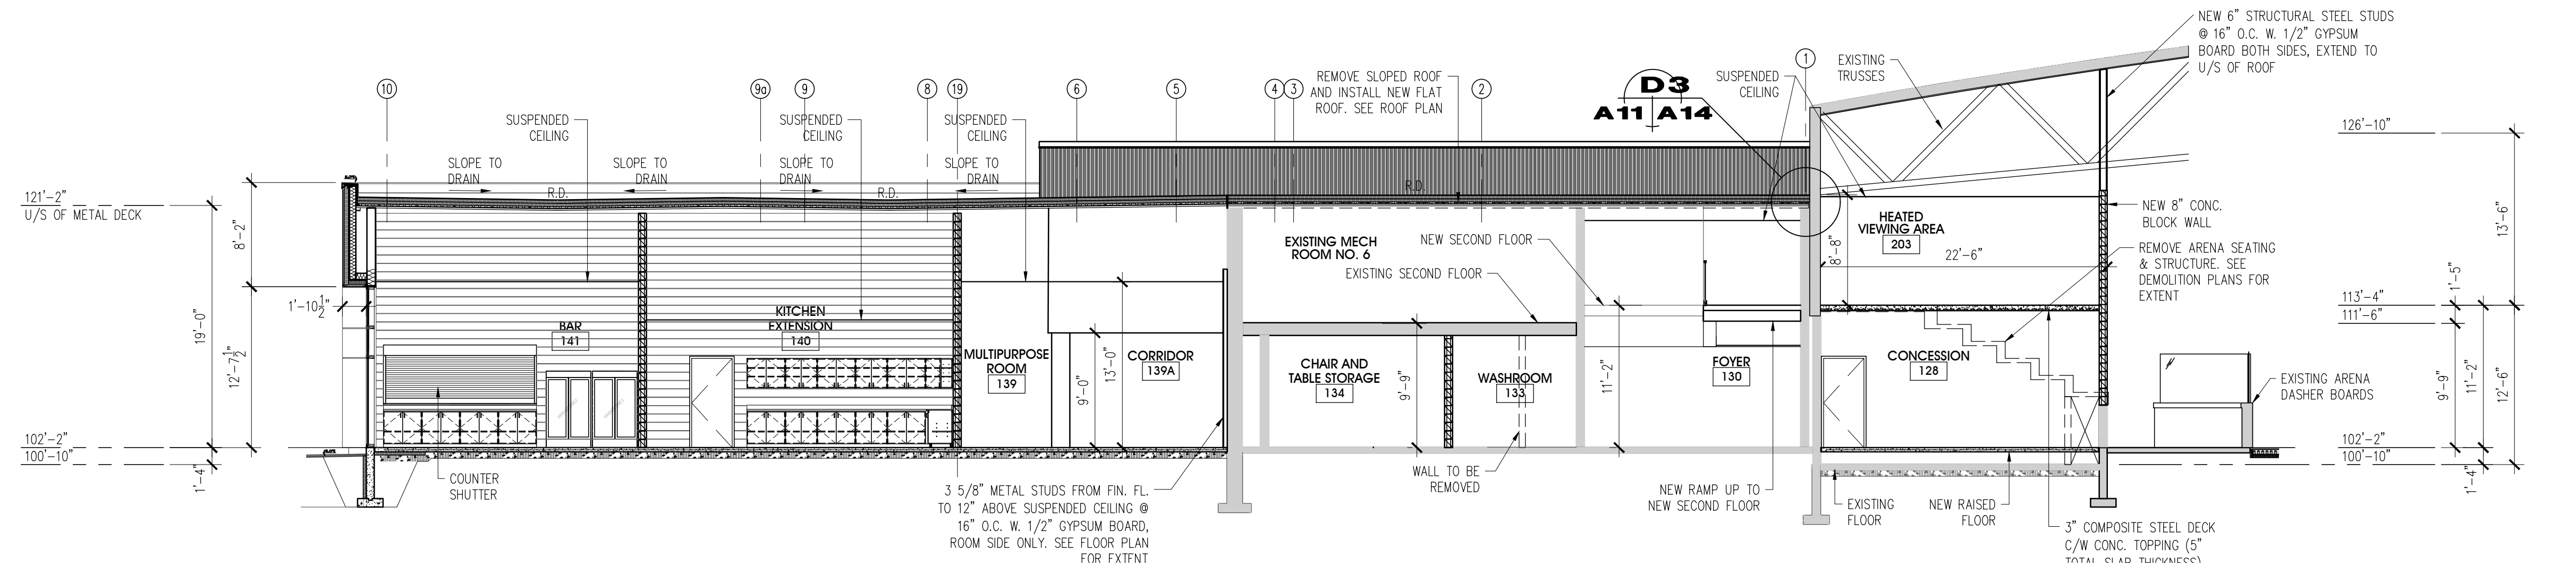


BUILDING SECTION

SCALE:

1/8" = 1'-0"

A-A
A2 A11

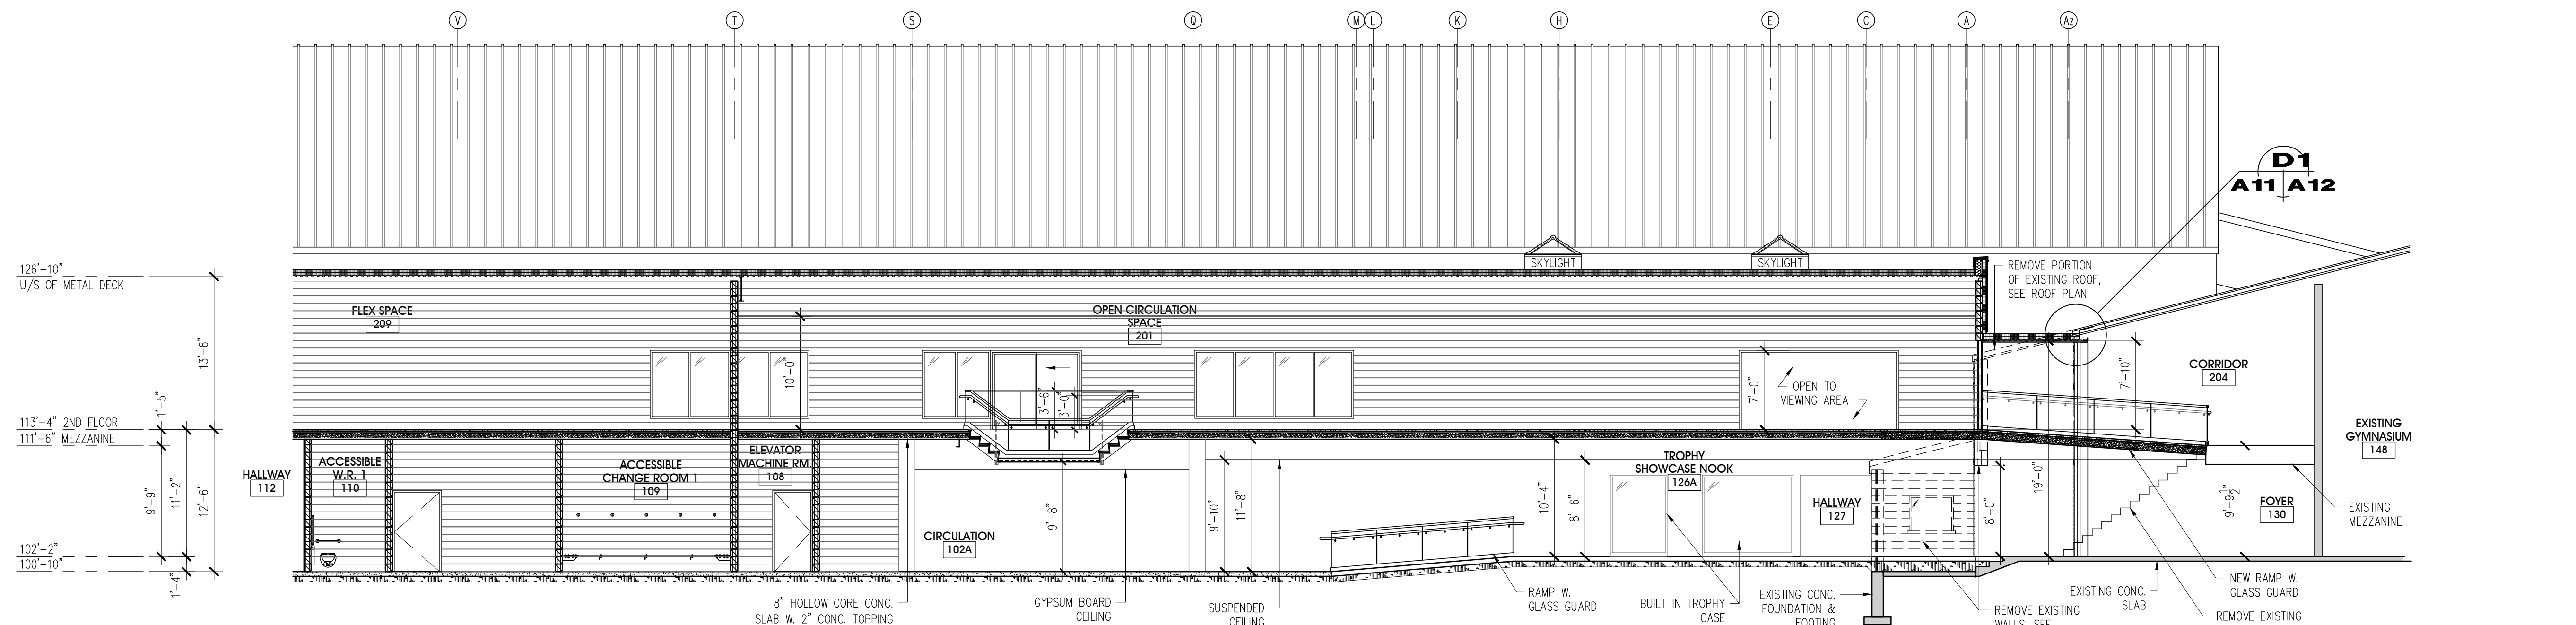


BUILDING SECTION

SCALE:

1/8" = 1'-0"

B-B
A2 A11

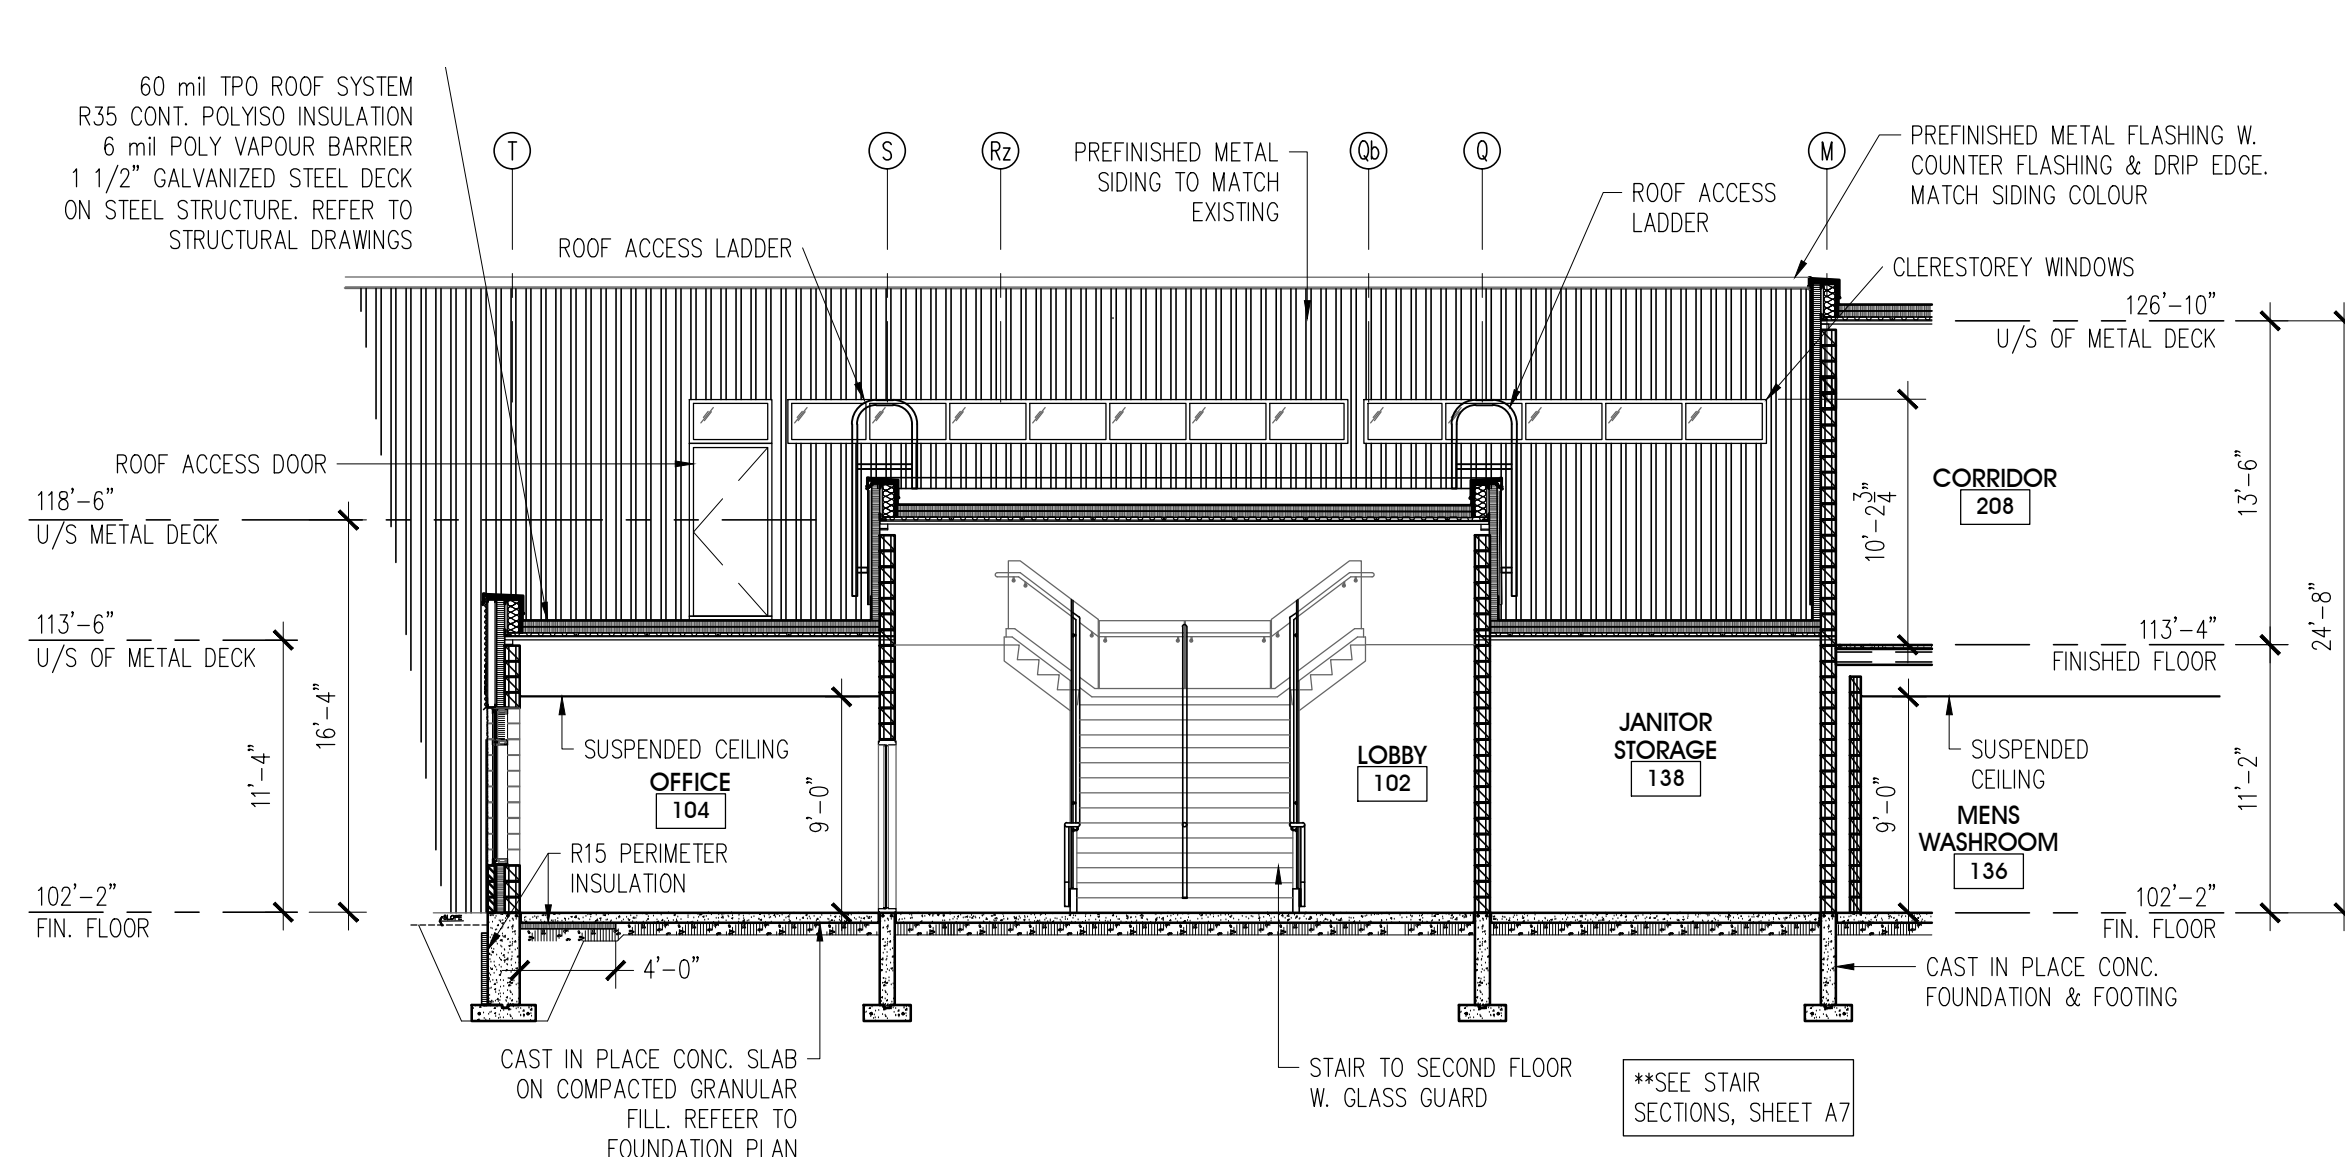


BUILDING SECTION

SCALE:

1/8" = 1'-0"

C-C
A2 A11

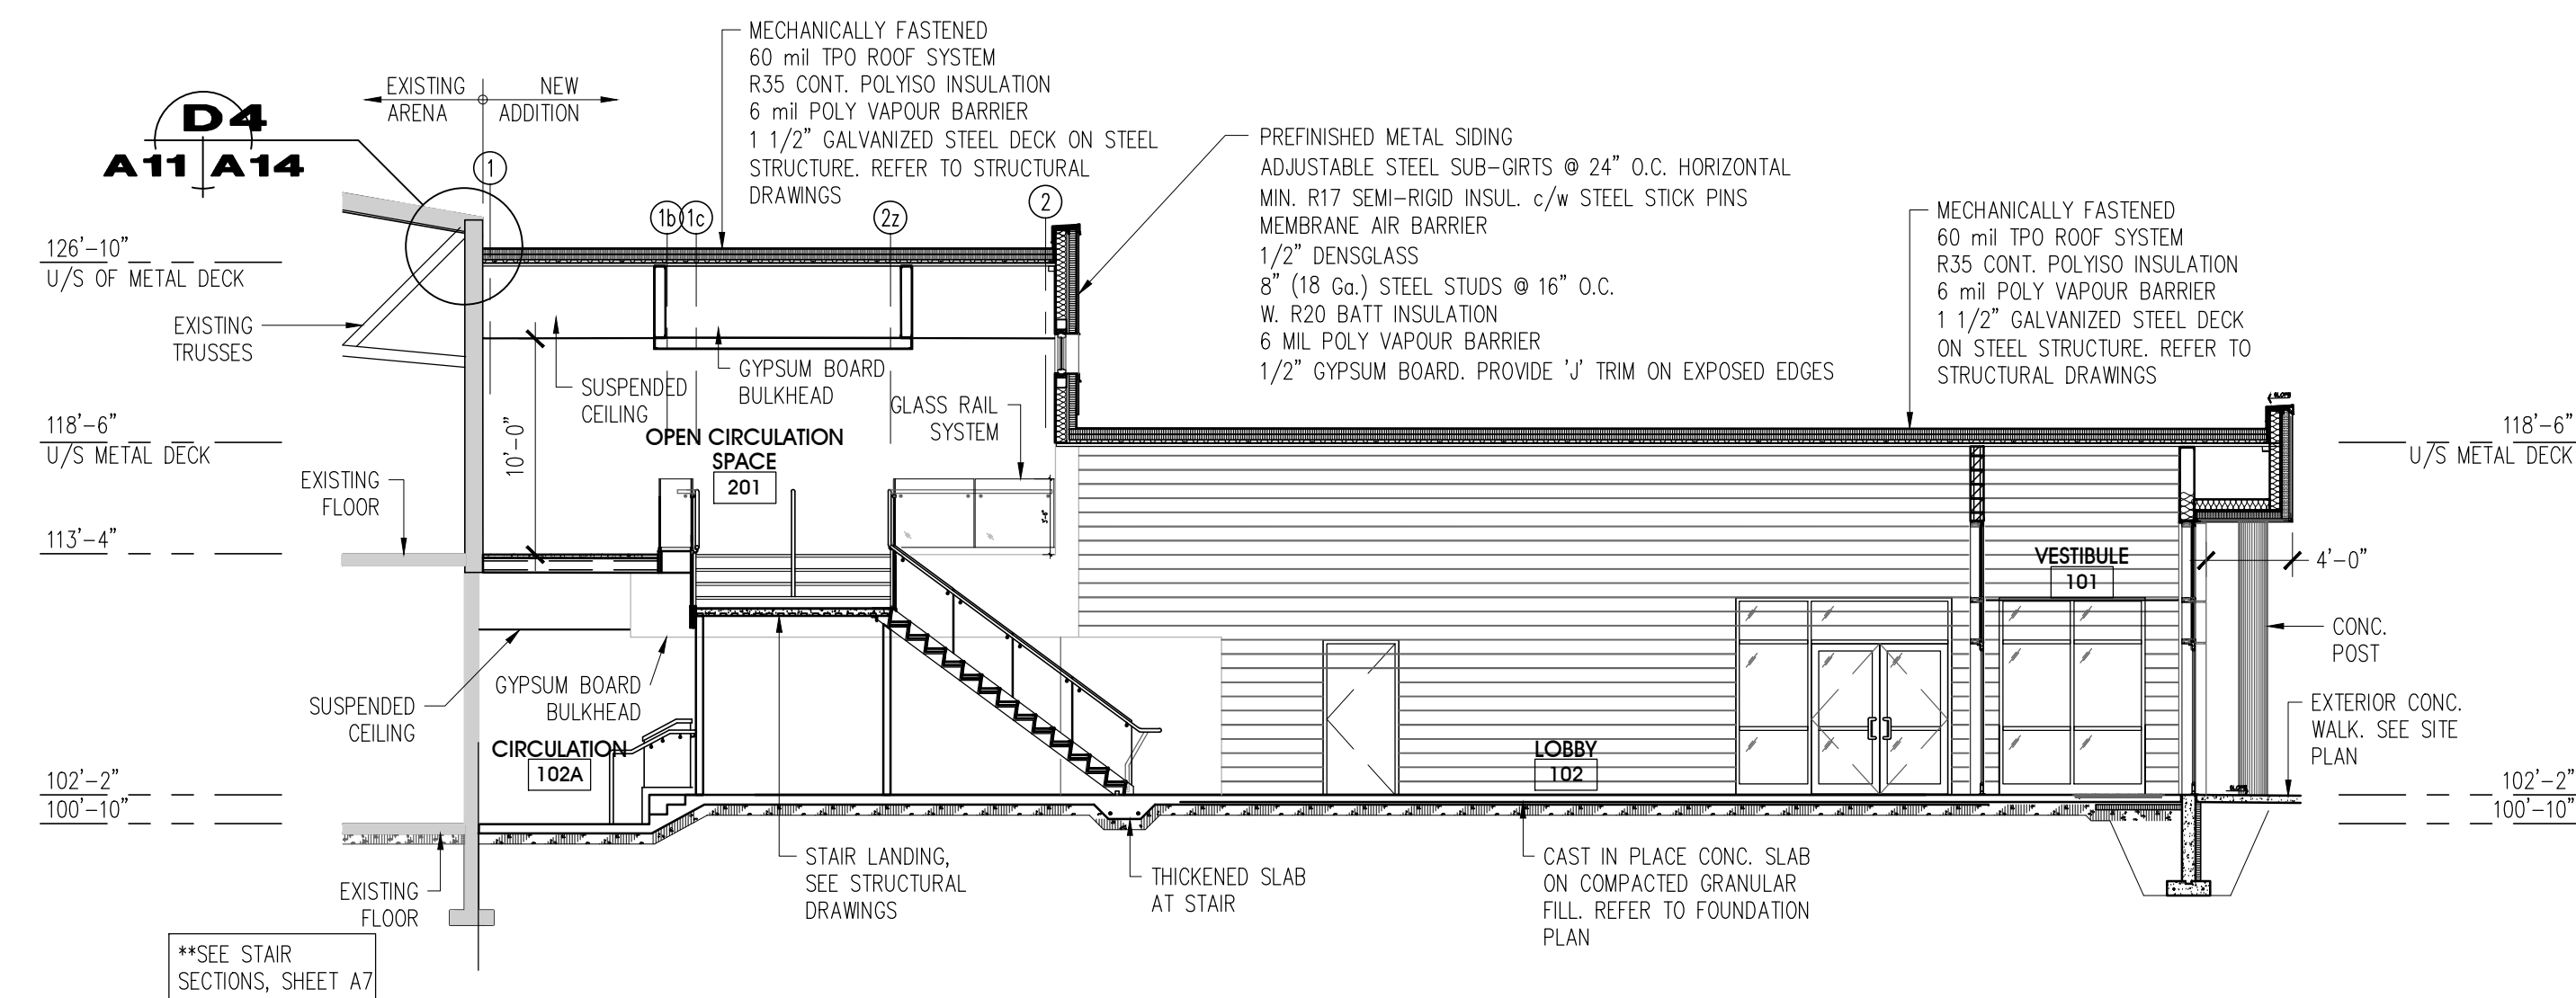

BUILDING SECTION

SCALE:



1/8" = 1'-0"

D-D
A2 A11

ISSUED FOR PERMIT	FEB. 01/22	
ADDENDA #2	DEC. 15/21	△
ISSUED FOR TENDER	DEC. 01/21	△
revisions	date	no.

CONTRACTORS MUST CHECK AND VERIFY ALL DIMENSIONS AND REPORT ANY DISCREPANCY TO THIS FIRM BEFORE PROCEEDING WITH THE WORK

A - detail no.
B - location sheet
C - detail sheet

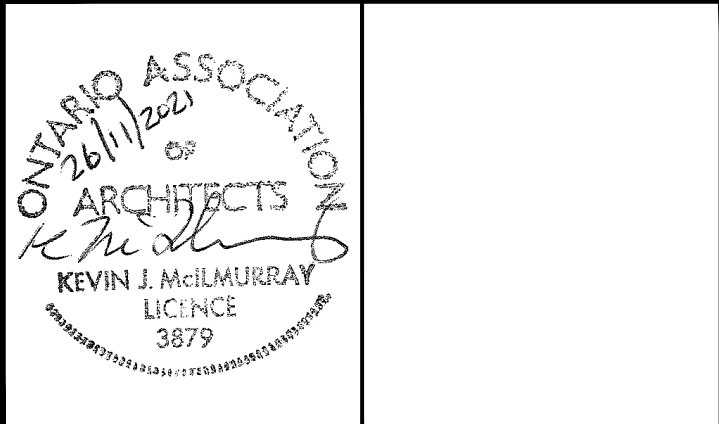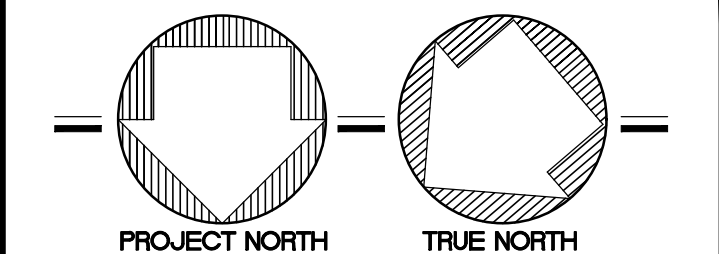


SPRIET ASSOCIATES

LIMITED architects
LONDON LTD. engineers
155 York Street - London - N6A 1A8
phone : (519) 672-4100 fax : (519) 433-9351
e-mail : mail@spriet.on.ca

LUCAN BIDDULPH COMMUNITY MEMORIAL CENTRE
PHASE 2 - LUCAN ARENA
RENO'S & ARENA ADDITION
263 & 265 MAIN STREET, LUCAN, ONTARIO


drawing title :	BUILDING SECTIONS	drawing no. :	A11
date :	NOV 26, 2021	project no. :	216255-2
scale :	AS NOTED		
drawn by :	MTH		

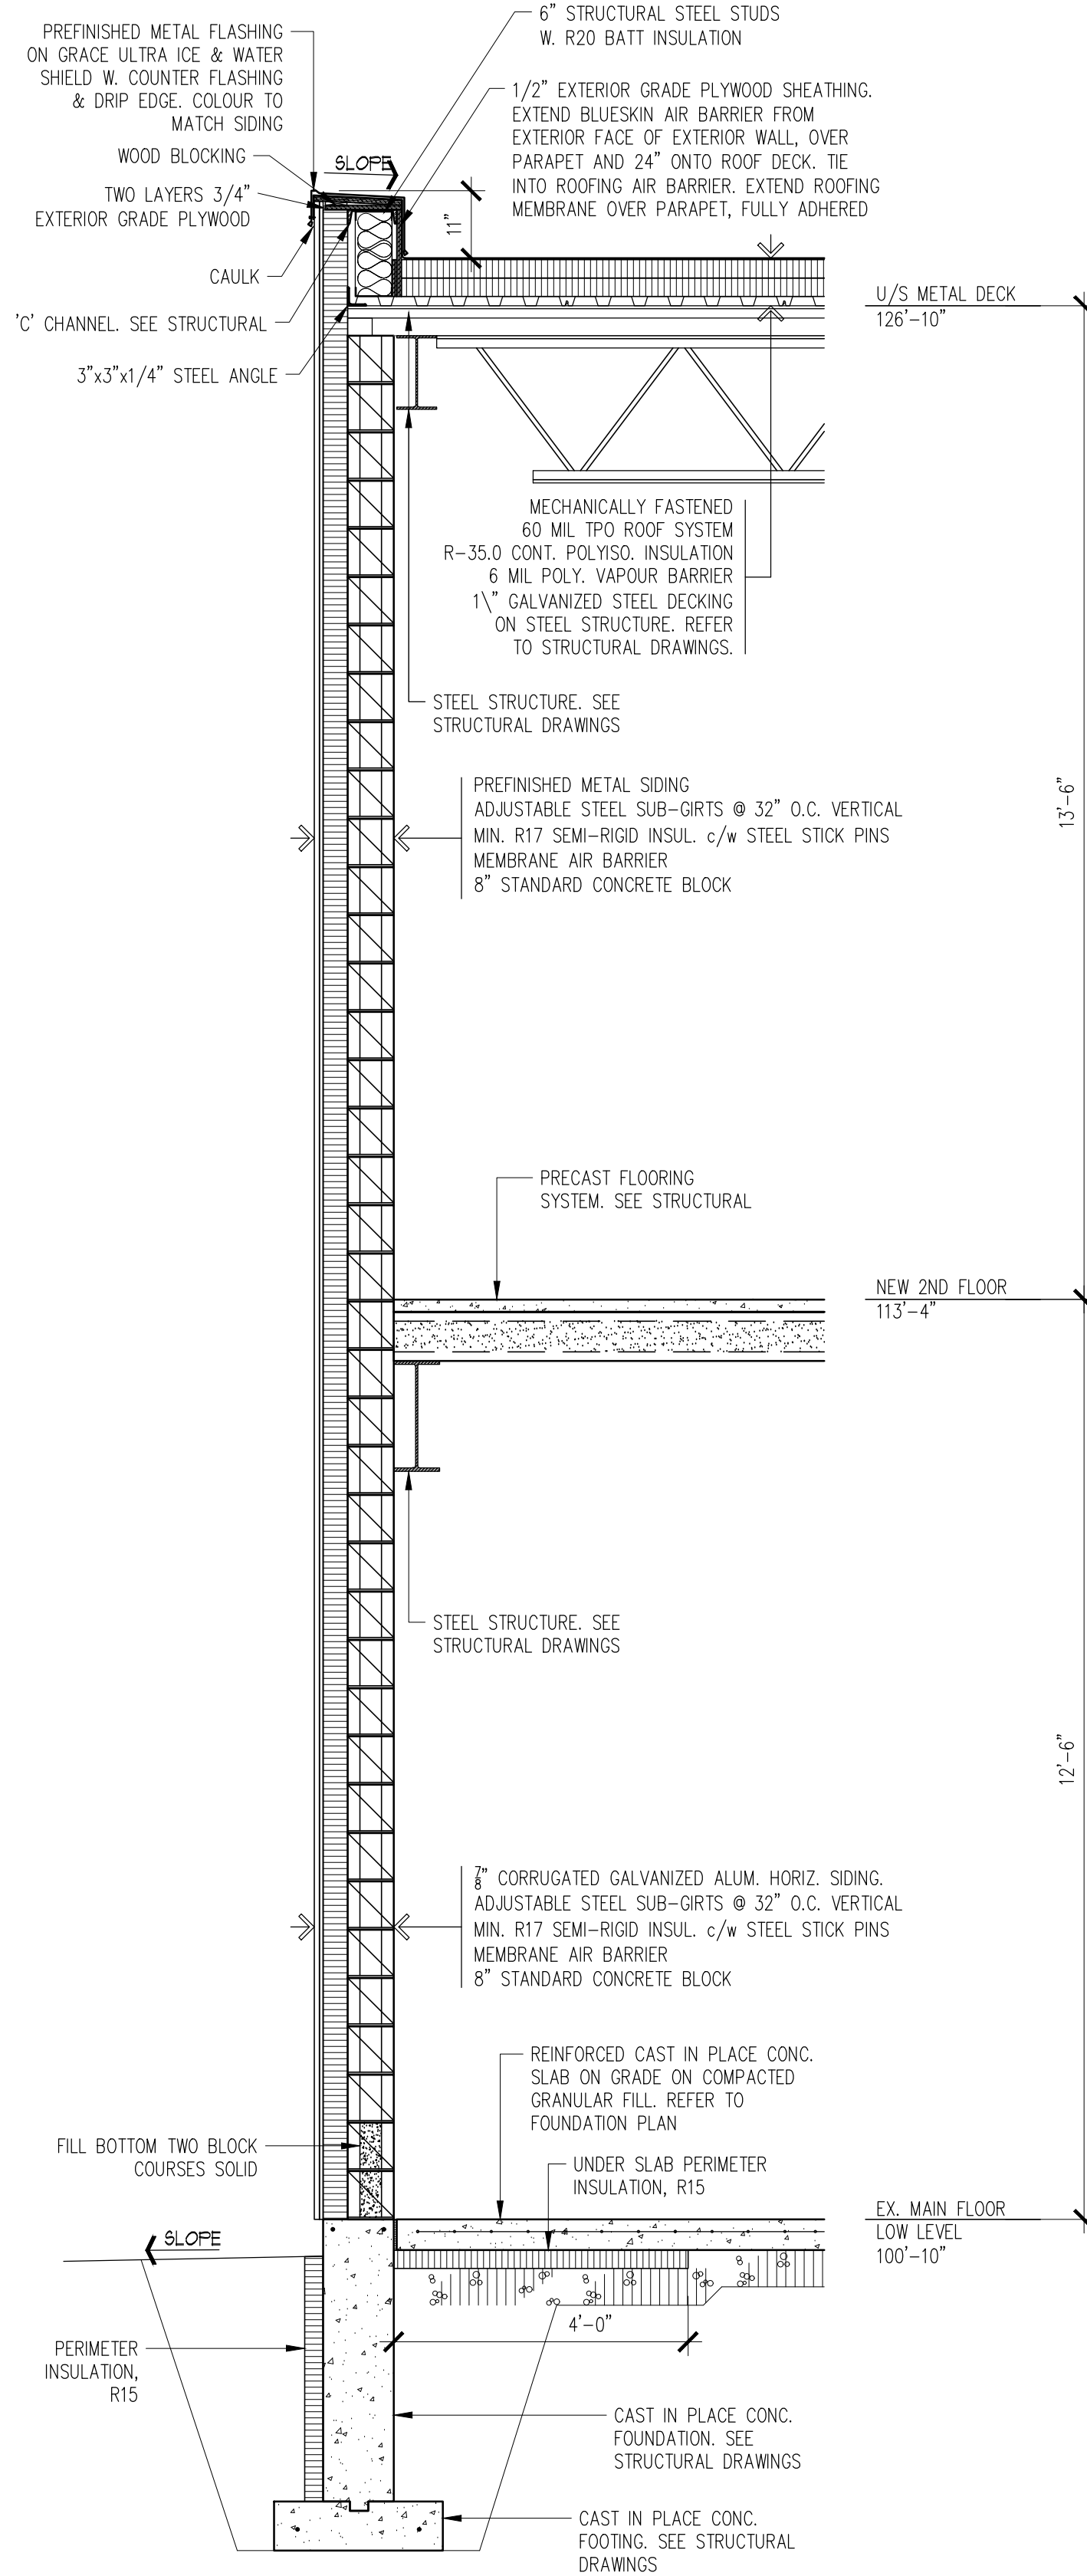

WALL SECTION 1

SCALE: 1/2" = 1'-0"


1
A5 A12

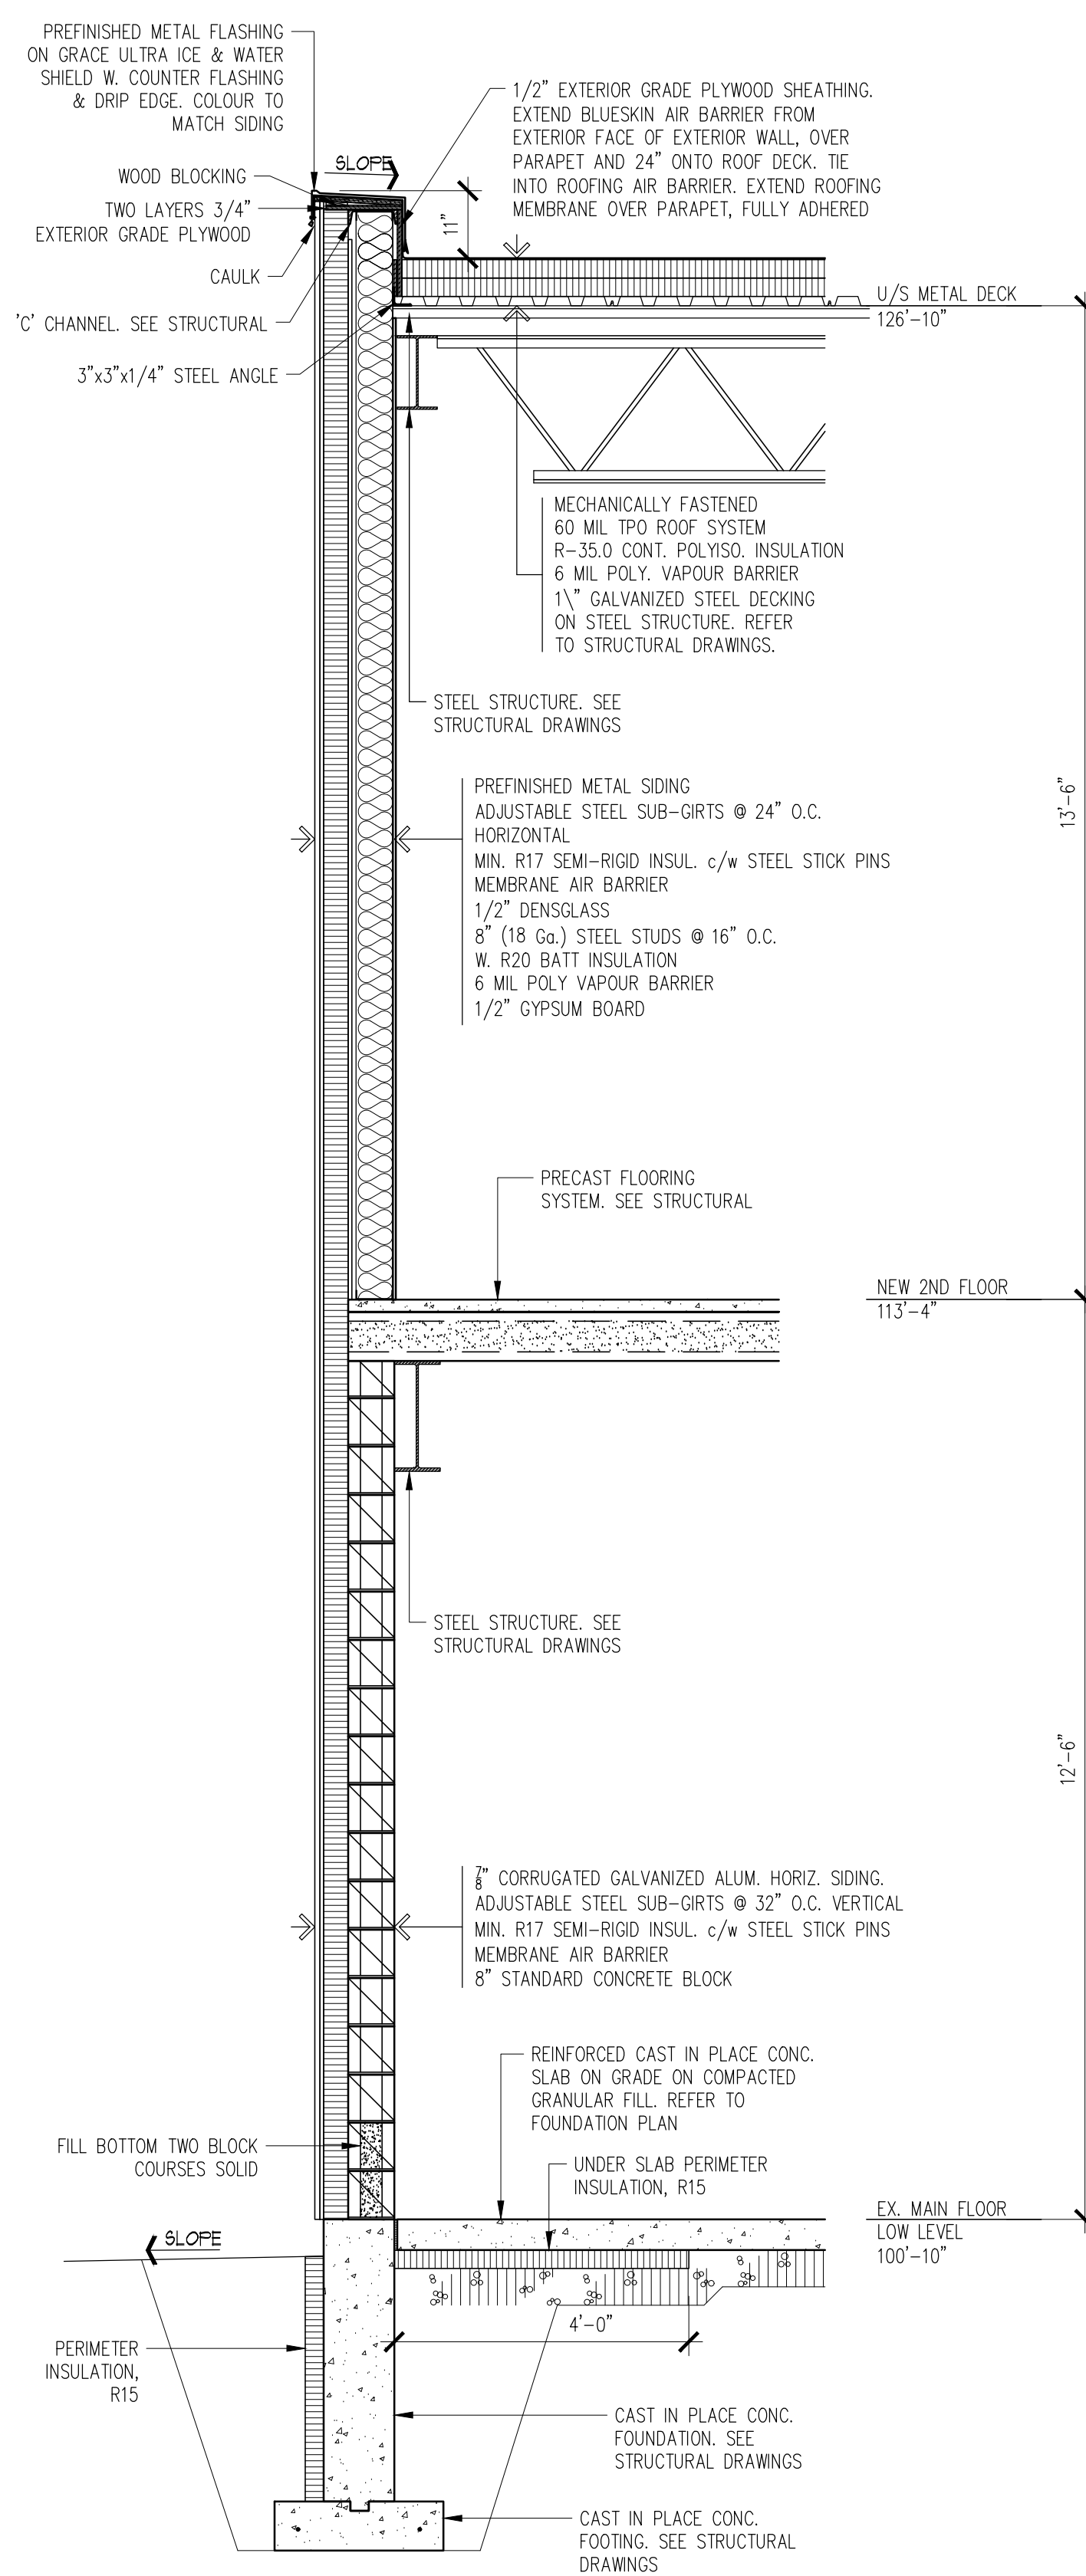

WALL SECTION 2

SCALE: 1/2" = 1'-0"

2
A5 A12

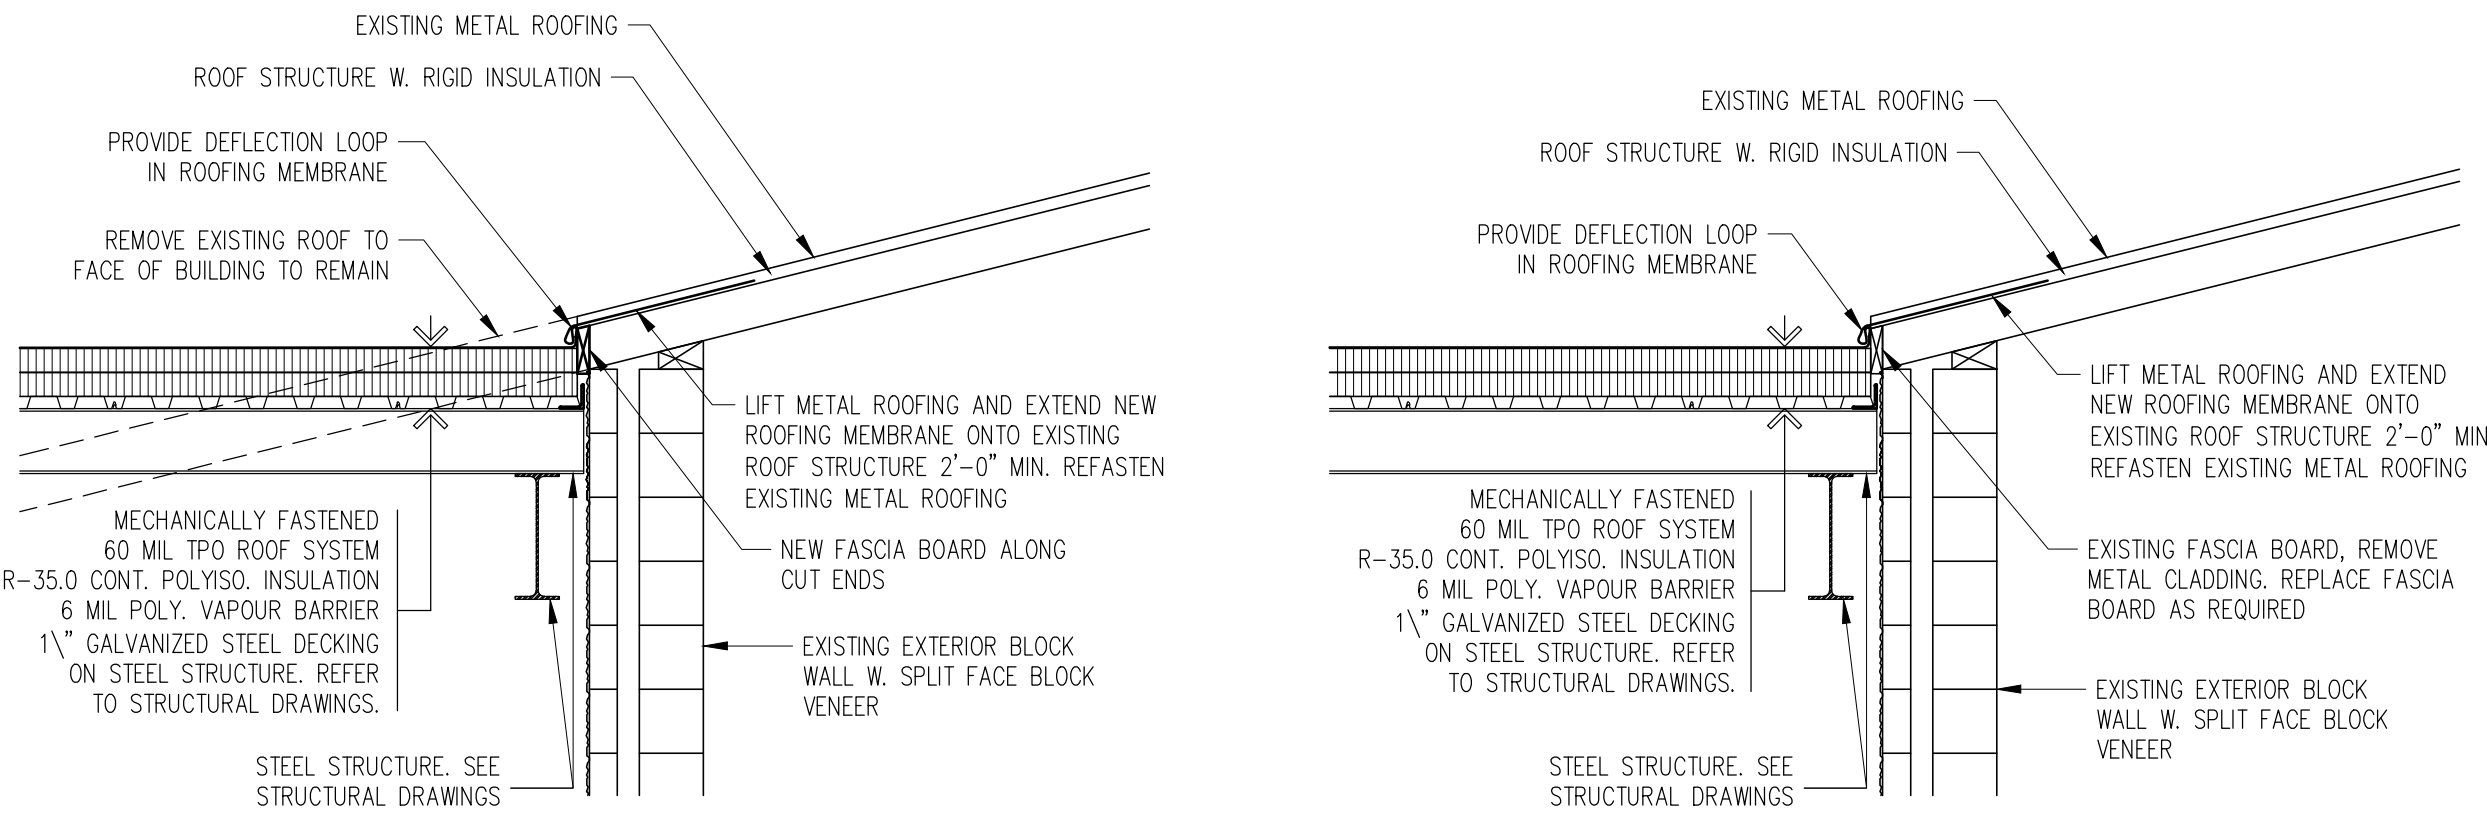

DETAIL D1


SCALE: 1/2" = 1'-0"

D1
A11 A12

DETAIL D2

SCALE: 1/2" = 1'-0"

D2
A11 A12

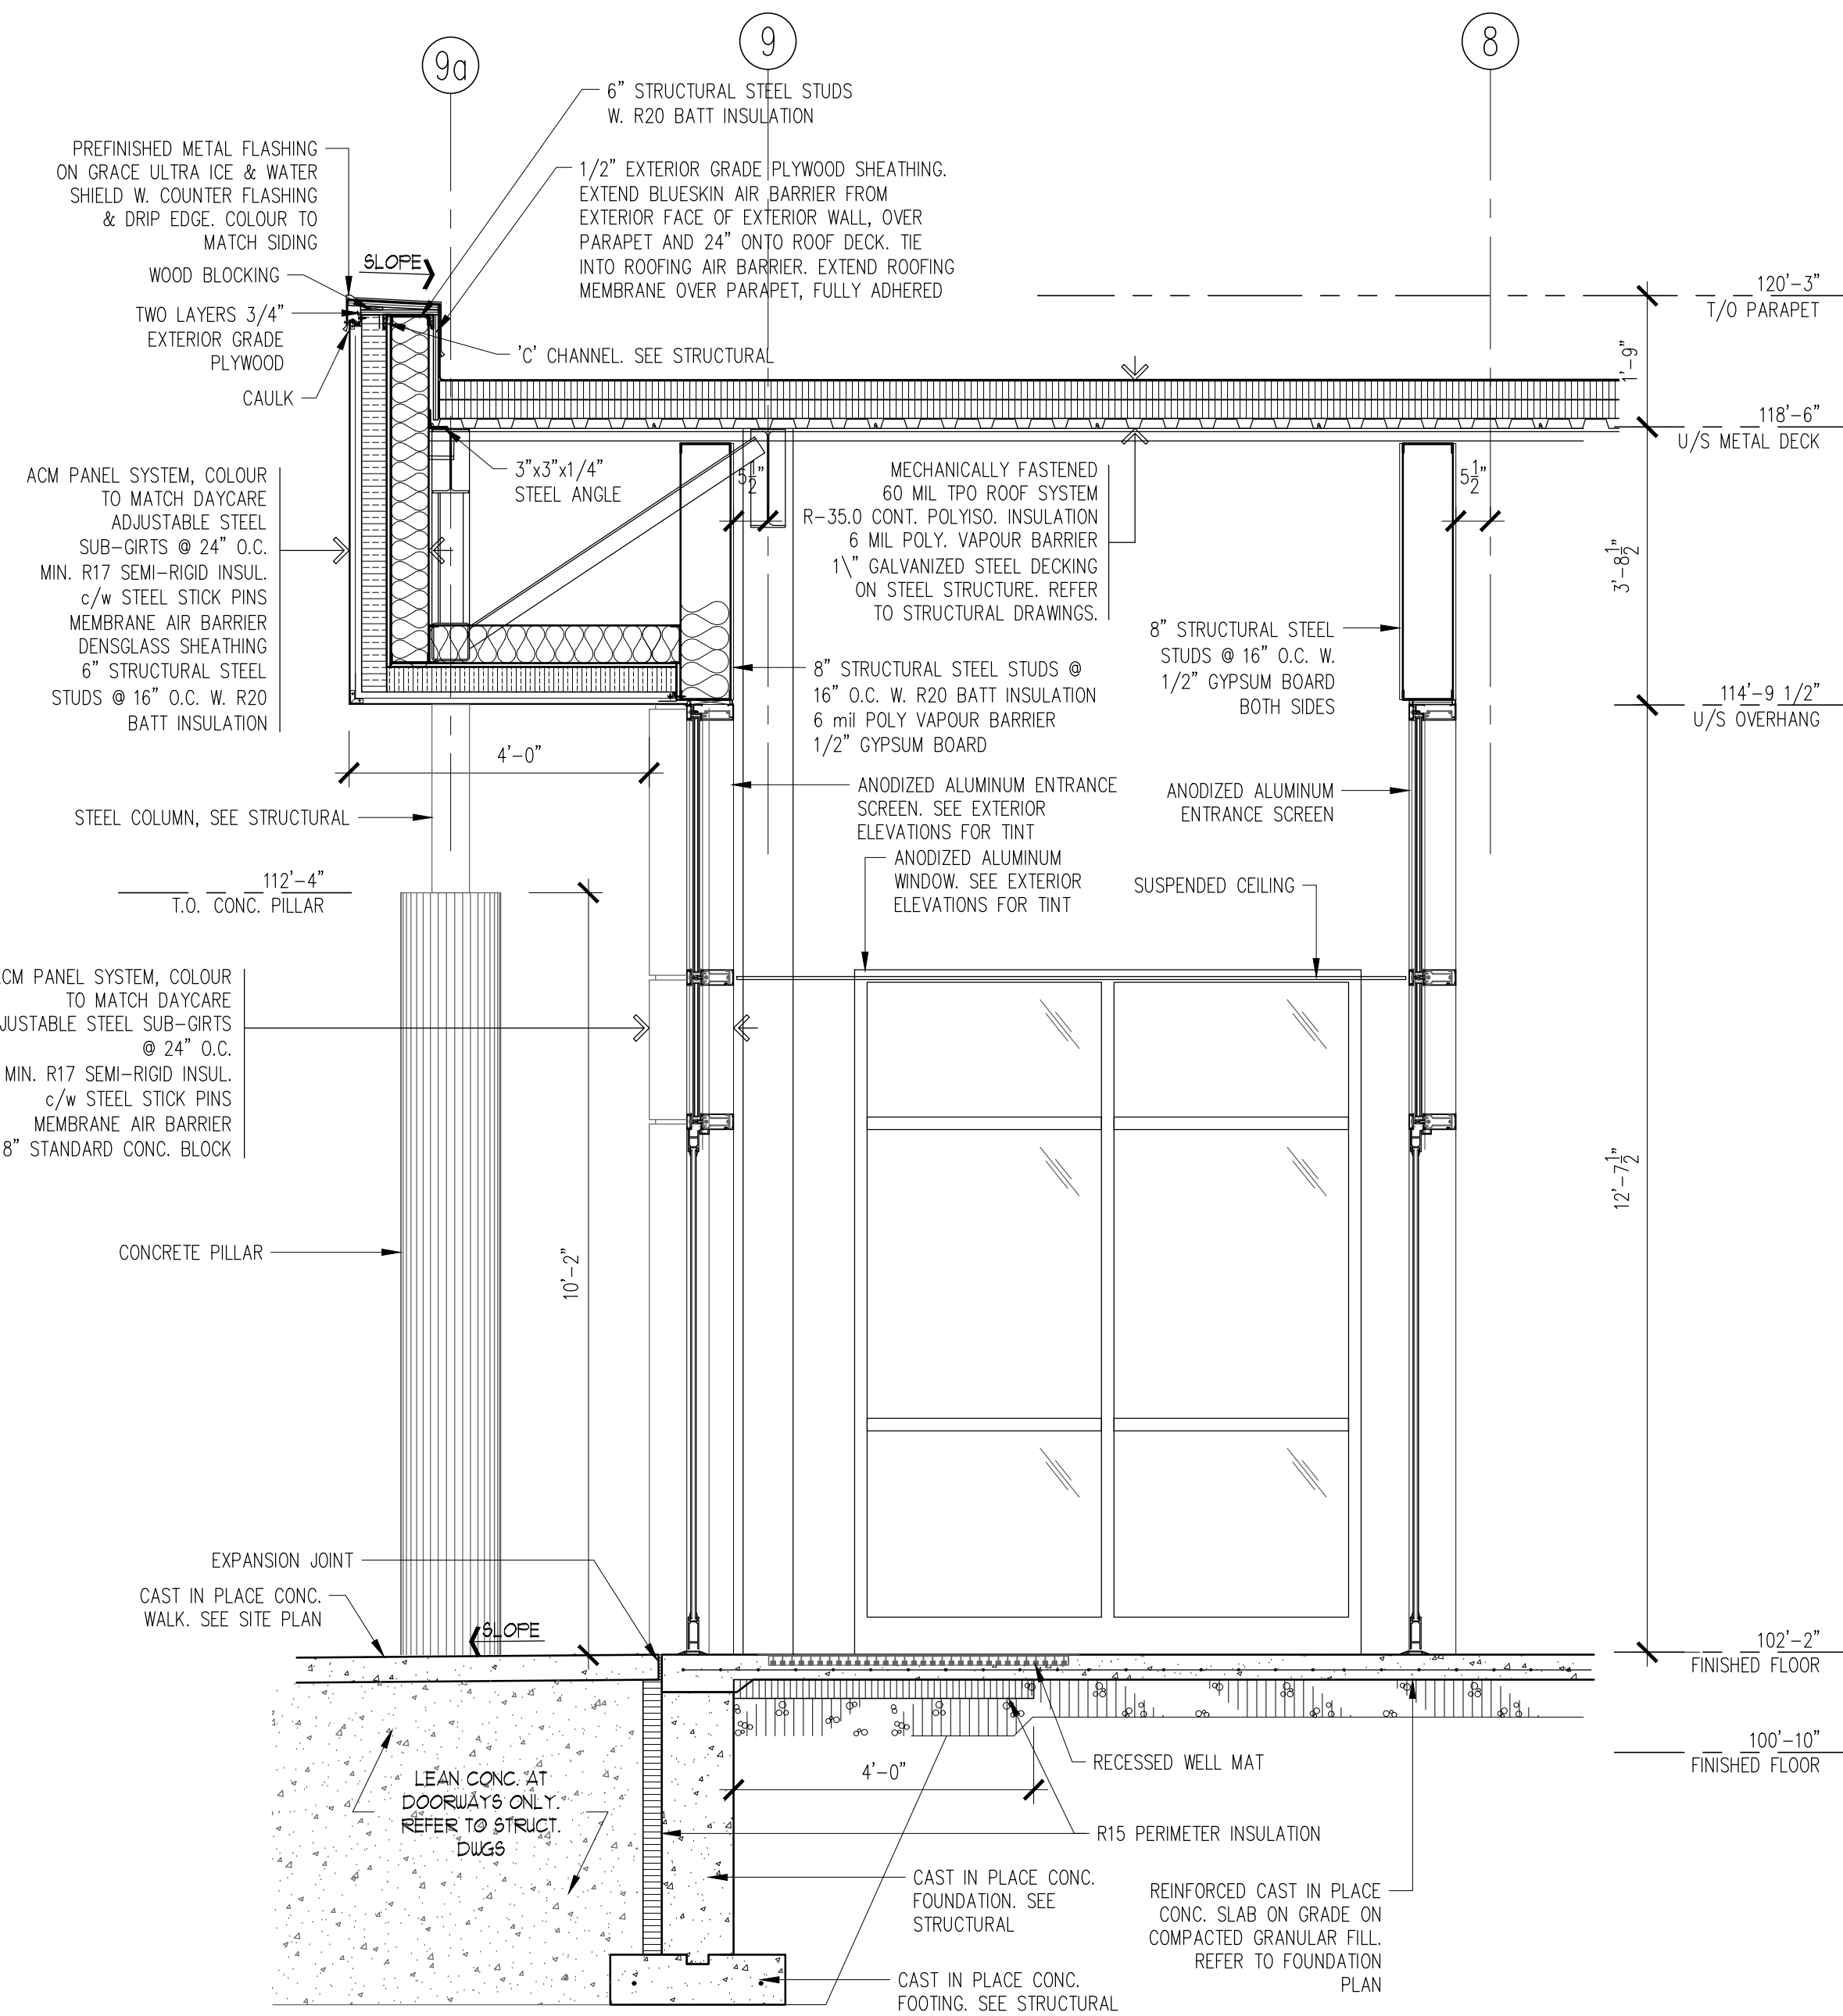

WALL SECTION 3




SCALE: 1/2" = 1'-0"

3
A5 A12


ISSUED FOR PERMIT	FEB. 01/22	
ADDENDA #2	DEC. 15/21	
ISSUED FOR TENDER	DEC. 01/21	
revisions	date	no.

CONTRACTORS MUST CHECK AND VERIFY ALL DIMENSIONS AND REPORT ANY DISCREPANCY TO THIS FIRM BEFORE PROCEEDING WITH THE WORK

A - detail no.
B - location sheet
C - detail sheet

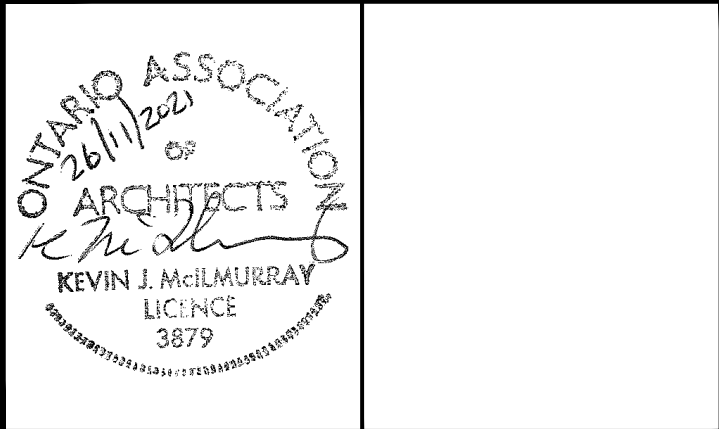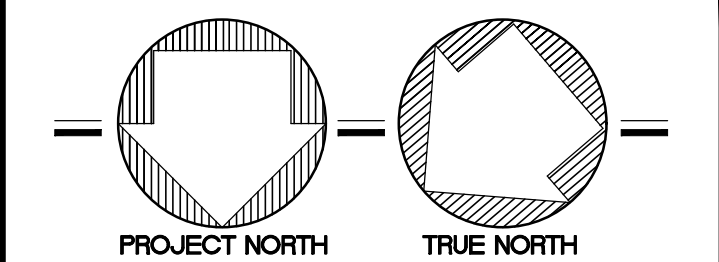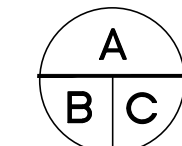

SPRIET ASSOCIATES

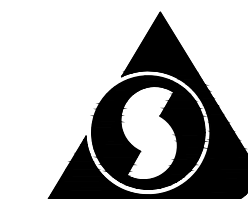

LIMITED
architects
LONDON LTD.
engineers

155 york street - london - N6A 1A8
phone : (519) 672-4100 fax : (519) 433-9351
e-mail : mail@spriet.on.ca

LUCAN BIDDULPH
COMMUNITY
MEMORIAL CENTRE
PHASE 2 - LUCAN ARENA
RENO'S & ARENA ADDITION
263 & 265 MAIN STREET, LUCAN, ONTARIO

drawing title :

SECTIONS

date : NOV 26, 2021
scale : AS NOTED
drawn by : MTH
project no. : 216255-2

drawing no. :




A12

- ### ROOF ACCESS LADDER NOTES

1. STRUCTURAL DESIGN INCLUDING ATTACHMENTS SHOULD BE DESIGNED BY A PROFESSIONAL ENGINEER.
2. JOISTS AND SURFACES OF FIXED LADDER INSTALLATIONS MUST BE FREE OF SHARP EDGES, BURRS OR OTHER DETAILS THAT MAY BE HAZARDOUS TO THE PERSON USING THE LADDER.
3. FLOOR SLIP RESISTANT FINISH ON RUNGS AND SIDE RAILS.
4. IF DISTANCE FROM TOP OF PARAFEST TO TOP OF ROOF EXCEEDS $1\frac{1}{2}$ (3000 mm) A MEANS OF CLIMBING TO AND FROM THE TOP OF PARAFEST IS REQUIRED.
5. TOP OF UPPERMOST RUNG OF A LADDER SHOULD BE LEVEL WITH THE TOP OF THE PARAFEST.
6. IF THE LADDER EXTENDS OVER $1\frac{1}{2}$ (3000 mm) ABOVE GRADE THE TOP OF LANDING MUST HAVE A SAFETY CAPE COMPENSING NOT MORE THAN $1\frac{1}{2}$ (3000 mm) ABOVE GRADE AND CONTINUING A MIN. OF 25° TO REST AT PLATFORMS OR TO THE TOP OF LANDING.

TYPICAL ROOF ACCESS LADDER DETAIL

SCALE: 1/2" = 1'-0"

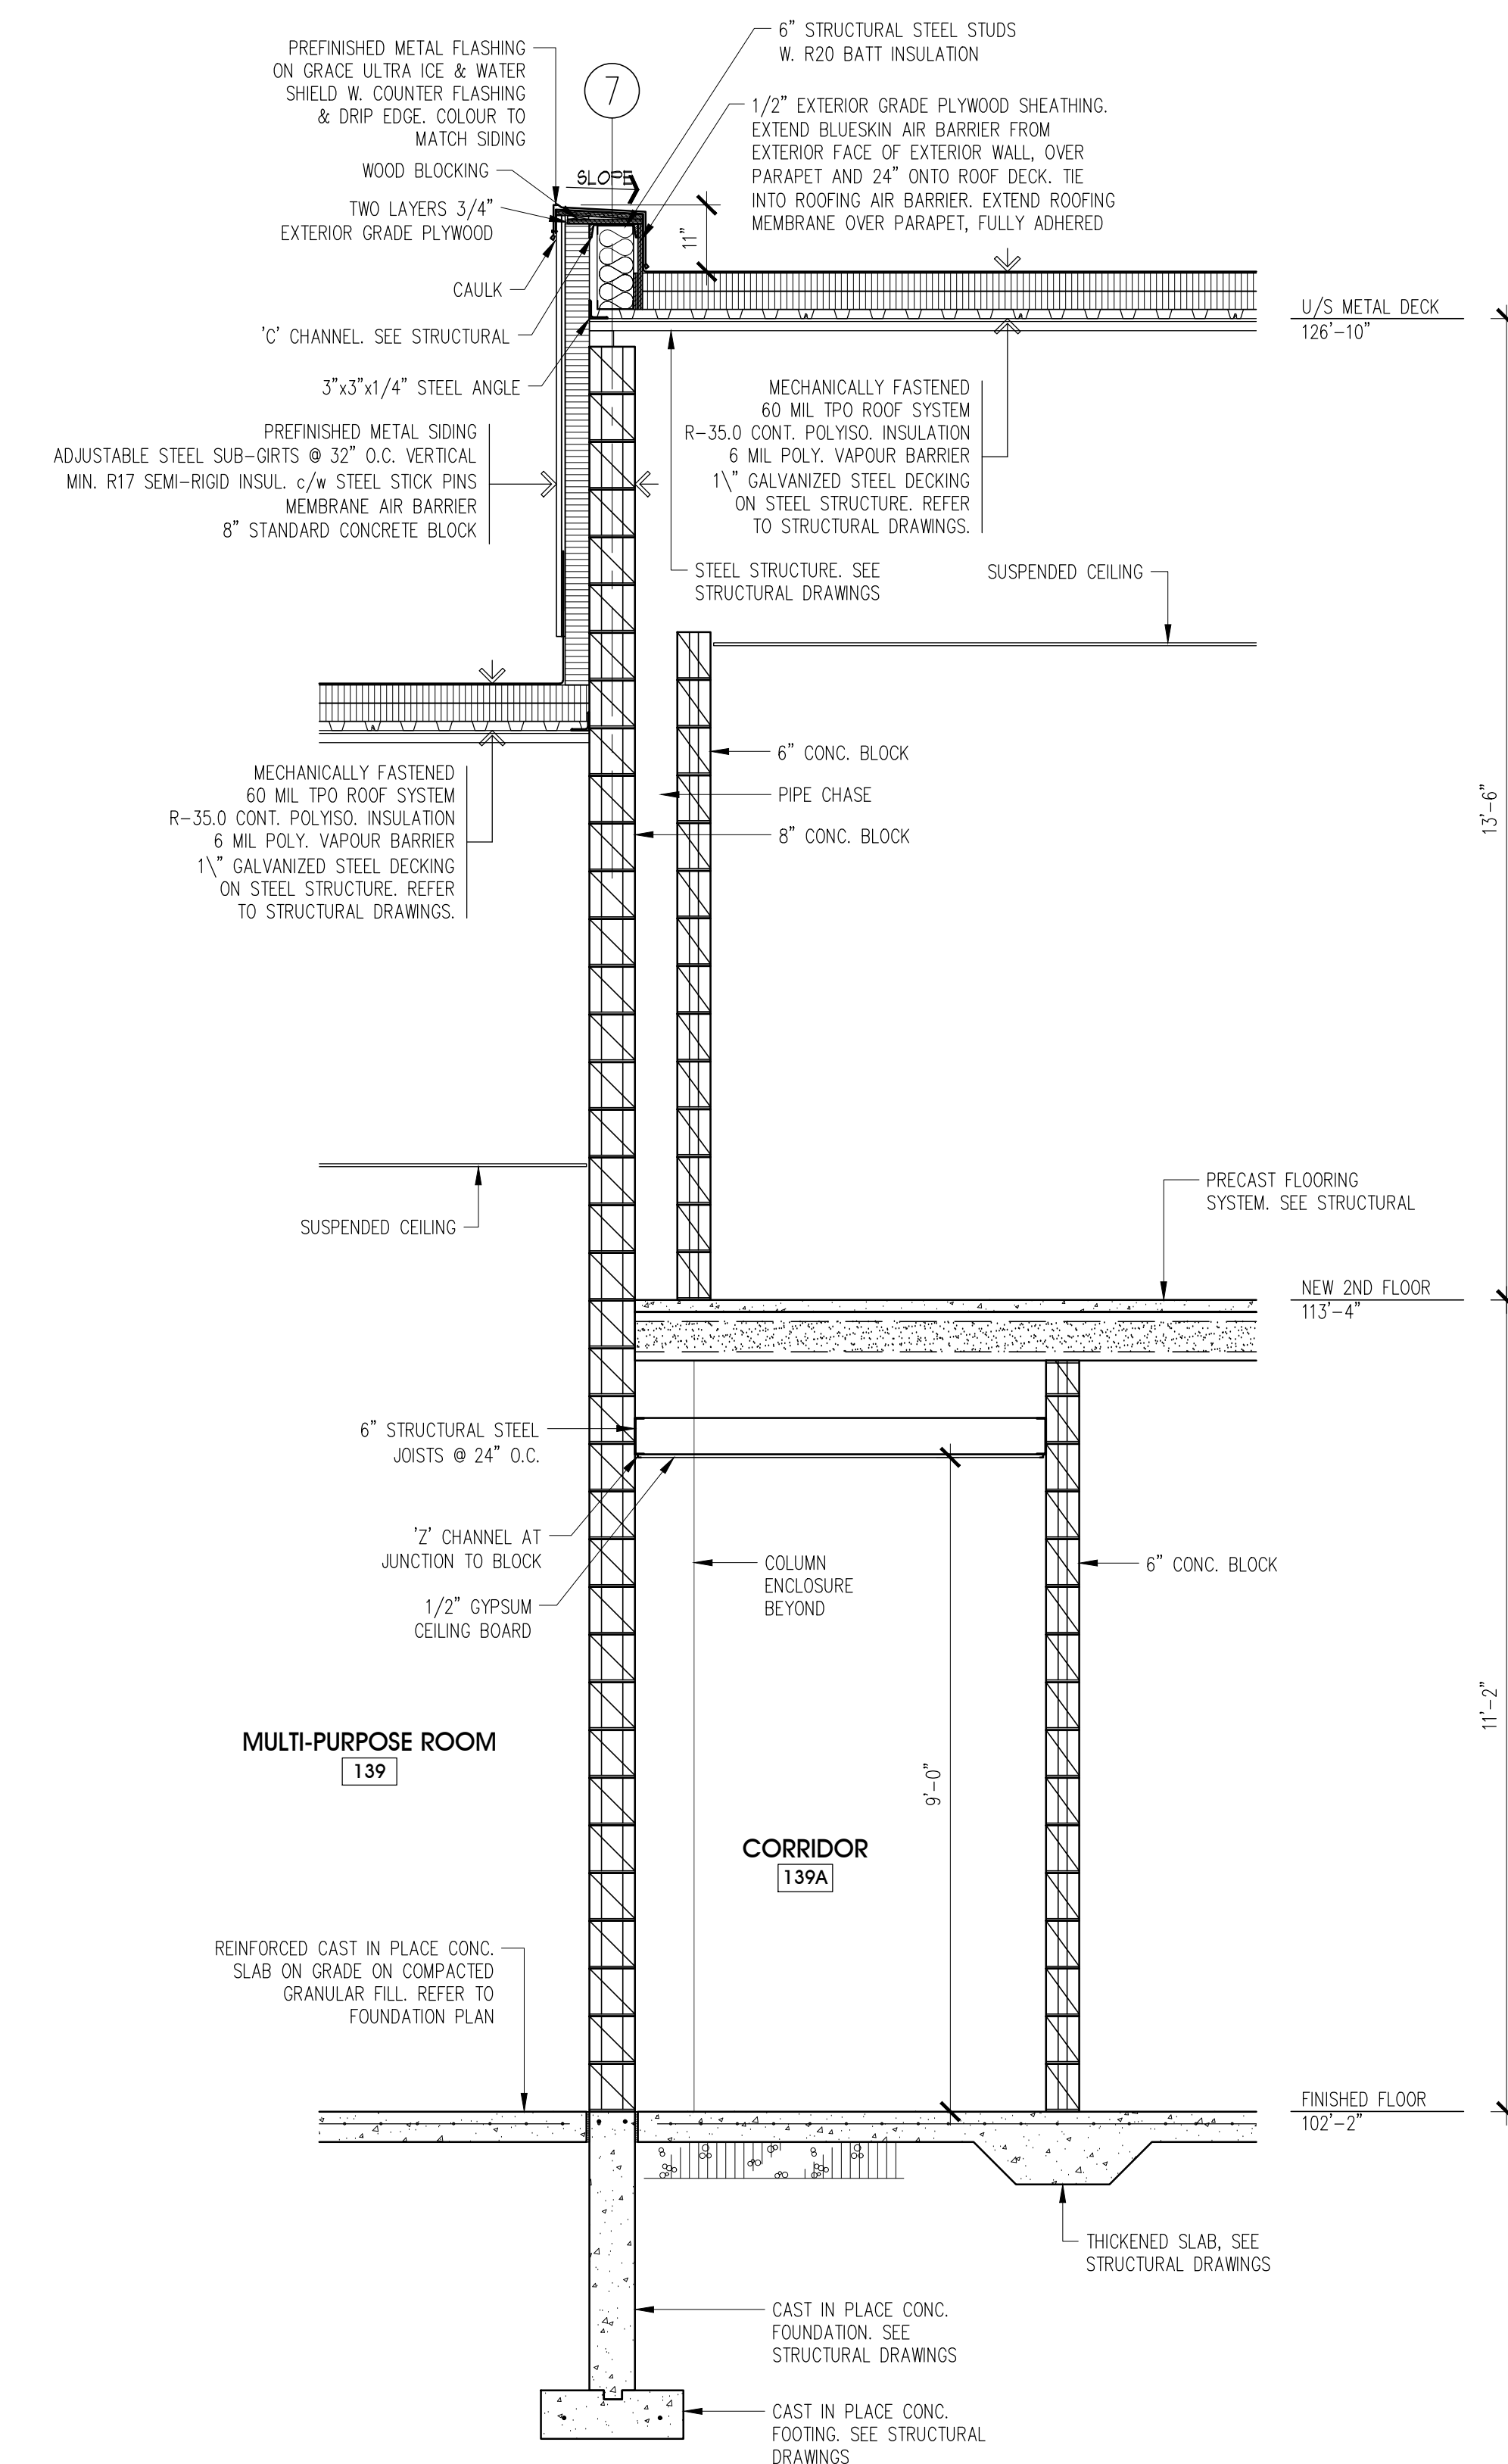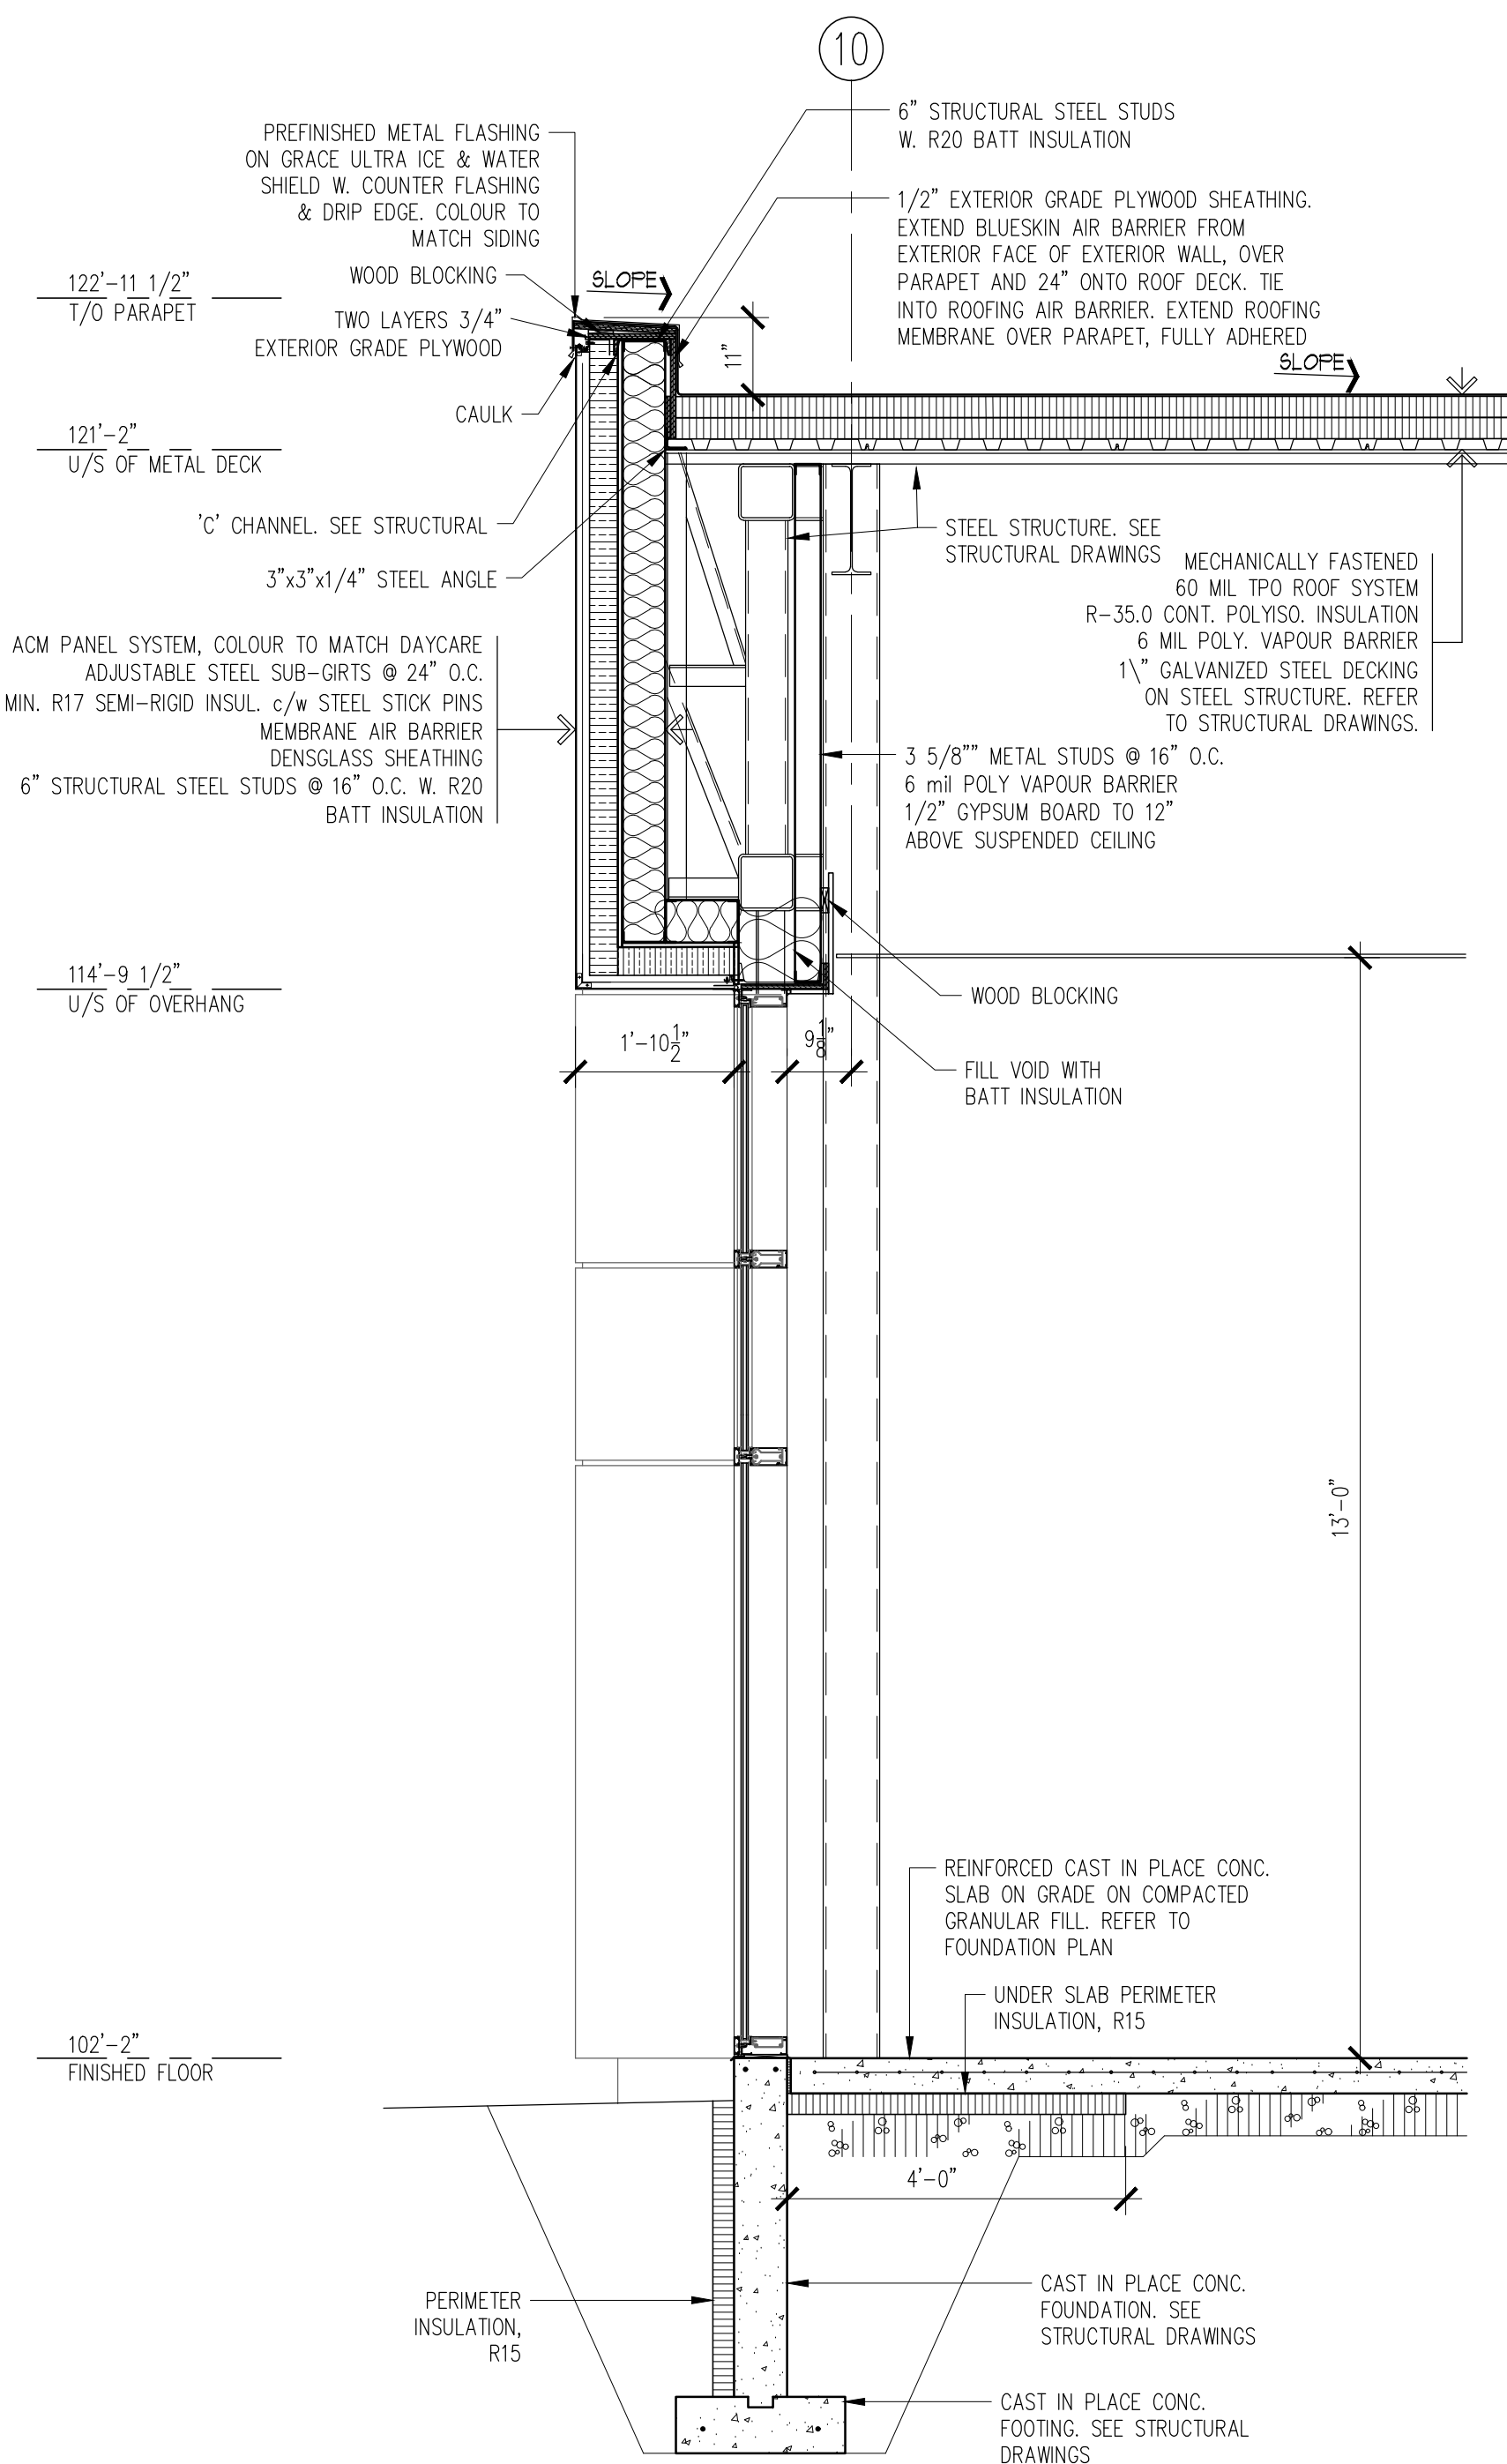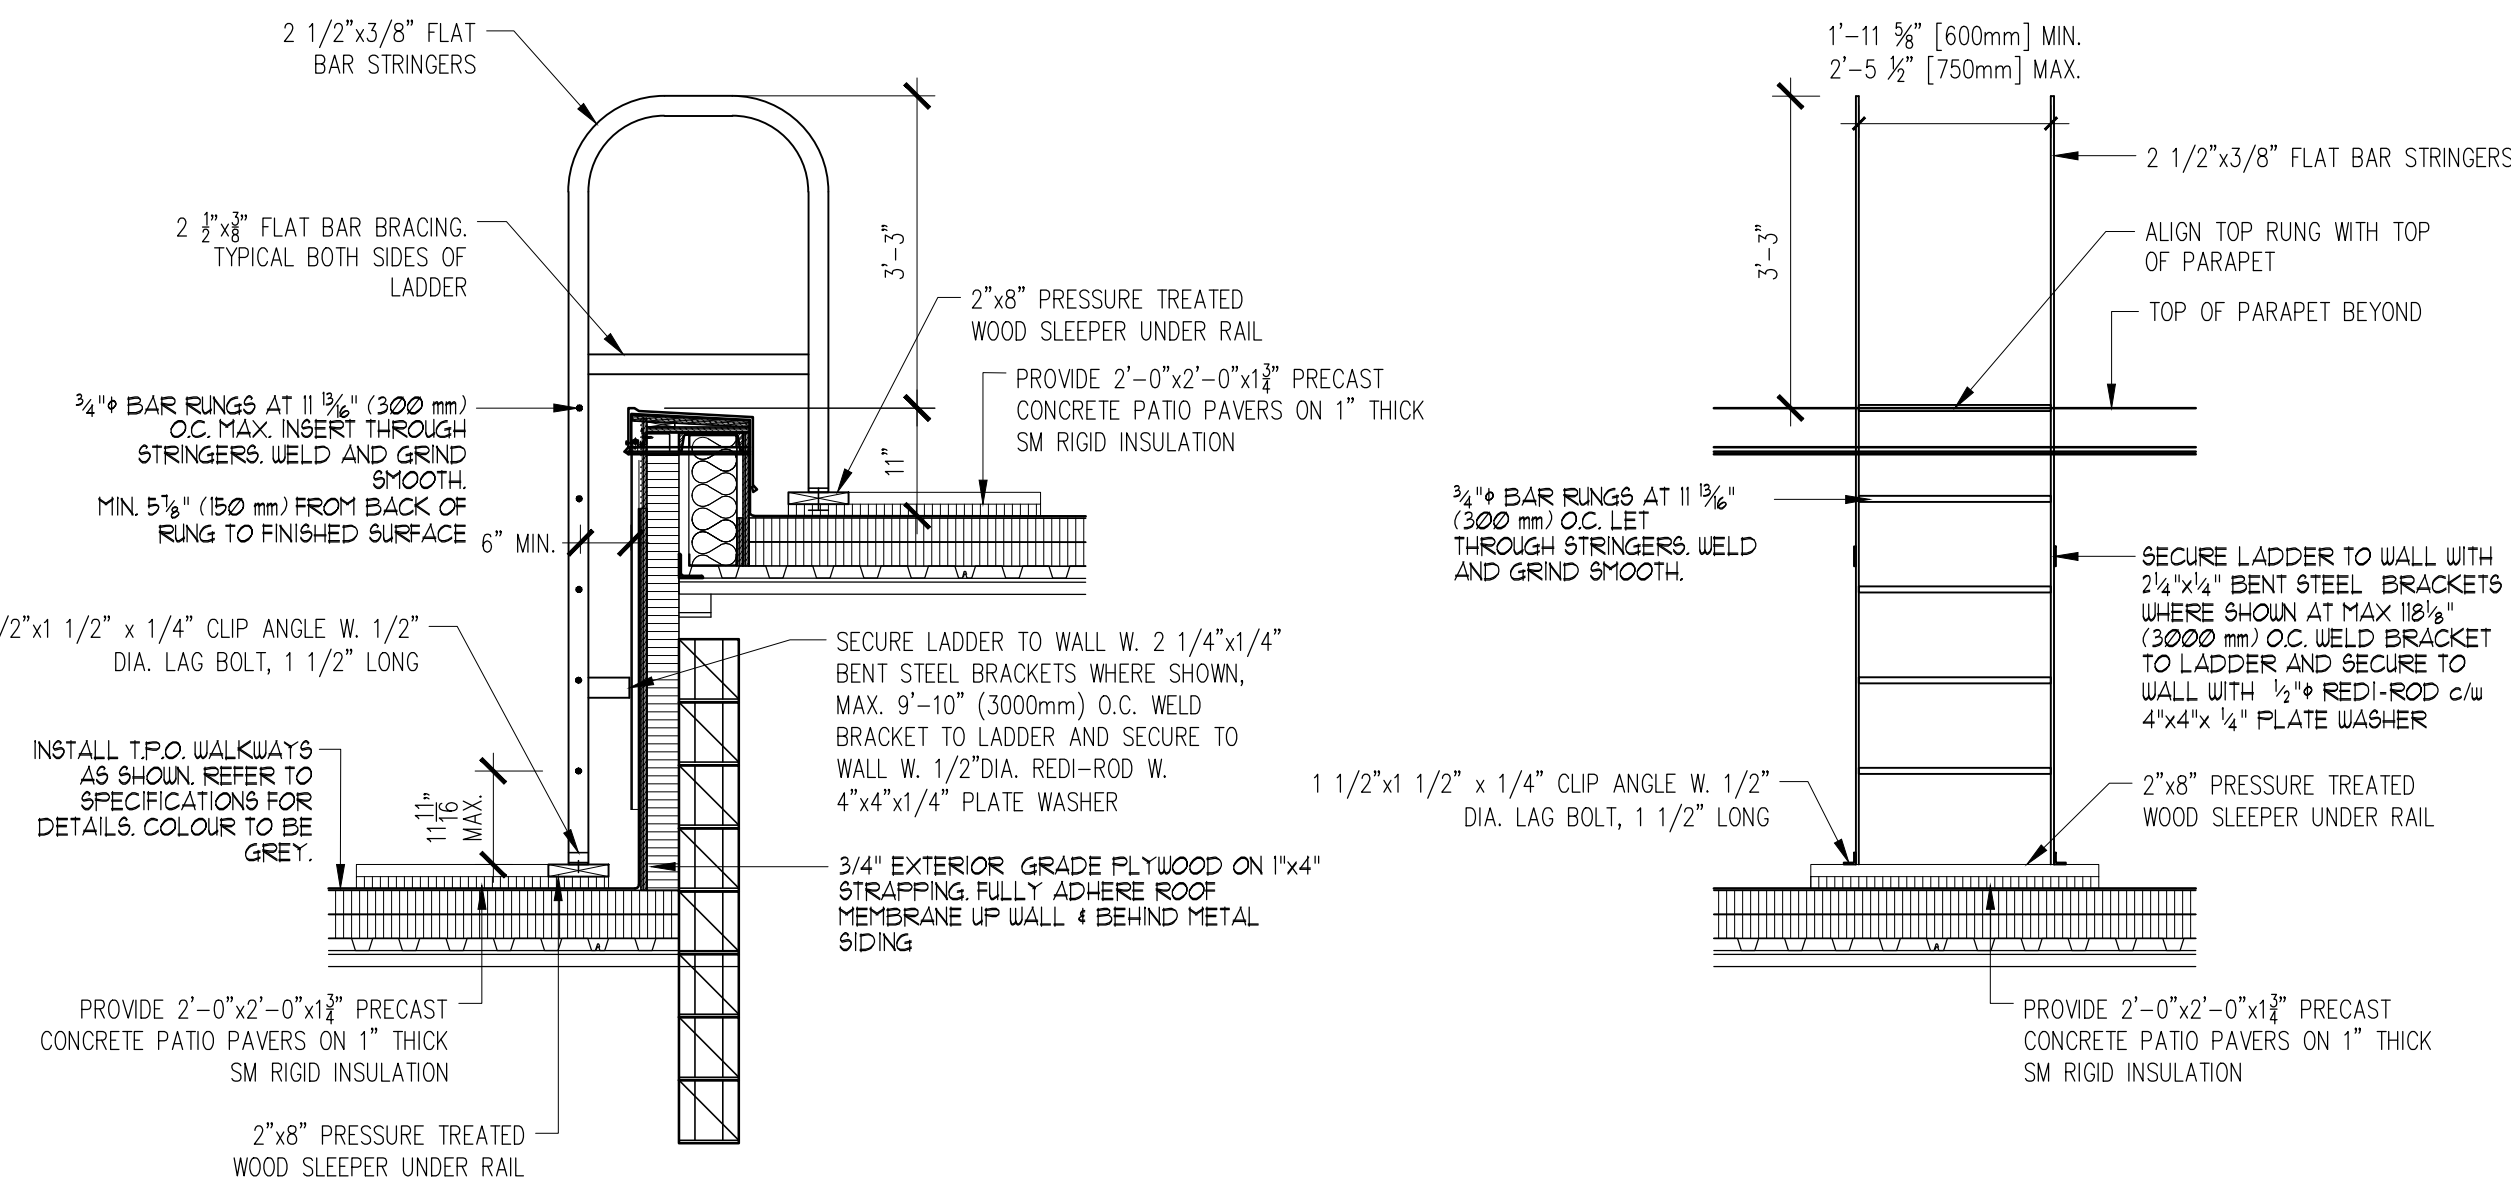

WALL SECTION

SCALE: 1/2" = 1'-0"

4

A5	A13
----	-----

WALL SECTION

SCALE: 1/2" = 1'-0"

—

A5	A13
----	-----

WALL SECTION

SCALE: 1/2" = 1'-0"

—

A5	A13
----	-----



ISSUED FOR PERMIT	FEB. 01/22	
ADDENDA #2	DEC. 15/21	2
ISSUED FOR TENDER	DEC. 01/21	-
revisions	date	no.

**CONTRACTORS MUST CHECK AND
VERIFY ALL DIMENSIONS AND REPORT
ANY DISCREPANCY TO THIS FIRM
BEFORE PROCEEDING WITH THE WORK**


A - detail no.

B - location sheet

C - detail sheet

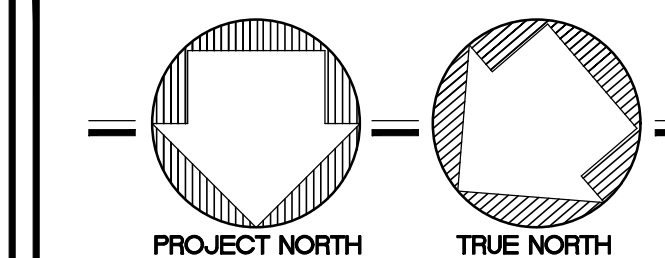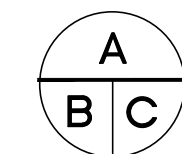

**SPRIET
ASSOCIATES**

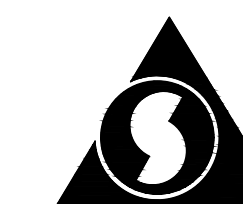

LIMITED
architects
LONDON LTD.
engineers

155 york street - london - N6A 1A8
phone : (519) 672-4100 fax : (519) 433-9351
e-mail : mail@spriet.on.ca

**LUCAN BIDDULPH
COMMUNITY
MEMORIAL CENTRE
PHASE 2 - LUCAN ARENA
RENO'S & ARENA ADDITION**
263 & 265 MAIN STREET, LUCAN, ONTARIO

drawing title :

SECTIONS

date : NOV 26, 202


scale : AS NOTED

drawn by : MTH


project no. :
216255-2

drawing no :


A13

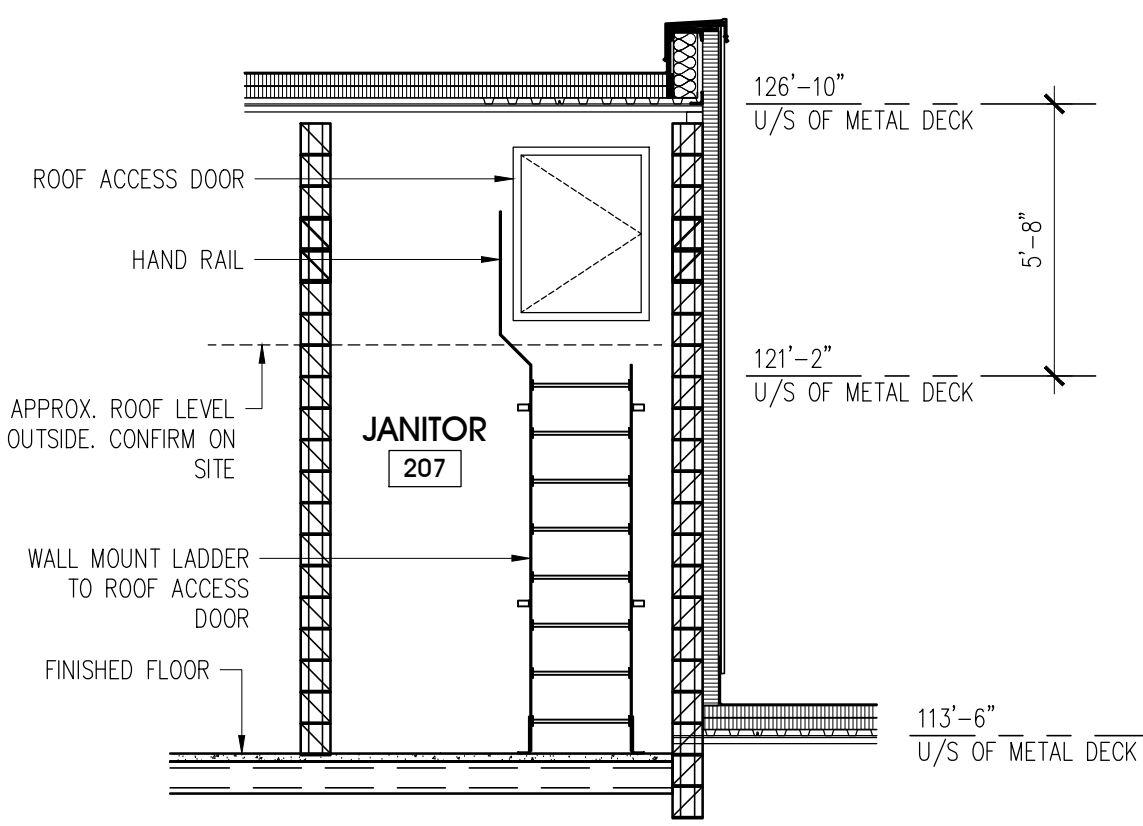


17 JANITOR (207) - ROOF ACCESS
A8 SCALE: 1/4" = 1'-0"

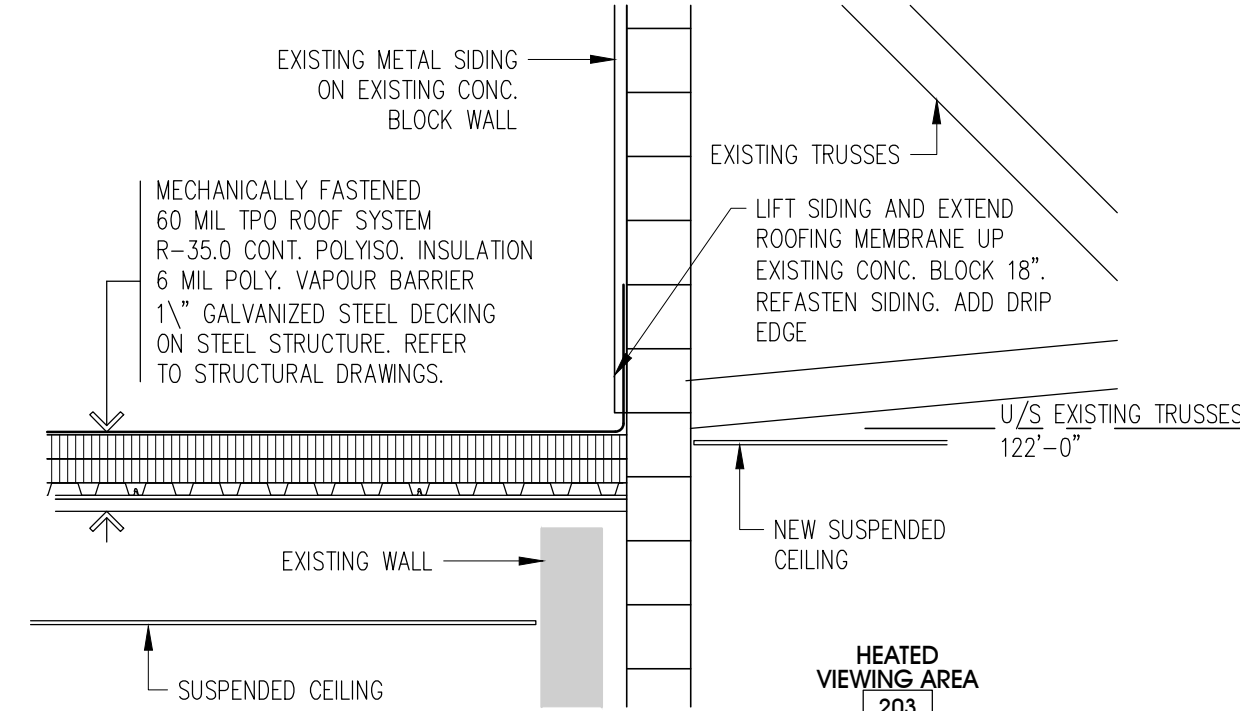


DETAIL D3
SCALE: 1/2" = 1'-0" A11 A14

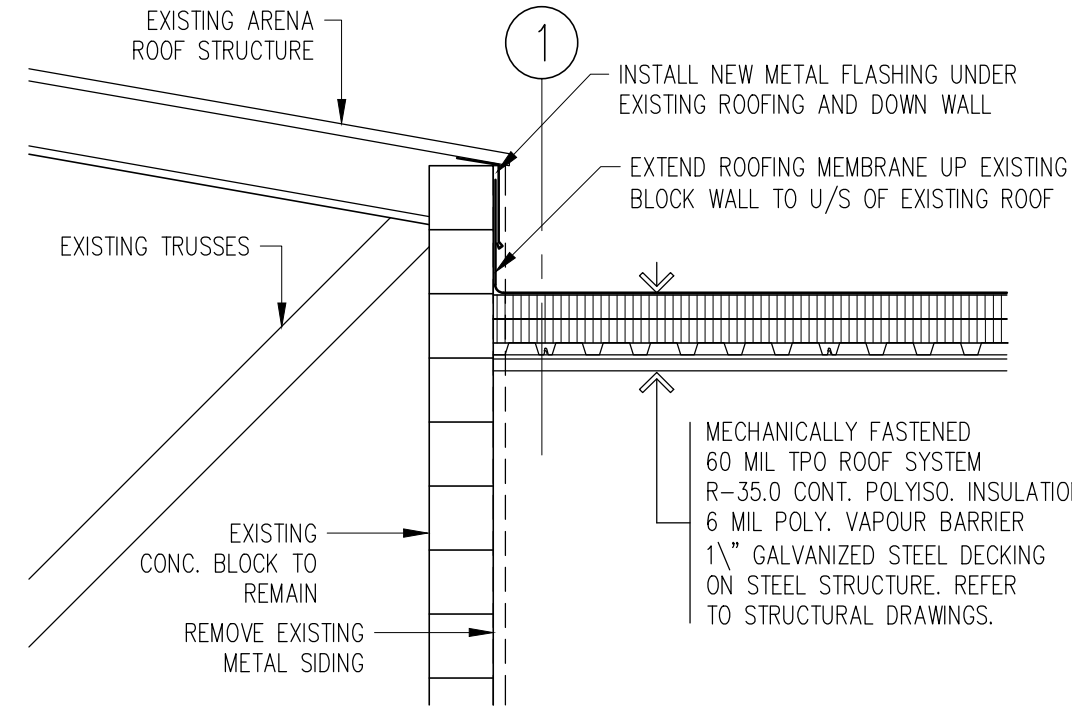

DETAIL D4
SCALE: 1/2" = 1'-0" A11 A14


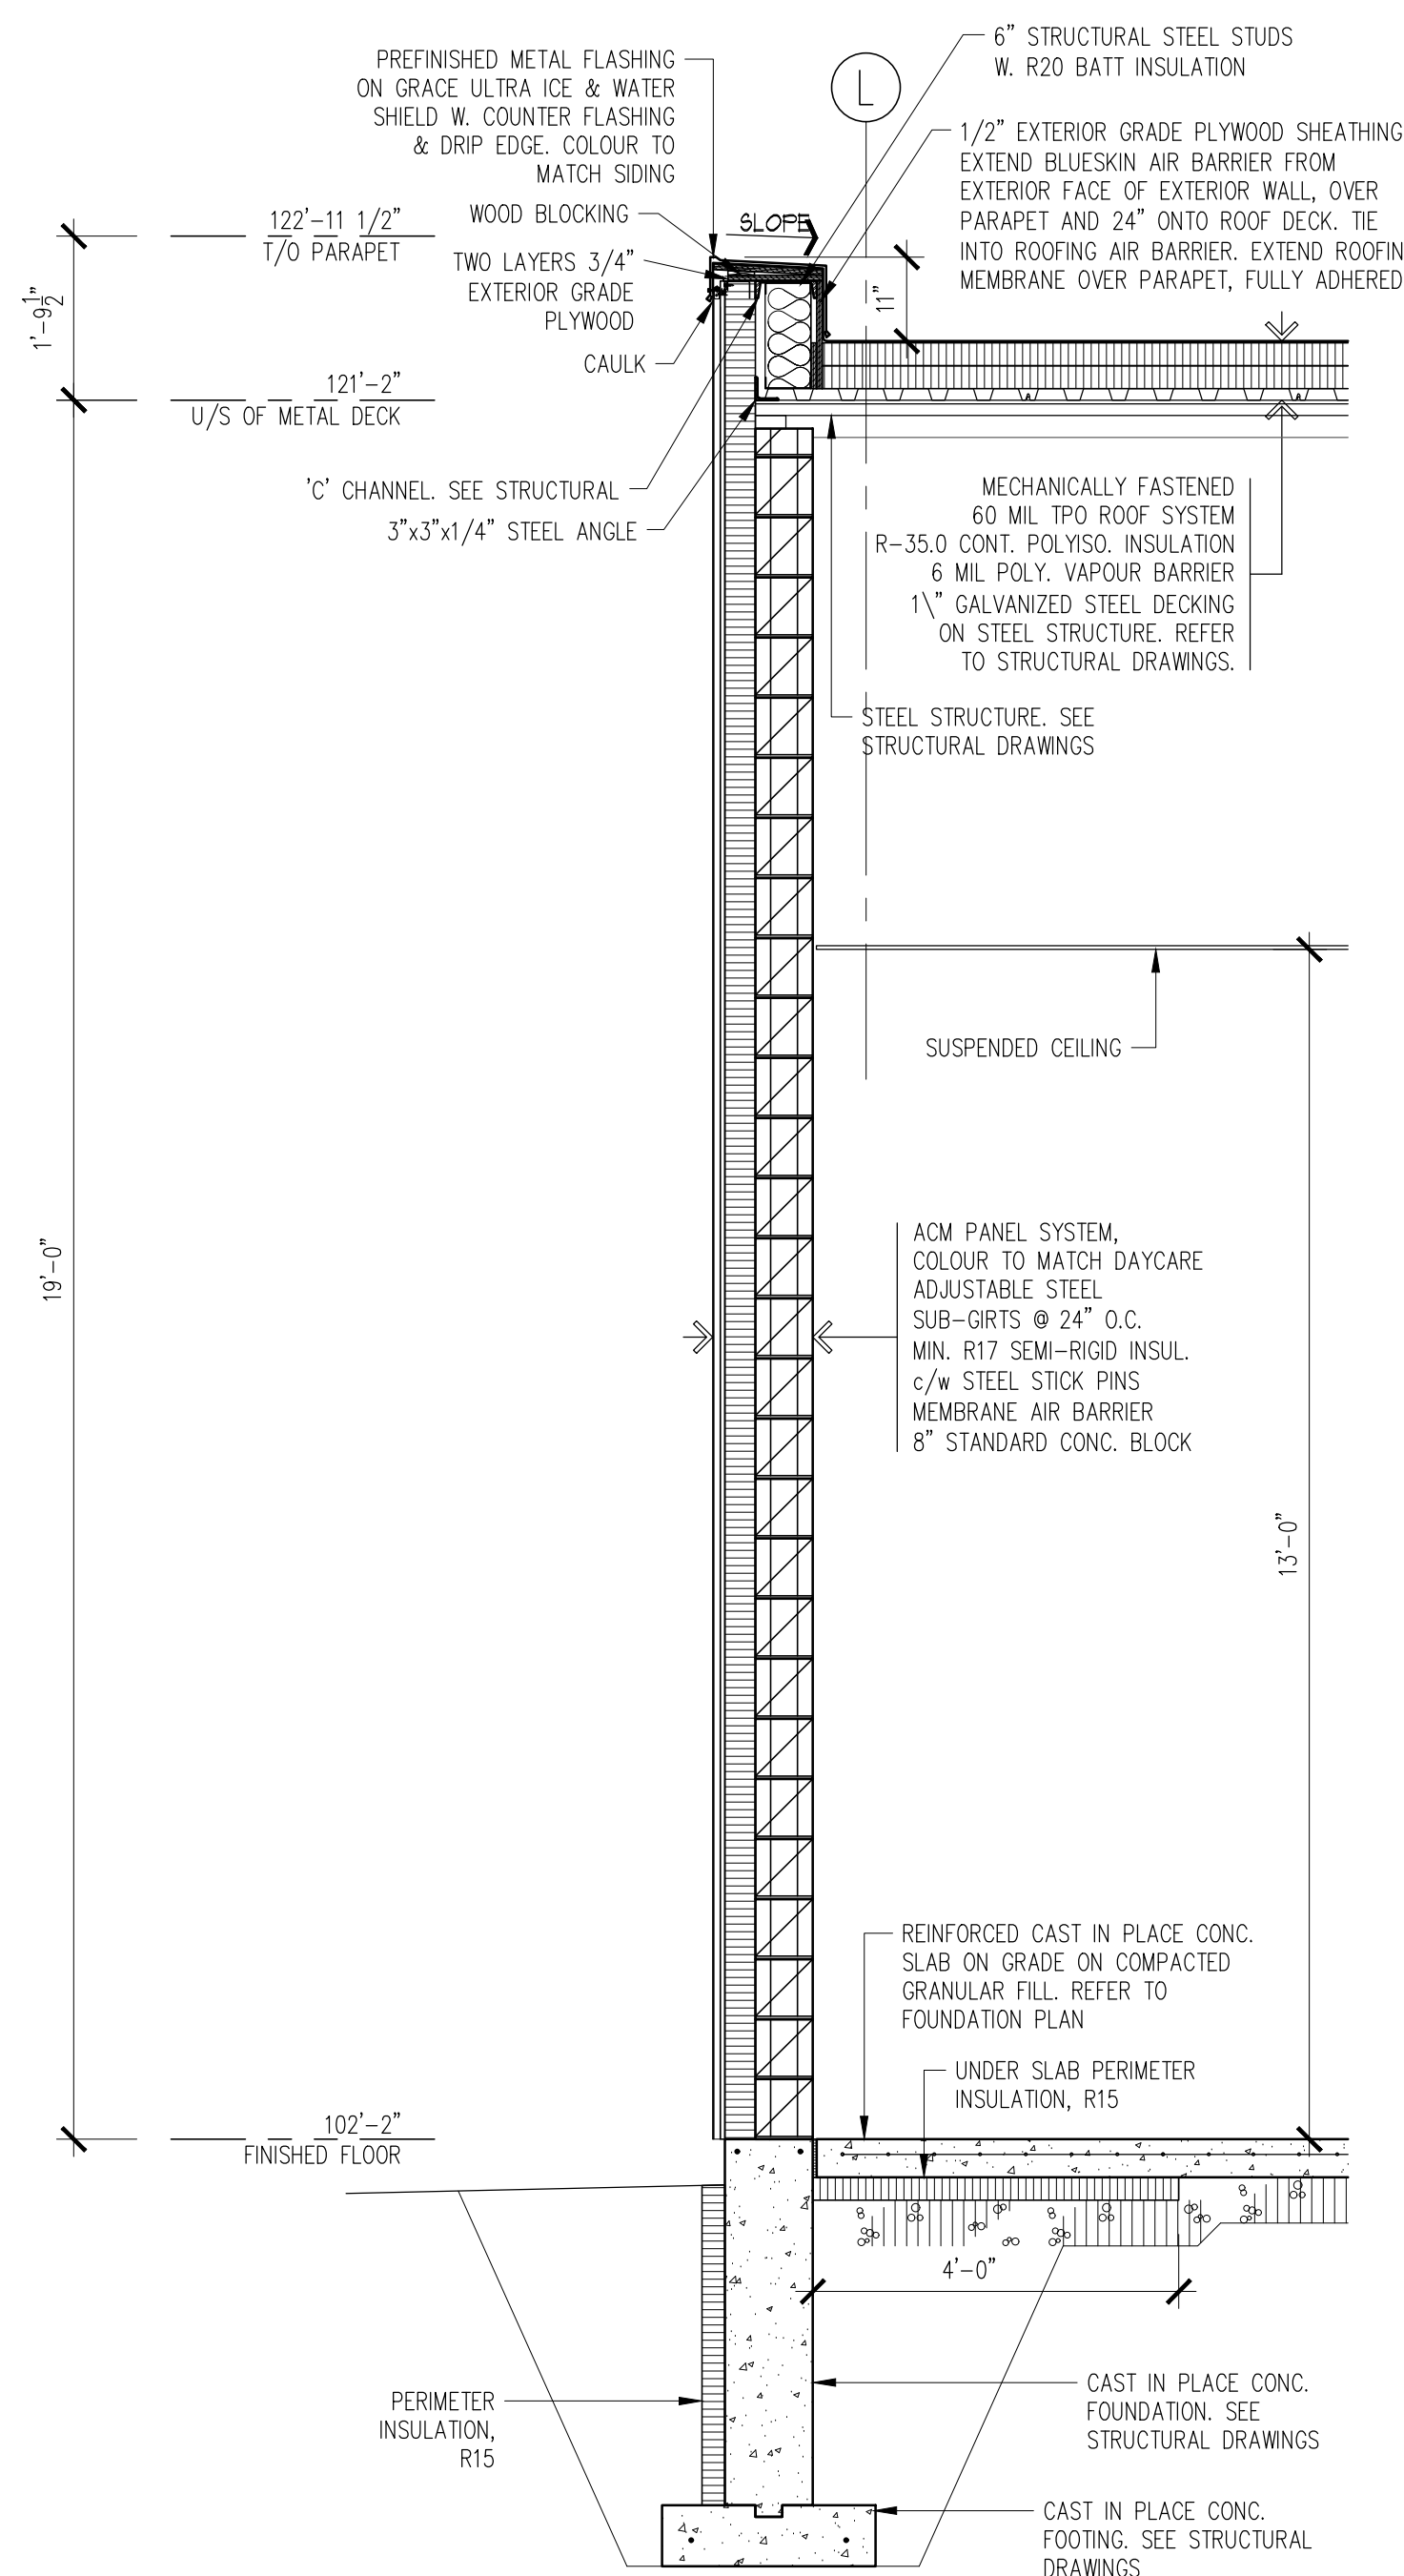


WALL SECTION 7
SCALE: 1/2" = 1'-0" A5 A14

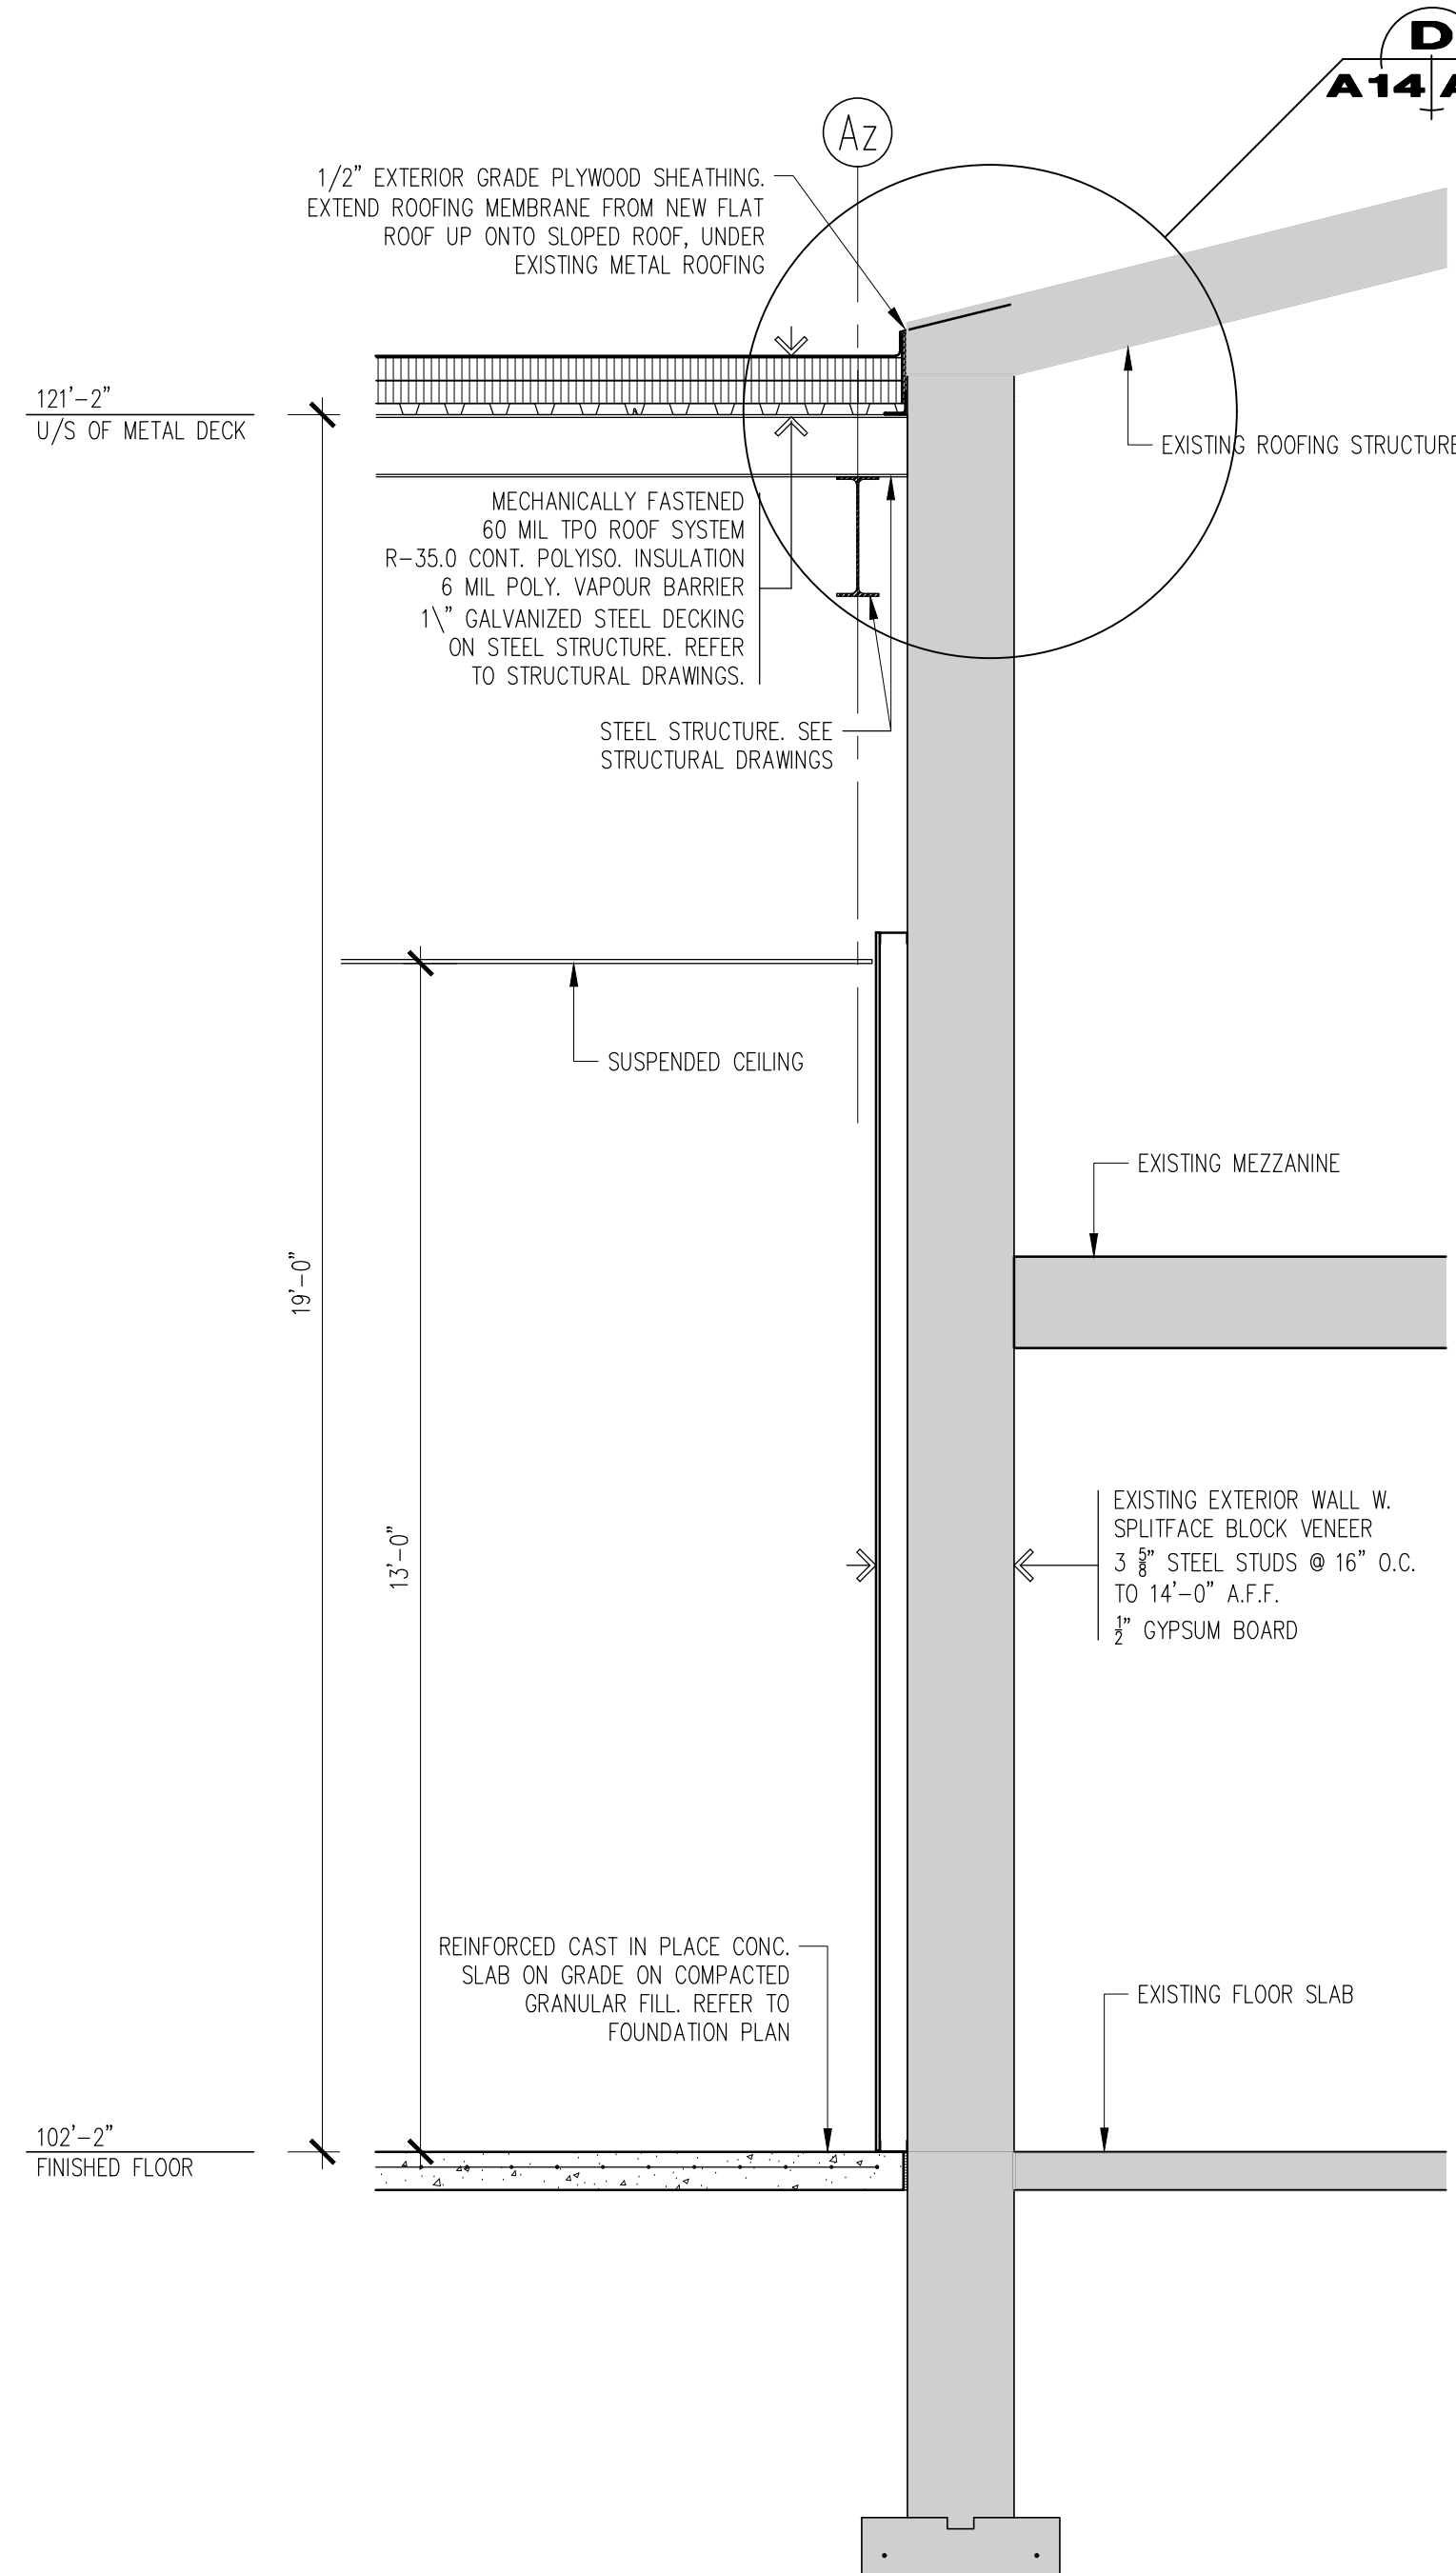

WALL SECTION 8
SCALE: 1/2" = 1'-0" A5 A14

NOTES:
1. HANDRAILS AND THEIR SUPPORT WILL WITHSTAND THE LOADING VALUES OBTAINED FROM THE NONCONCURRENT APPLICATION OF A CONCENTRATED LOAD NOT LESS THAN 0.9 kN APPLIED AT ANY POINT AND IN ANY DIRECTION FOR ALL HANDRAILS AND A UNIFORM LOAD NOT LESS THAN 0.1 kN/m APPLIED IN ANY DIRECTION TO THE HANDRAIL.

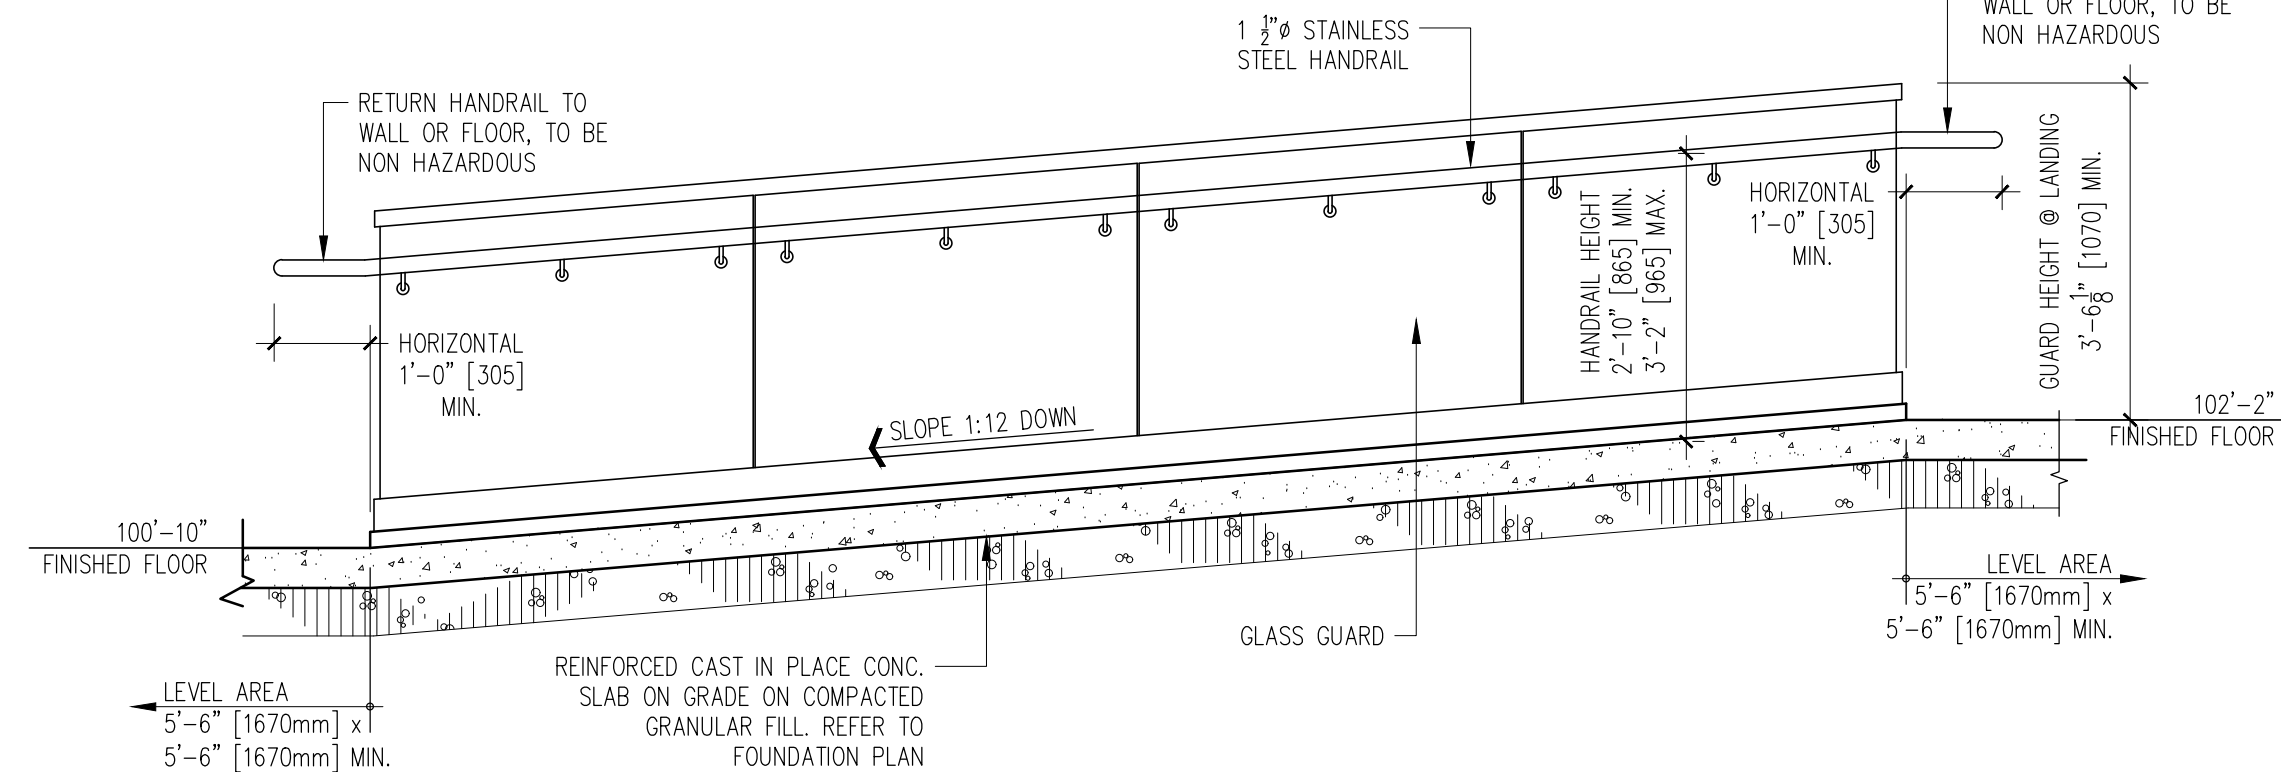
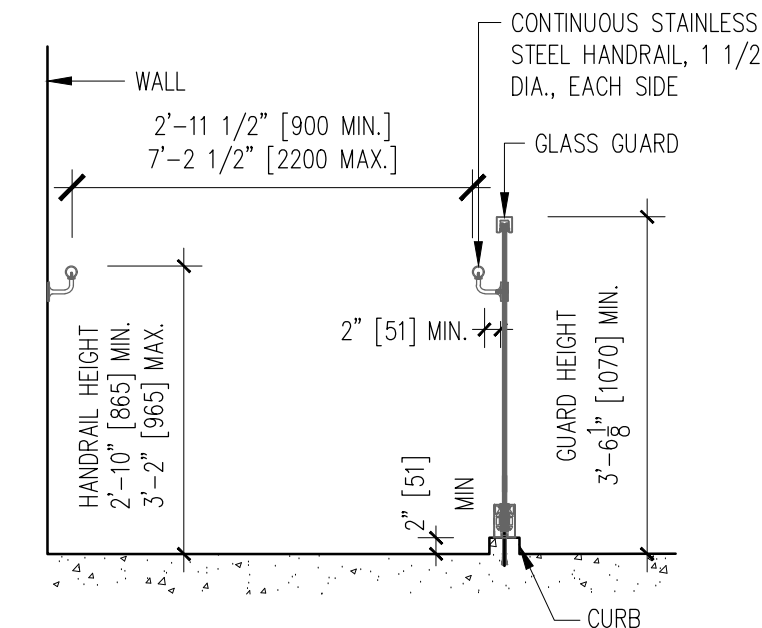



RAMP SECTION 9
SCALE: 1/2" = 1'-0" A2 A14

ISSUED FOR PERMIT	FEB. 01/22	
ISSUED FOR TENDER	DEC. 01/21	△
revisions	date	no.

CONTRACTORS MUST CHECK AND VERIFY ALL DIMENSIONS AND REPORT ANY DISCREPANCY TO THIS FIRM BEFORE PROCEEDING WITH THE WORK


A - detail no.
B - location sheet
C - detail sheet

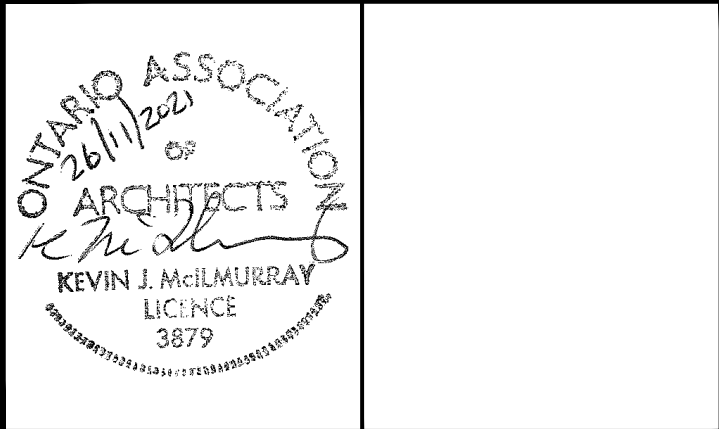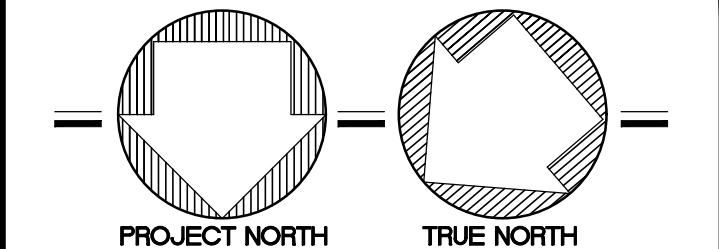

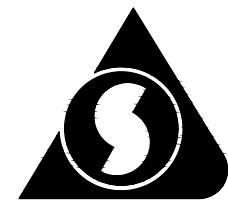
SPRIET ASSOCIATES

LIMITED architects LONDON LTD. engineers
155 york street - london - N6A 1A8
phone : (519) 672-4100 fax : (519) 433-9351
e-mail : mail@spriet.on.ca

LUCAN BIDDULPH COMMUNITY MEMORIAL CENTRE
PHASE 2 - LUCAN ARENA
RENO'S & ARENA ADDITION
263 & 265 MAIN STREET, LUCAN, ONTARIO

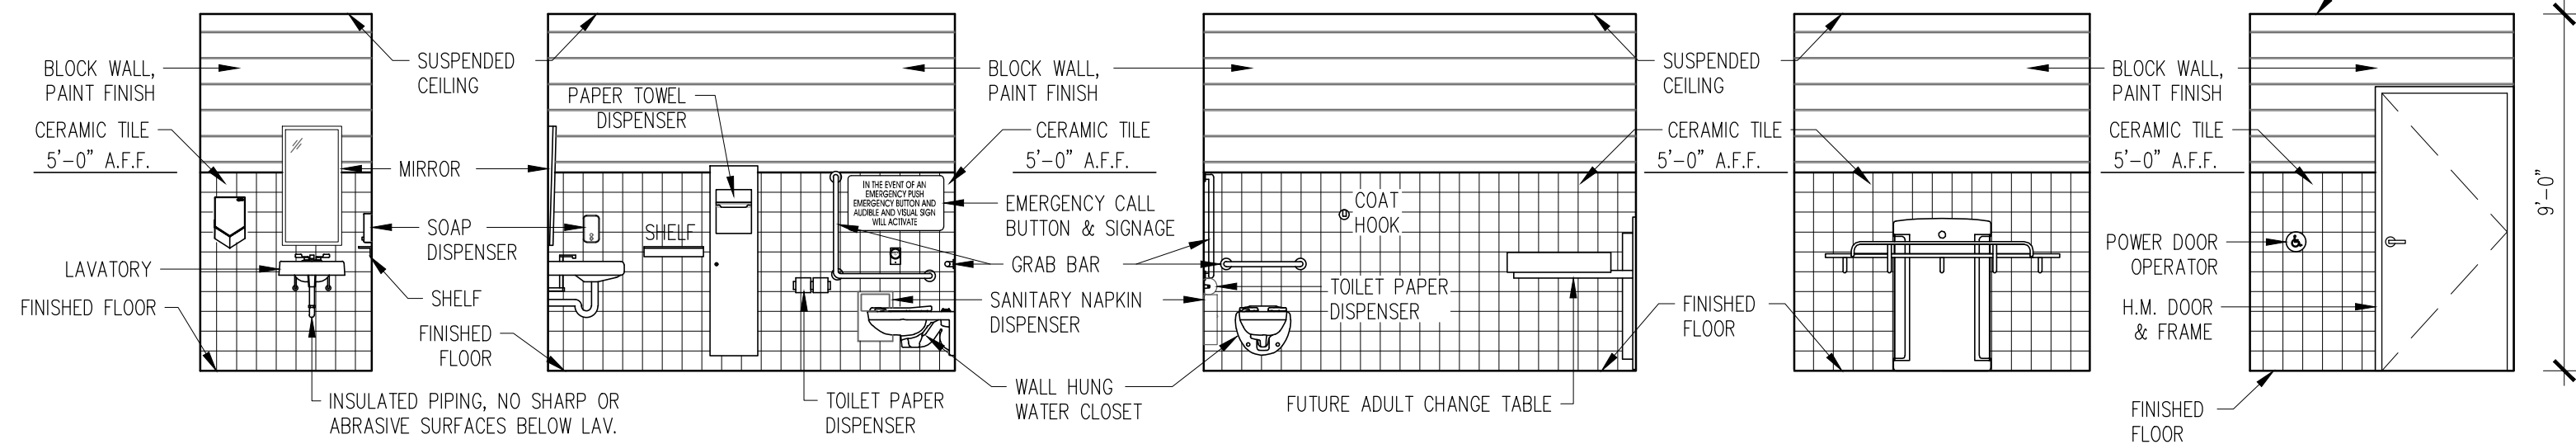
drawing title : WALL SECTIONS		
date : NOV 26, 2021	drawing no. :	
scale : AS NOTED	A14	
drawn by : MTH		
project no. : 216255-2		

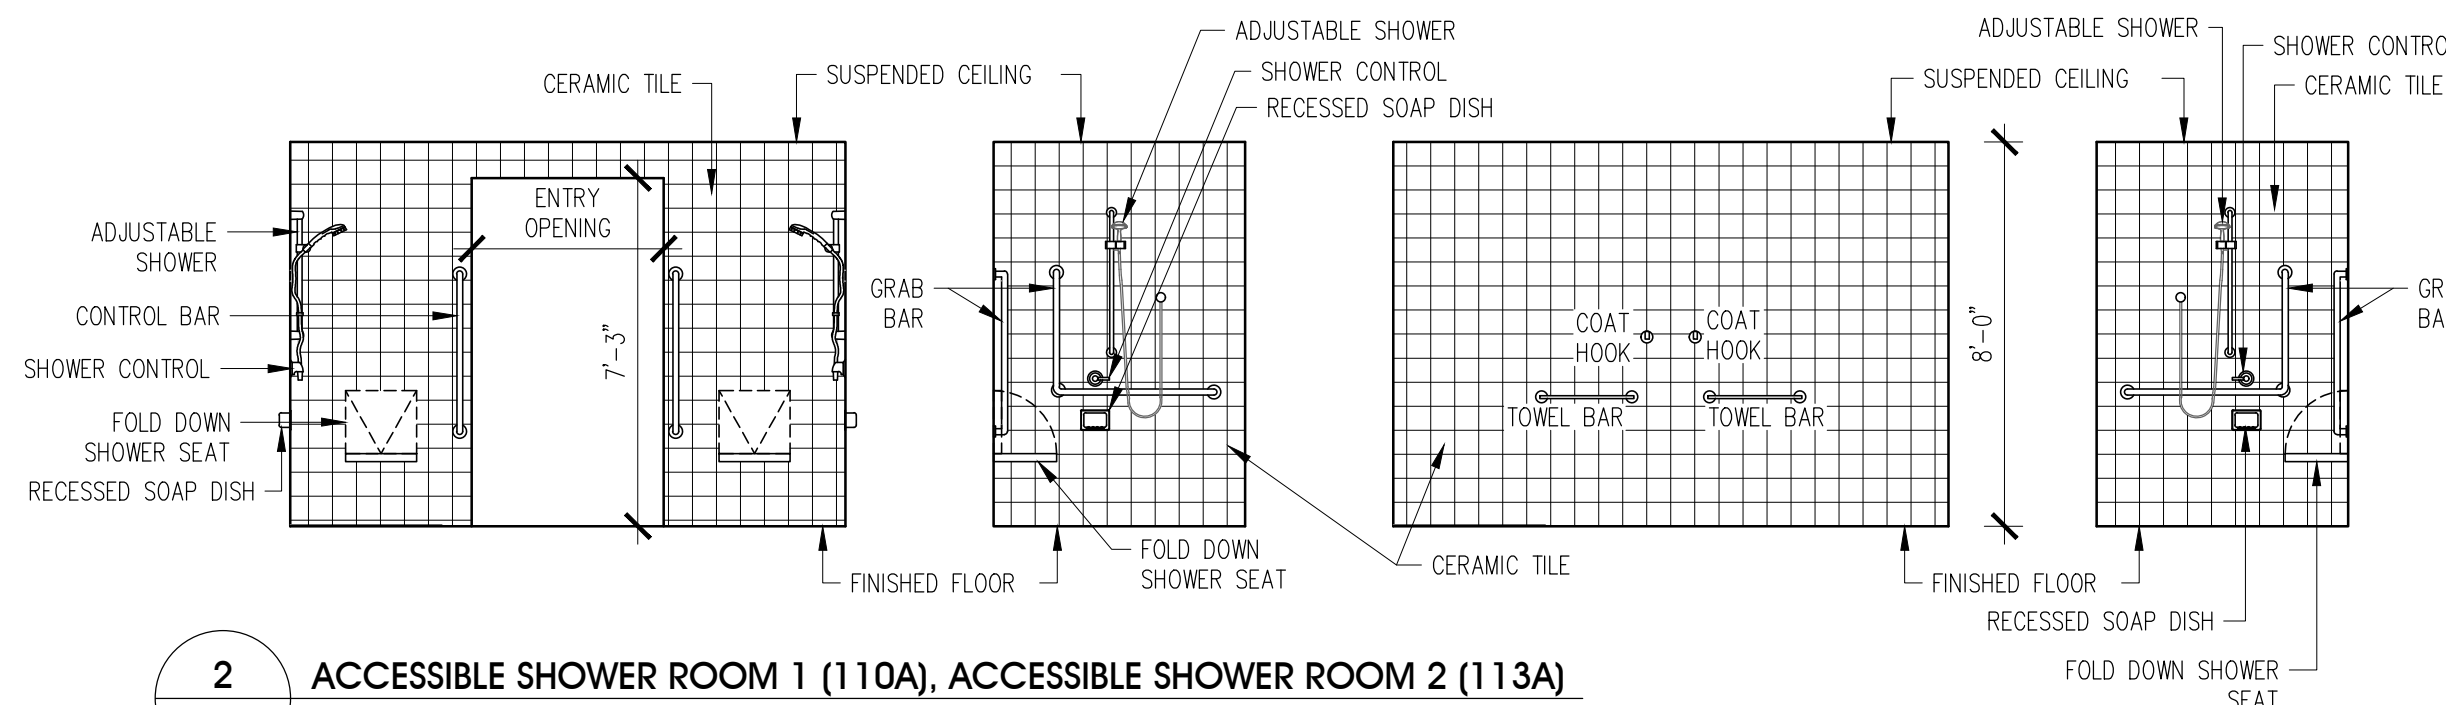


1
A5 **UNIVERSAL WASHROOM (106)**
SCALE: 1/4" = 1'-0"







2
A6 **ACCESSIBLE SHOWER ROOM 1 (110A), ACCESSIBLE SHOWER ROOM 2 (113A)**
SCALE: 1/4" = 1'-0"

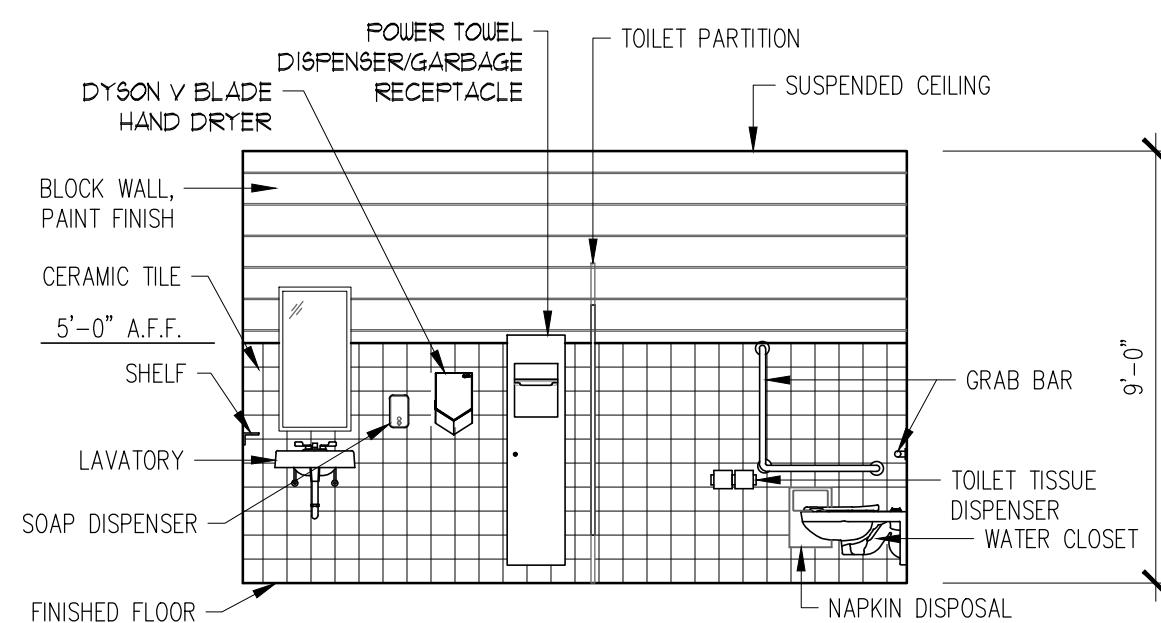




3
A6 **ACCESSIBLE WASHROOM 1 (110)**
ACCESSIBLE WASHROOM 2 (113, REVERSED)
SCALE: 1/4" = 1'-0"

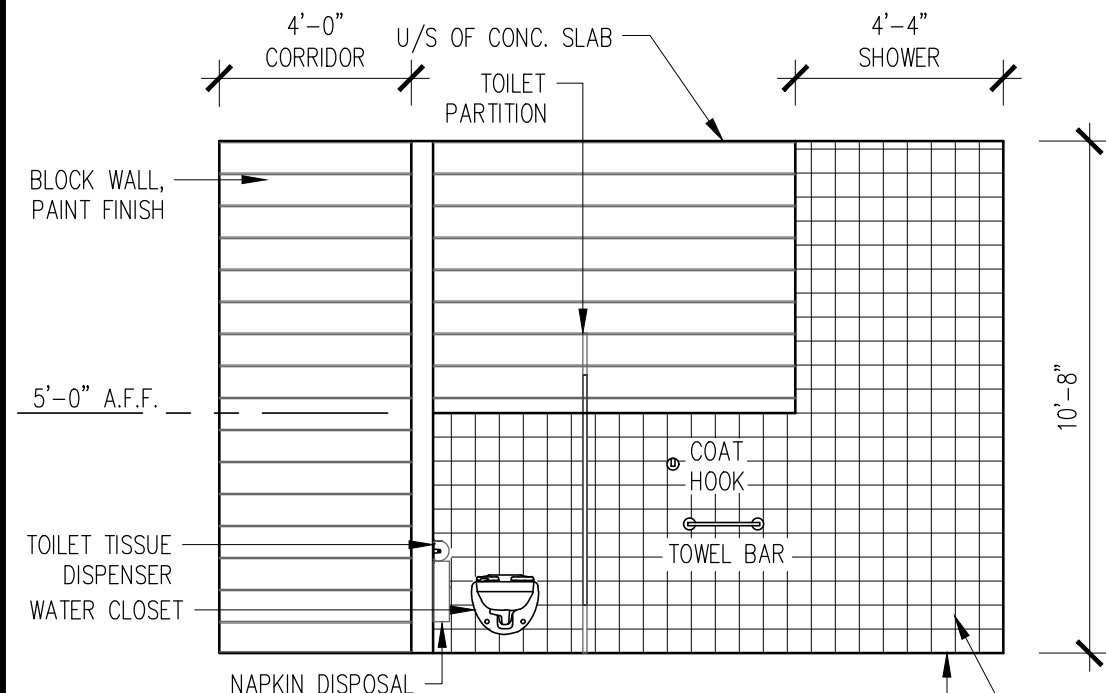

 
4
A7 **REFEREE CHANGE ROOM (116)**
SCALE: 1/4" = 1'-0"

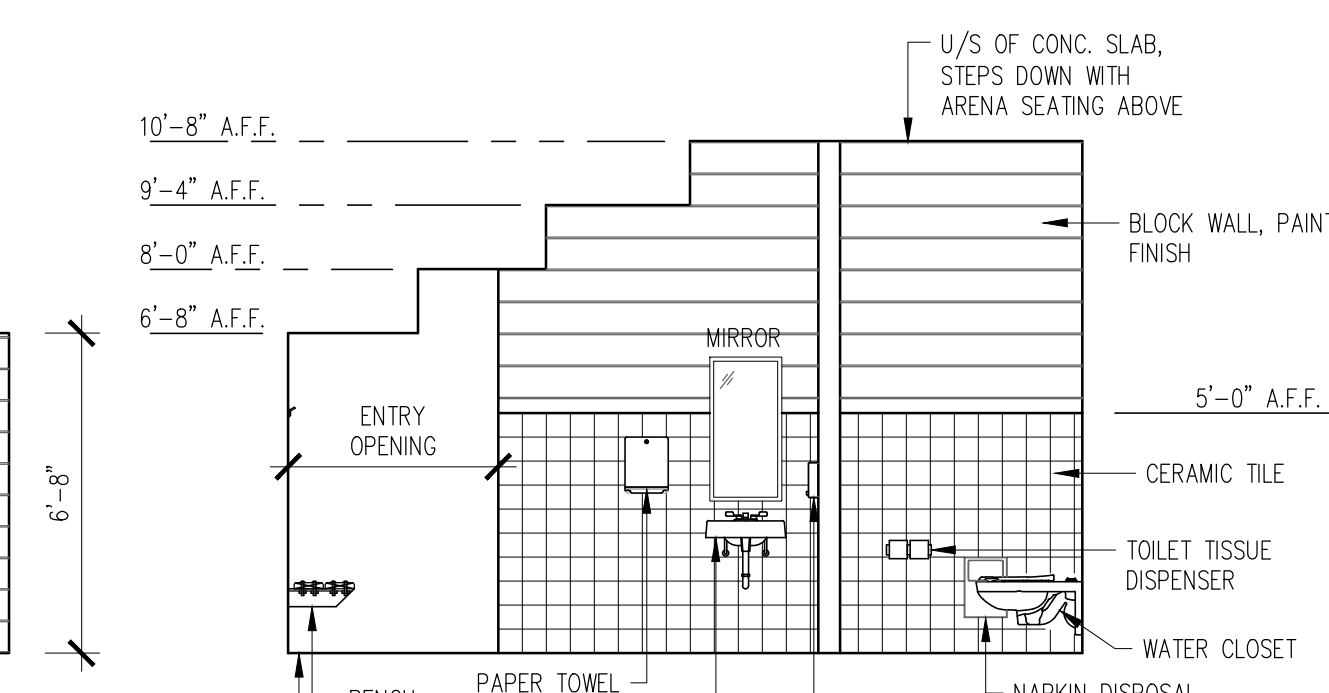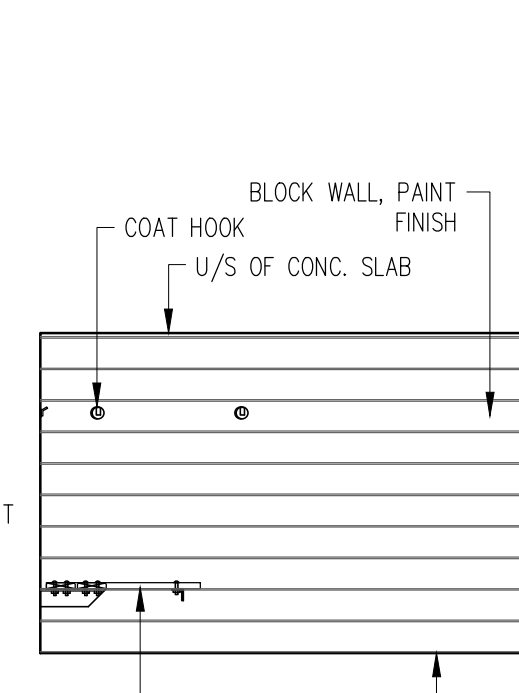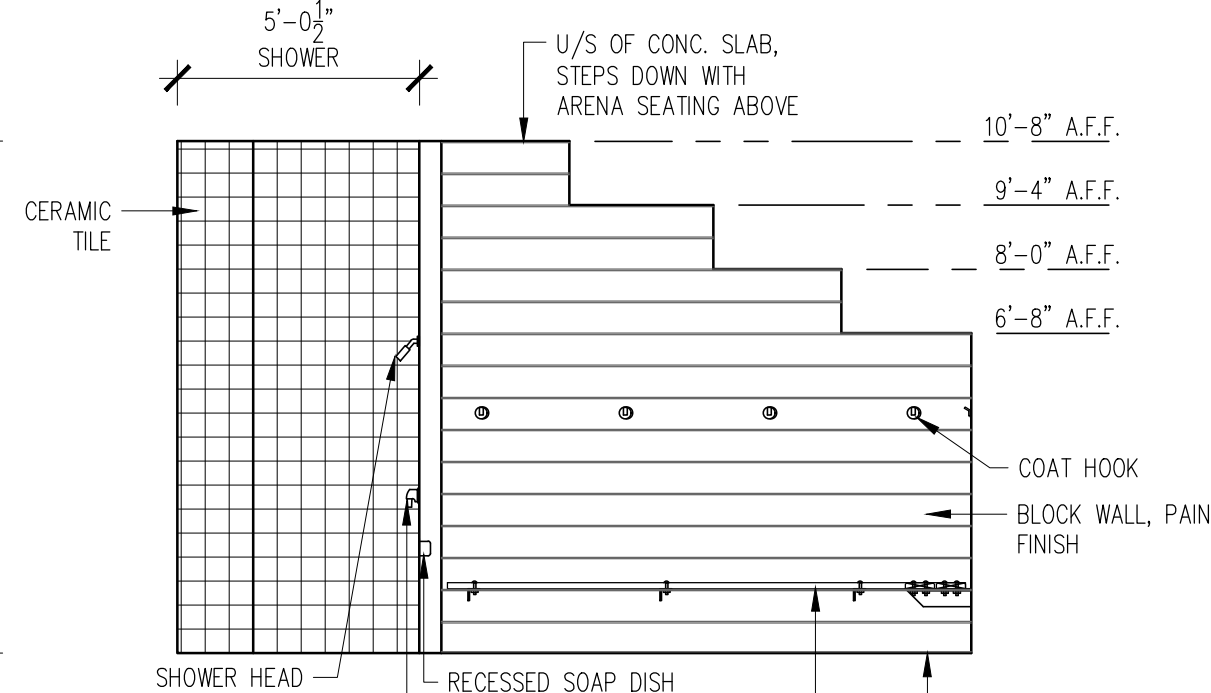


A - detail no.
B - location sheet
C - detail sheet

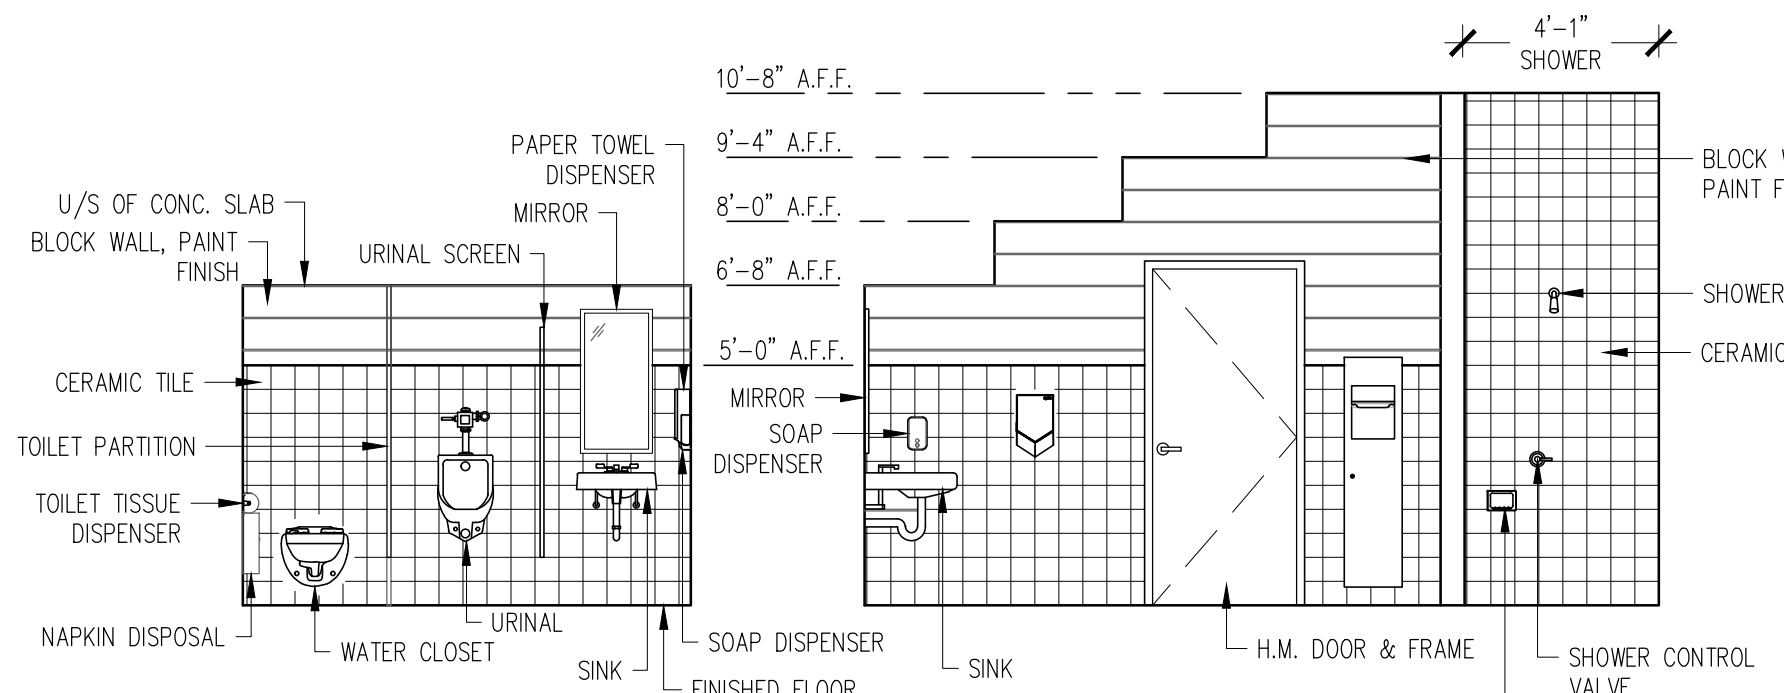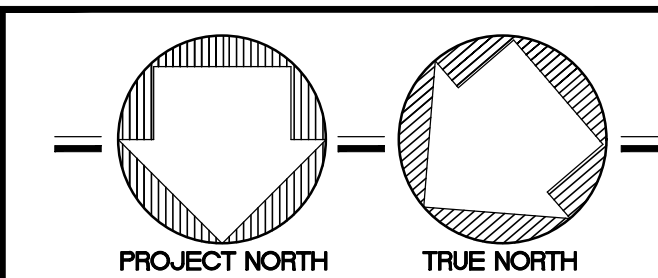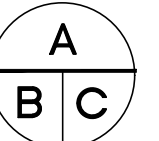


5
A7 **WASHROOM 3 (119)**
SCALE: 1/4" = 1'-0"

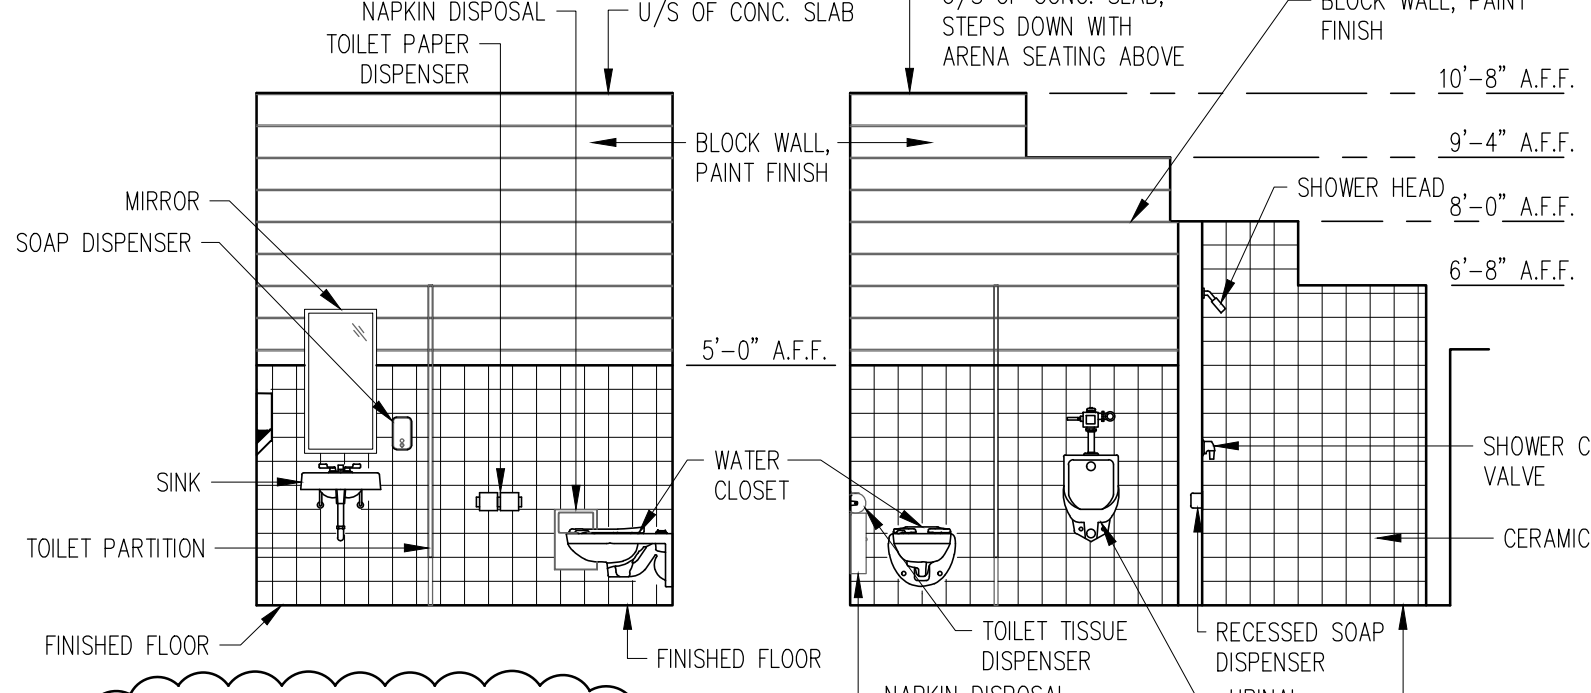


6
A6 **SHOWER ROOM (123)**
SHOWER ROOM (125A)
SCALE: 1/4" = 1'-0"

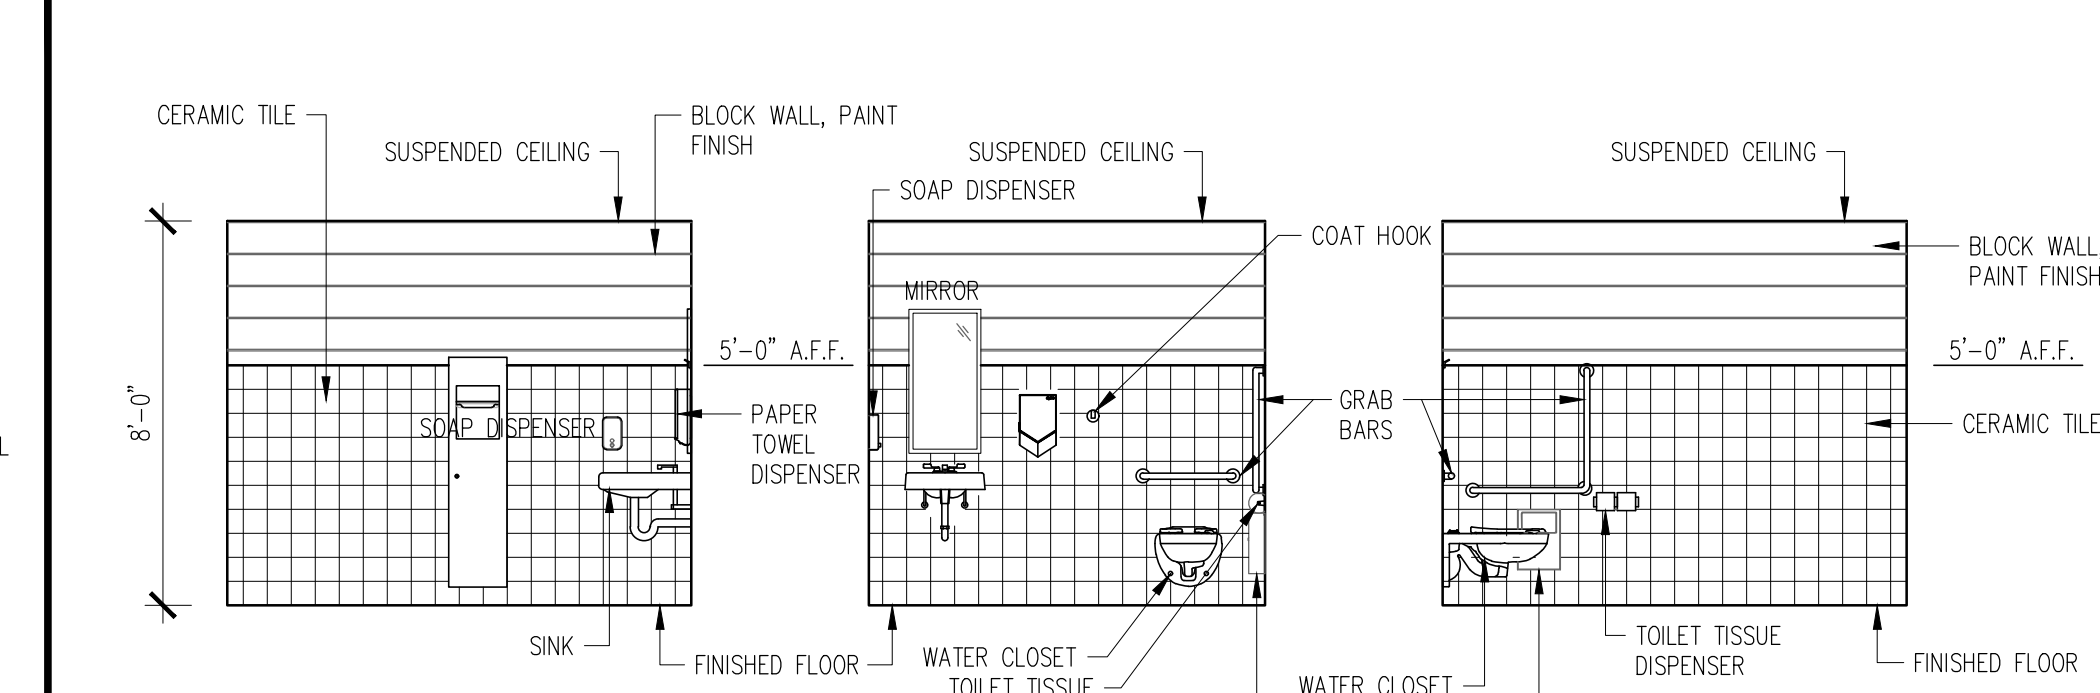


7
A7 **B.F. WASHROOM (132)**
SCALE: 1/4" = 1'-0"

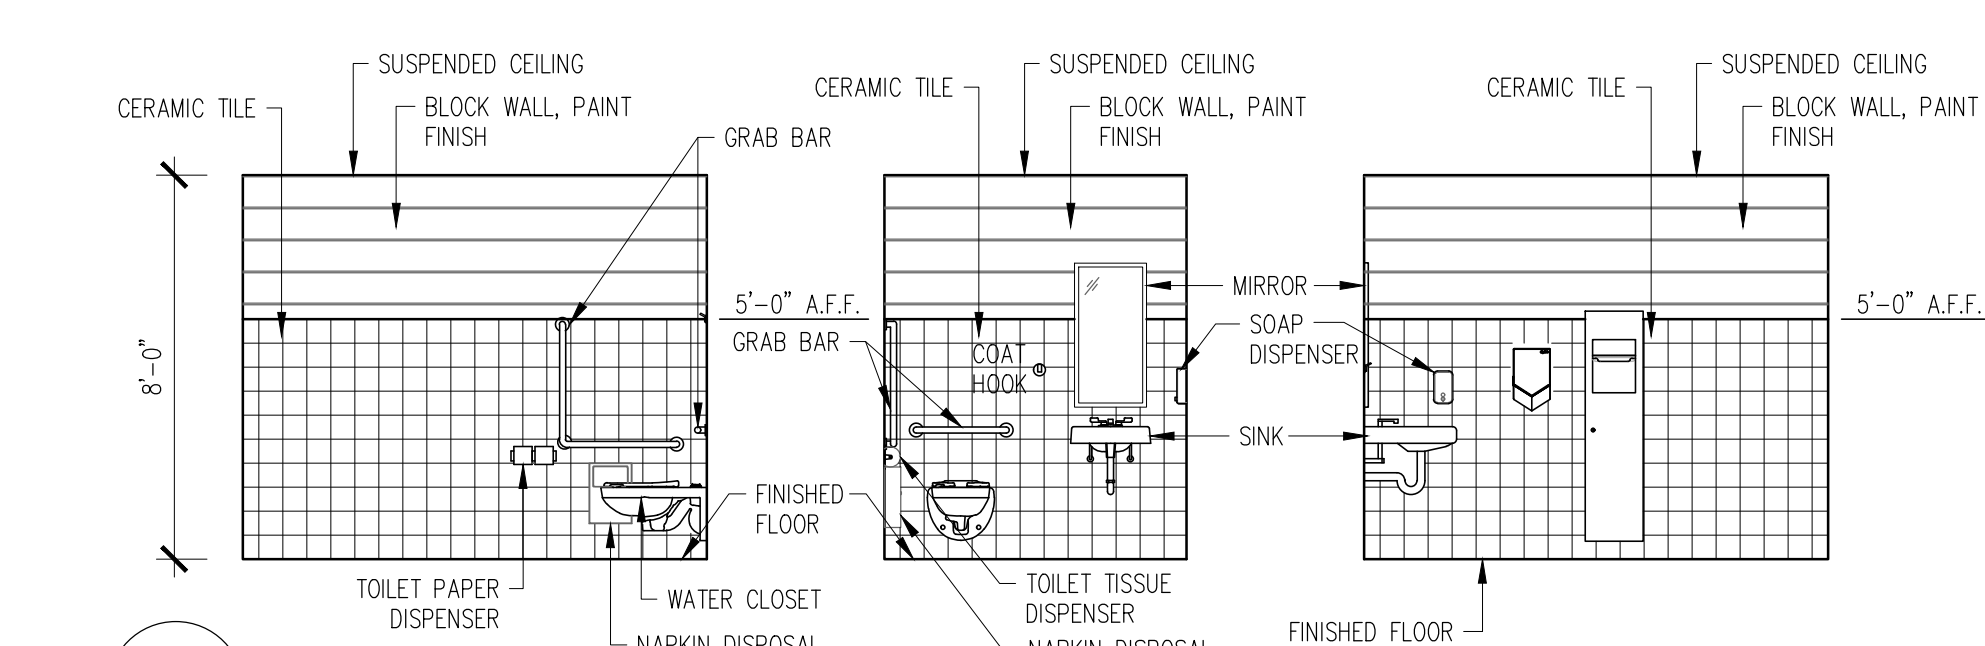

8
A7 **WASHROOM (133)**
SCALE: 1/4" = 1'-0"

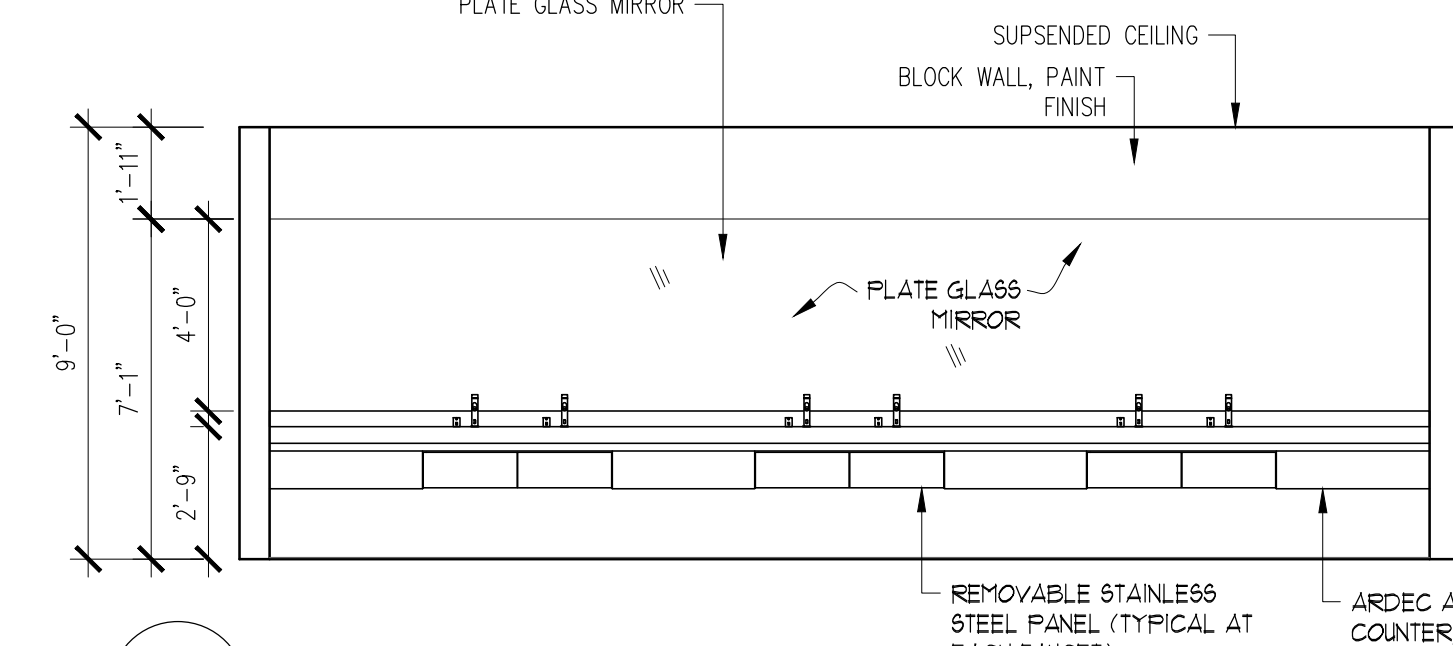


9
A6 **WASHROOM ELEVATION (135) & (136)**
SCALE: 1/4" = 1'-0"


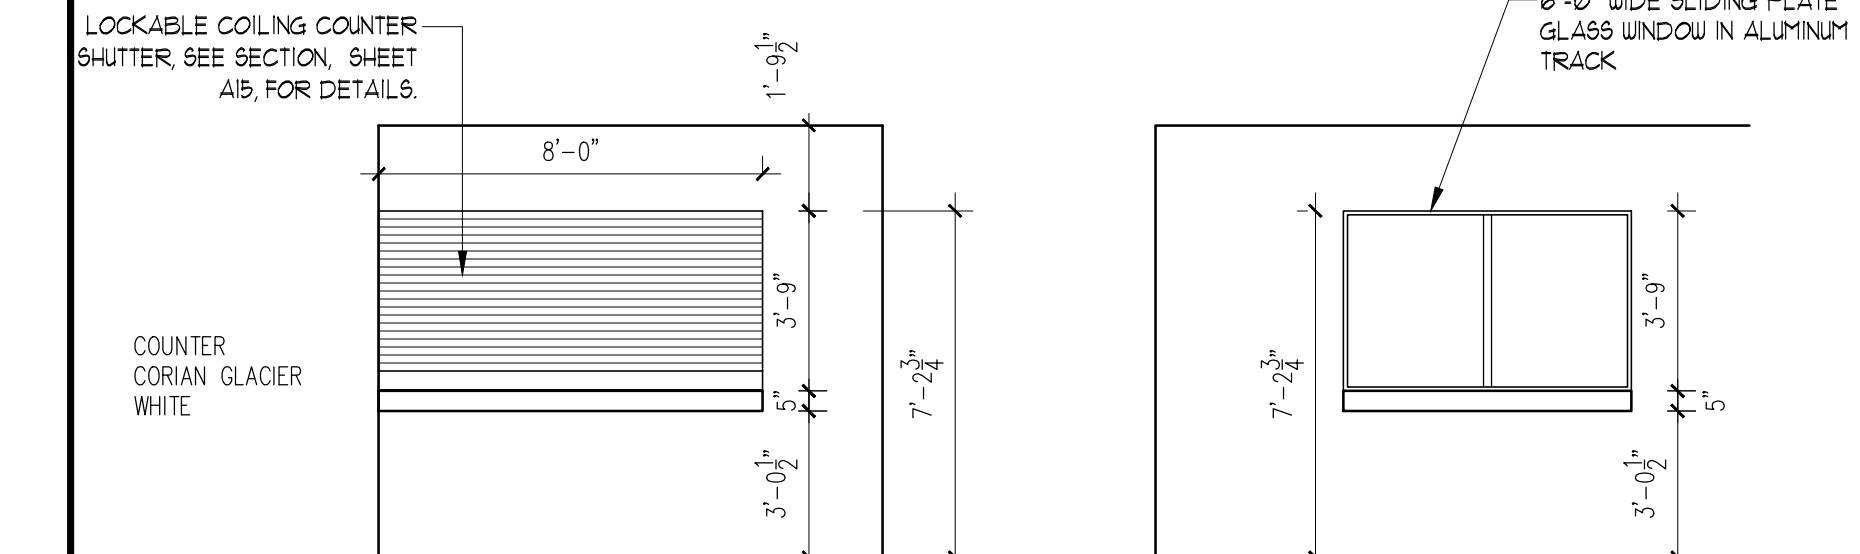


10A
A7 **CONCESSION (128)**
SCALE: 1/4" = 1'-0"

10B
A7 **CONCESSION (128)**
SCALE: 1/4" = 1'-0"

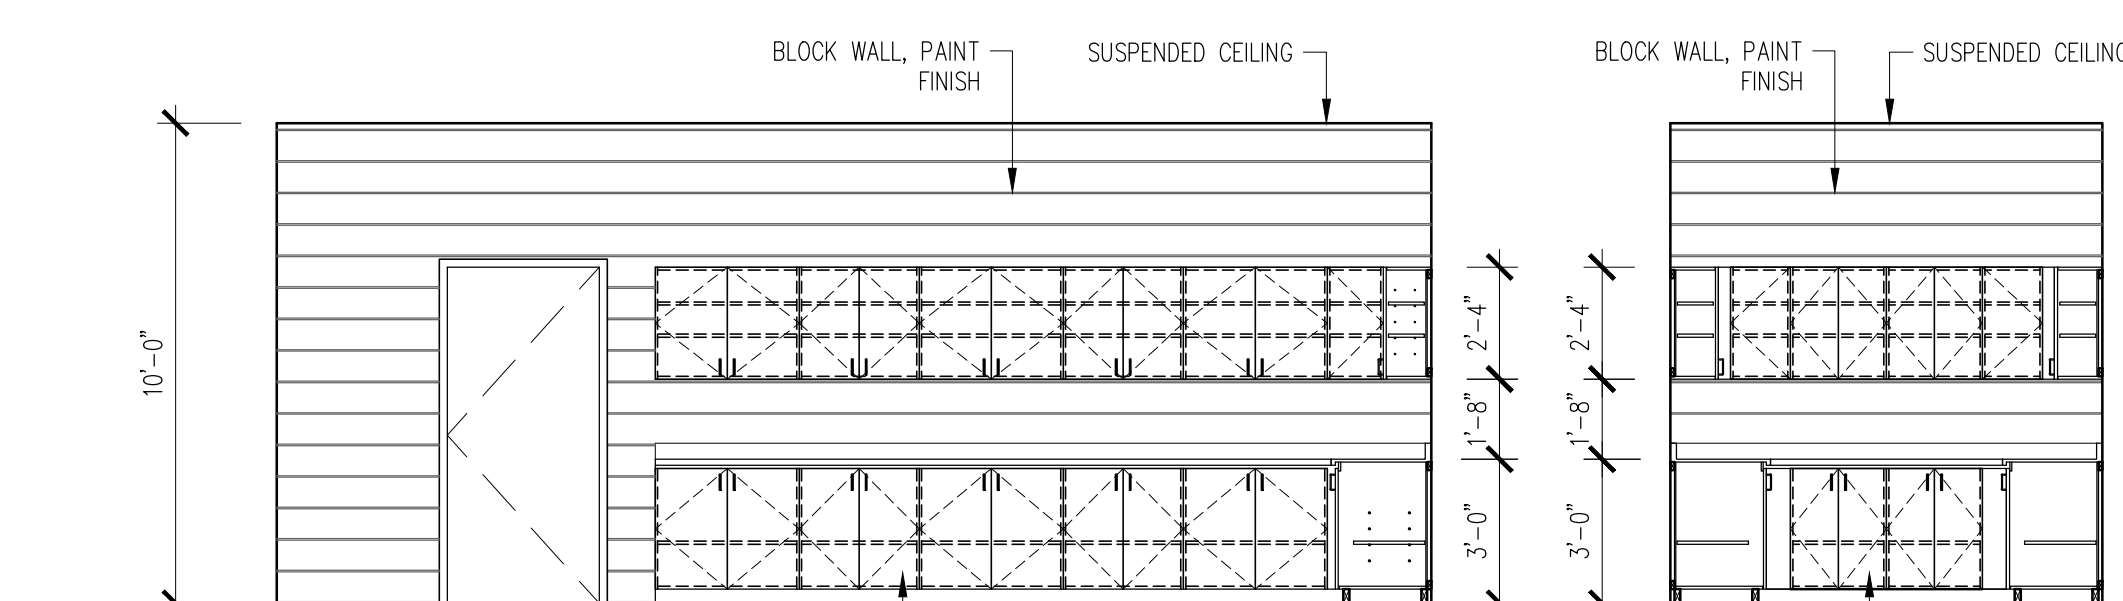

11
A7 **KITCHEN EXTENSION (140)**
SCALE: 1/4" = 1'-0"

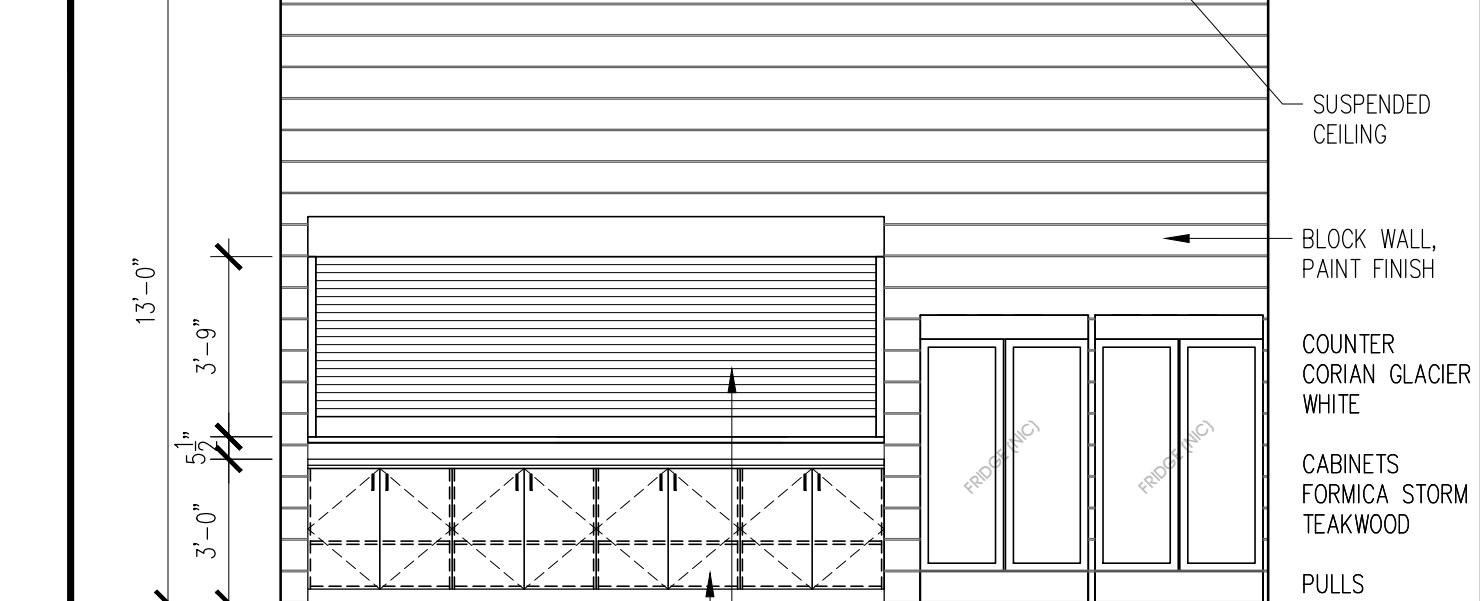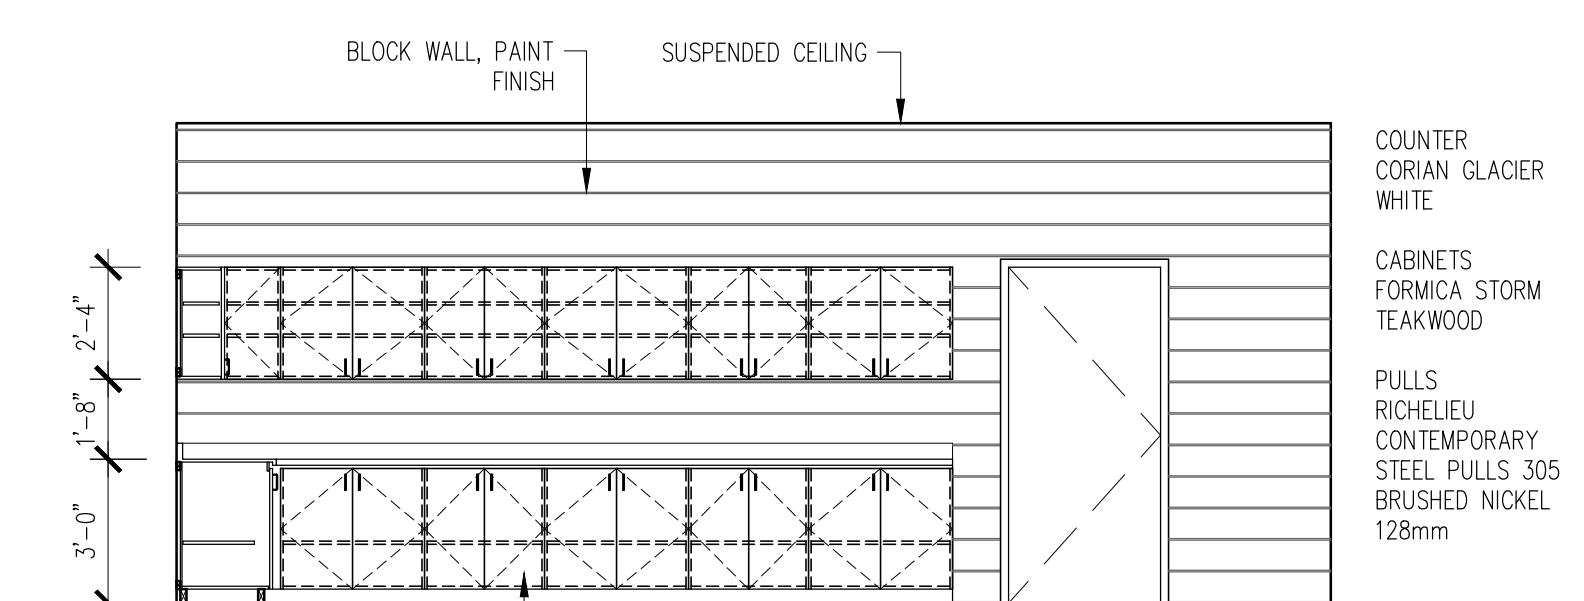



12
A7 **BAR (141)**
SCALE: 1/4" = 1'-0"

REFERENCE
SHEET A15 FOR
MOUNTING
HEIGHTS,
STANDARD
SECTIONS &
REQUIRED
BARRIER FREE
STANDARDS

LUCAN BIDDULPH
COMMUNITY
MEMORIAL CENTRE
PHASE 2 - LUCAN ARENA
RENO'S & ARENA ADDITION
263 & 265 MAIN STREET, LUCAN, ONTARIO


drawing title :
INTERIOR
ELEVATIONS
date : NOV 26, 2021
scale : AS NOTED
drawn by : MTH
project no. : 216255-2
drawing no. :
A16

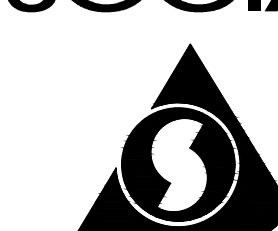SPRIET ASSOCIATES

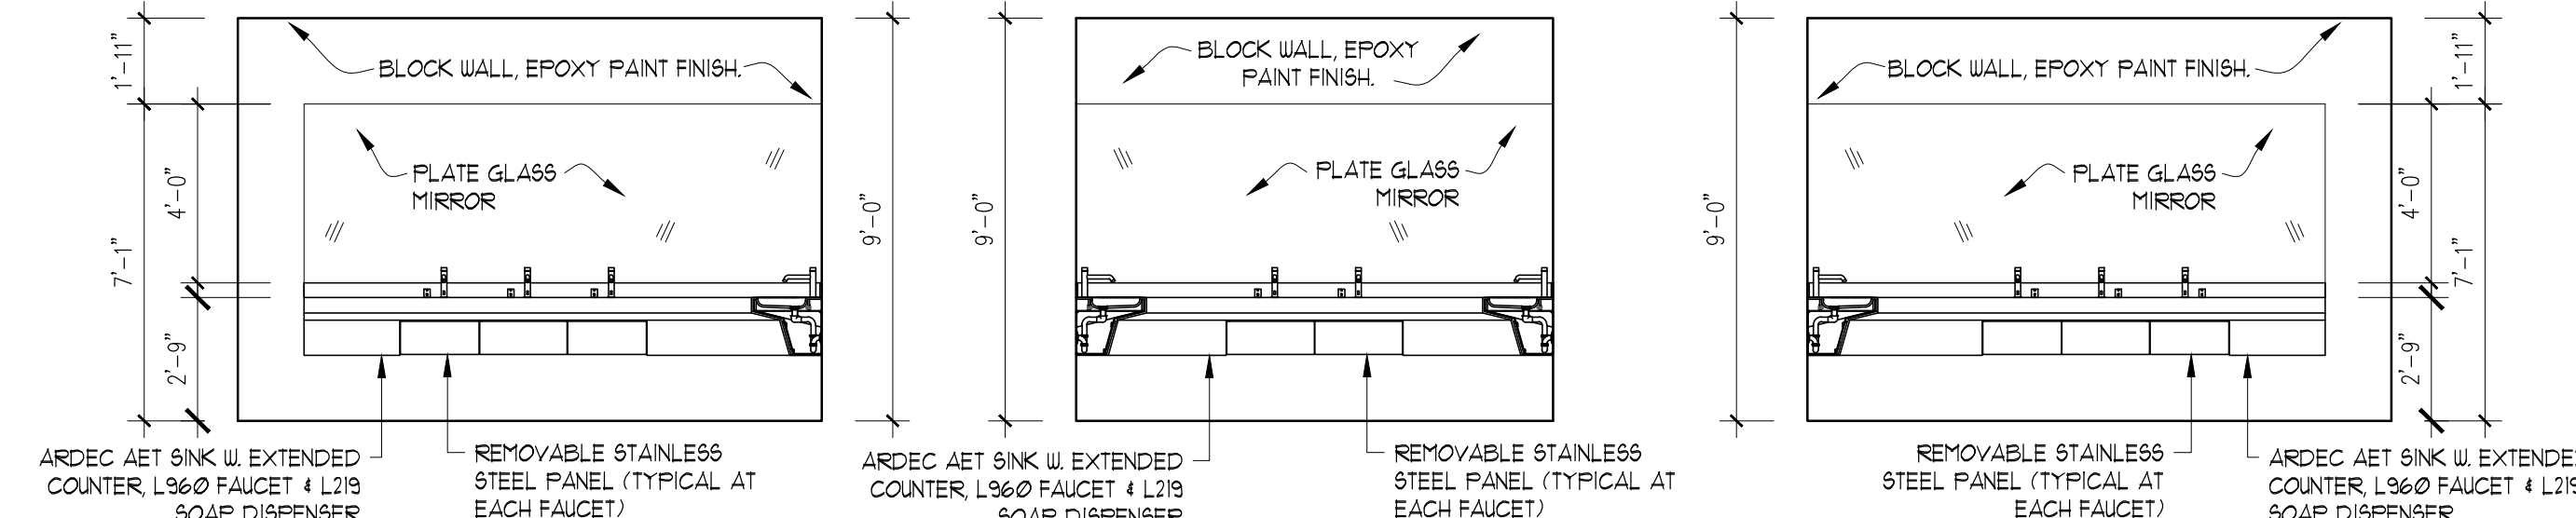LIMITED architects
LONDON LTD. engineers
155 york street - london - N6A 1A8
phone : (519) 672-4100 fax : (519) 433-9351
e-mail : mail@spriet.on.ca




13 FEMALE WASHROOM (206)
A8 SCALE: 1/4" = 1'-0"

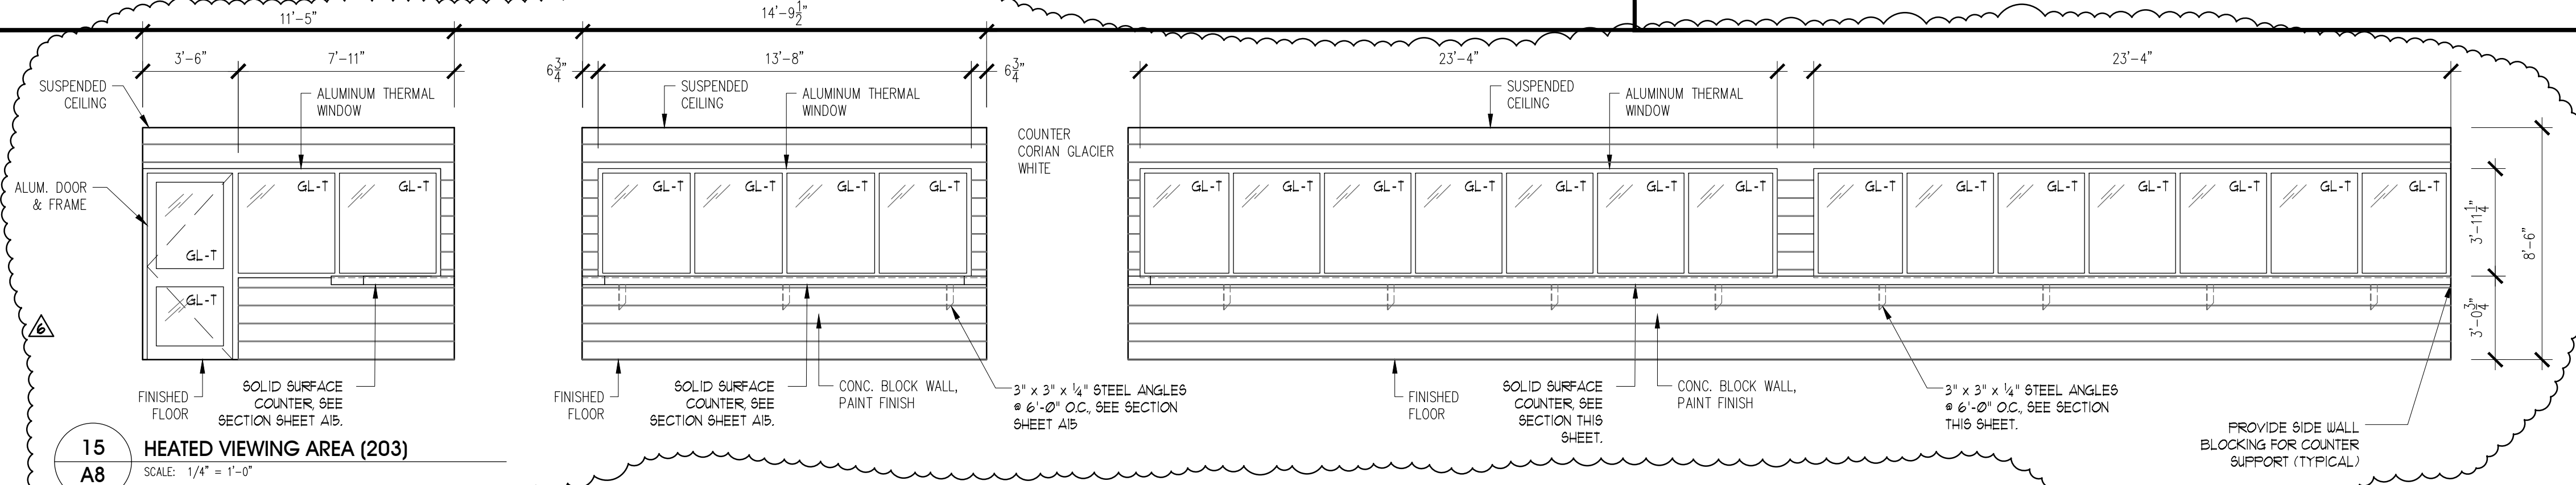14 MALE WASHROOM (205)
A8 SCALE: 1/4" = 1'-0"




15 HEATED VIEWING AREA (203)
A8 SCALE: 1/4" = 1'-0"

REFERENCE SHEET A15 FOR
MOUNTING HEIGHTS,
STANDARD SECTIONS &
REQUIRED BARRIER FREE
STANDARDS

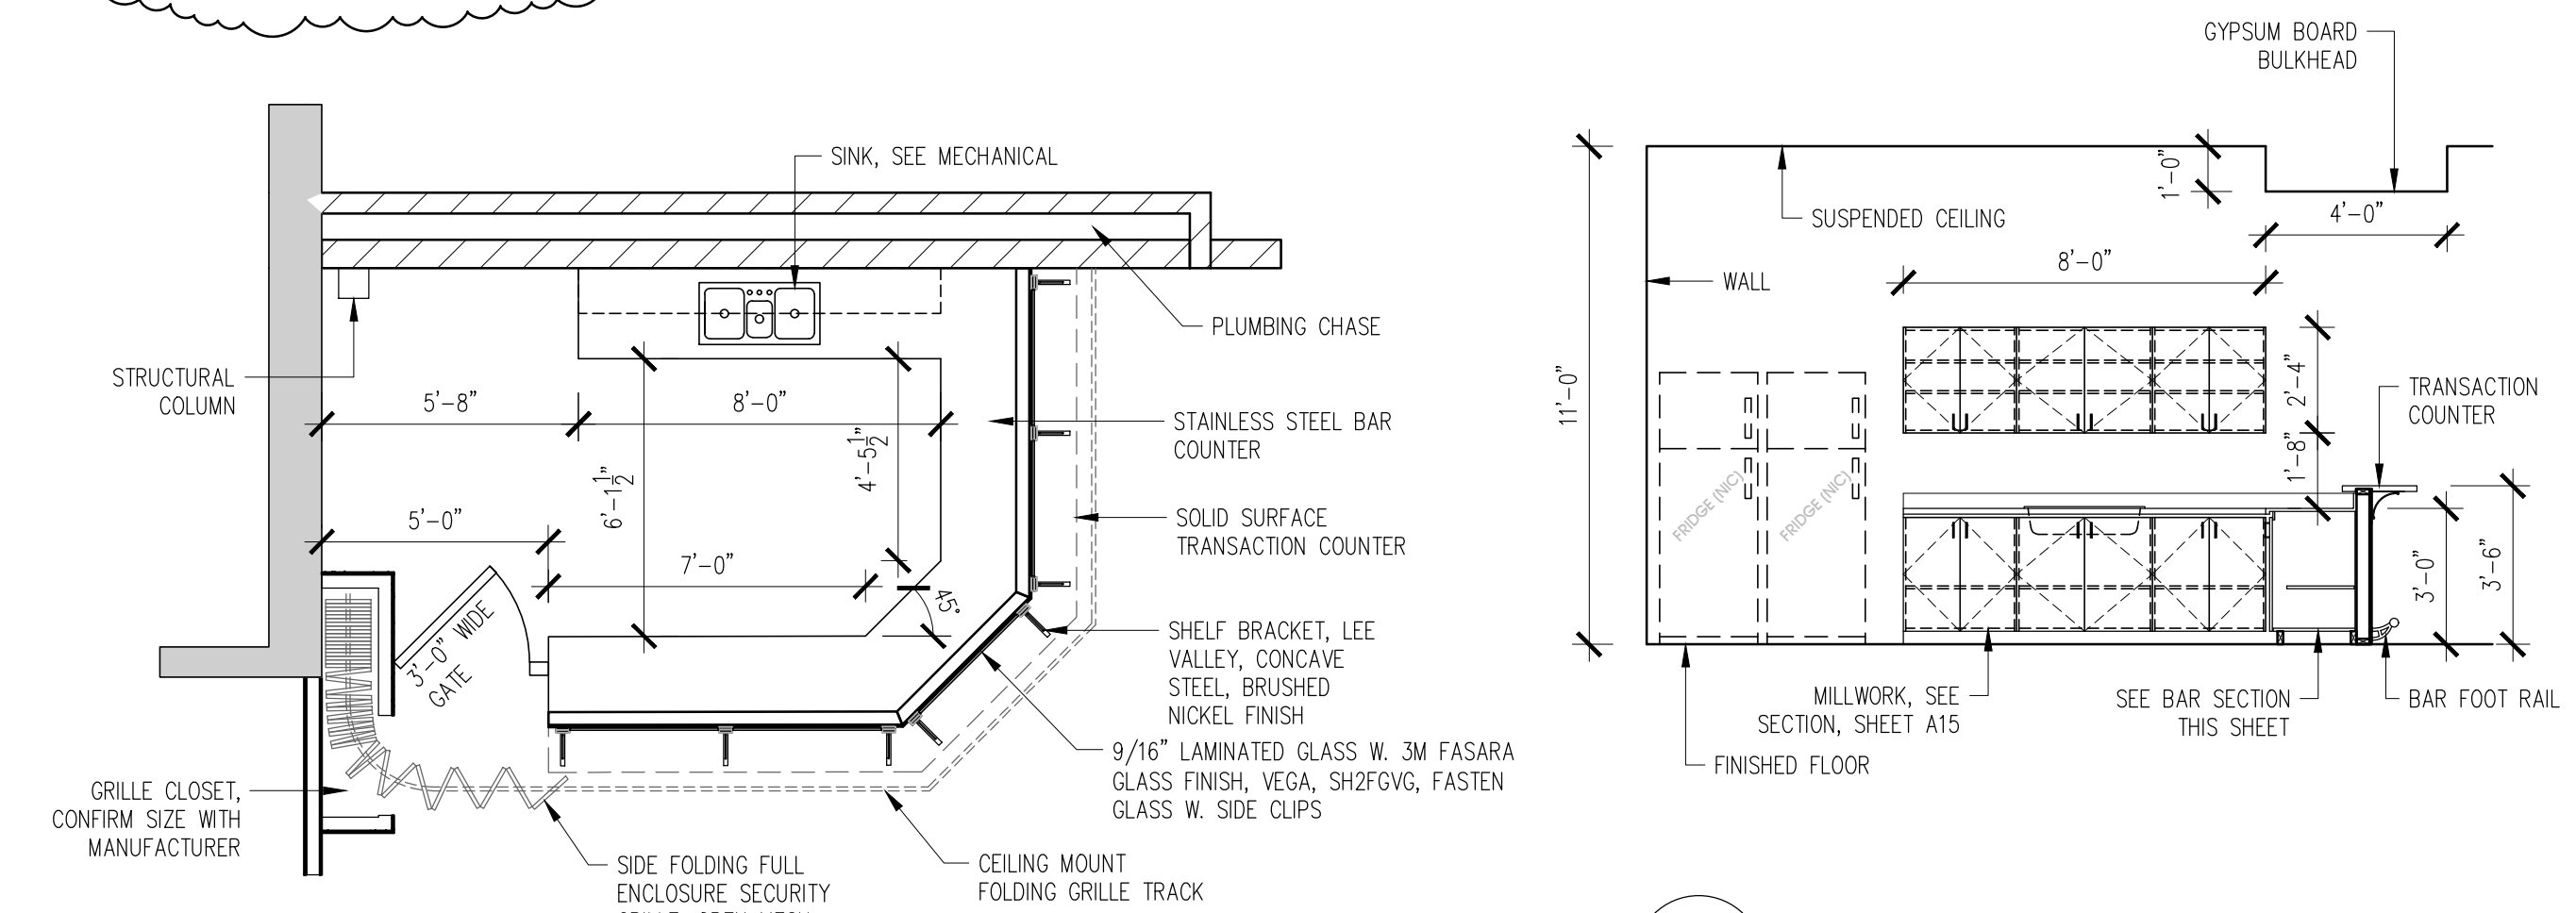


BAR (202) PLAN
SCALE: 1/4" = 1'-0"


16 BAR (202) - INTERIOR
A8 SCALE: 1/4" = 1'-0"

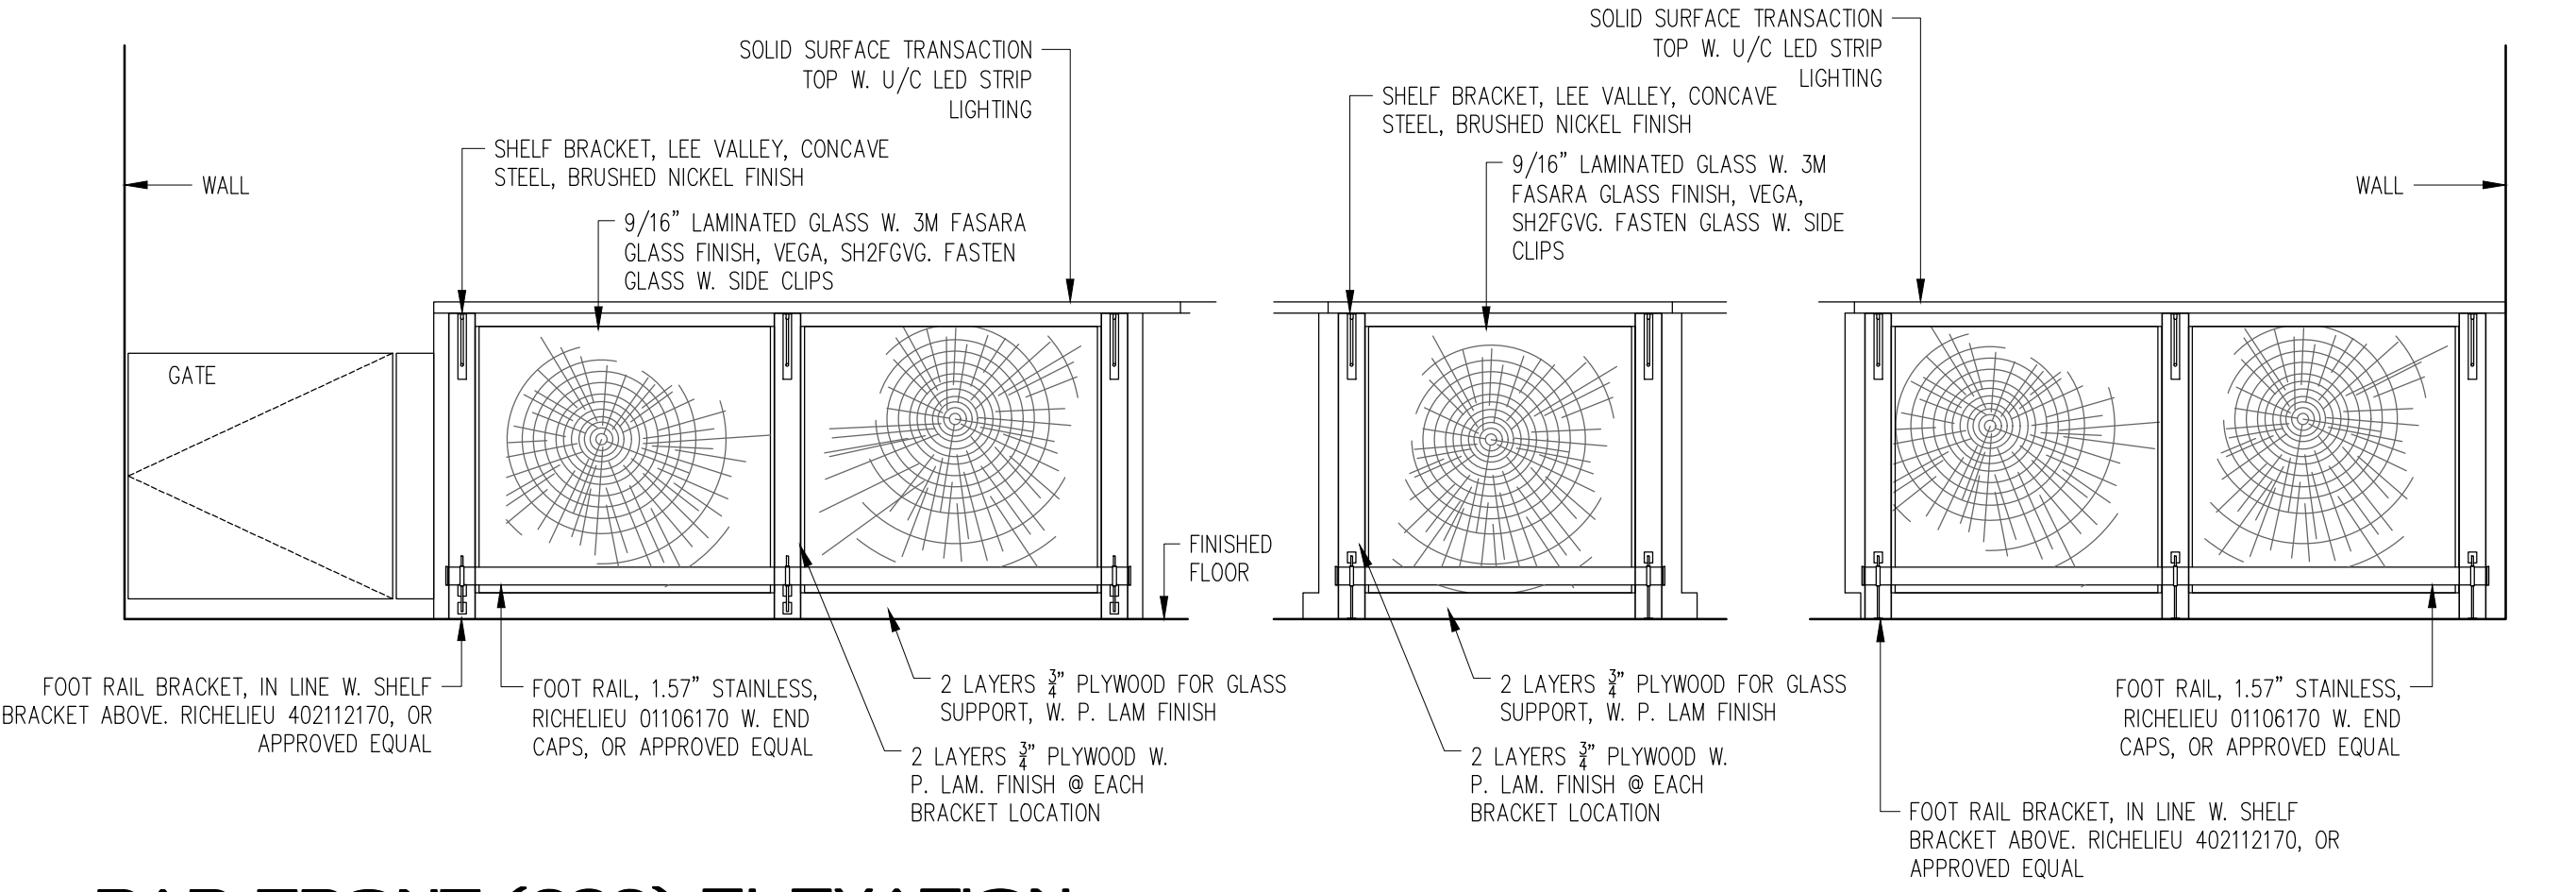


BAR FRONT (202) ELEVATION
SCALE: 1/2" = 1'-0"

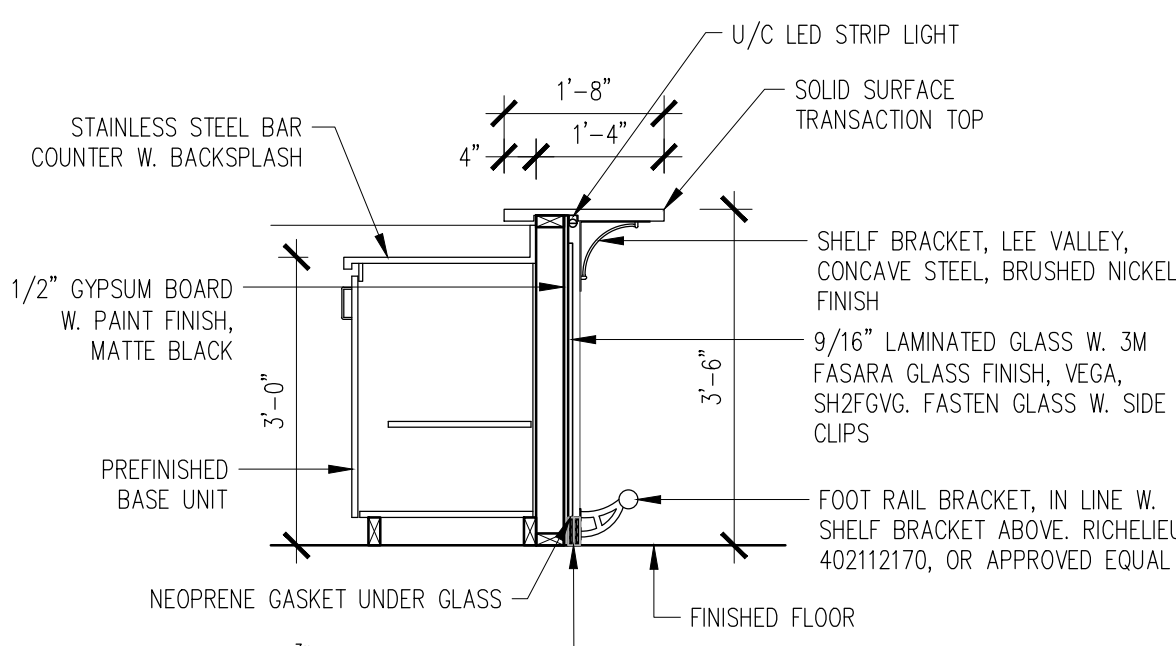

BAR (202) SECTION
SCALE: 1/2" = 1'-0"

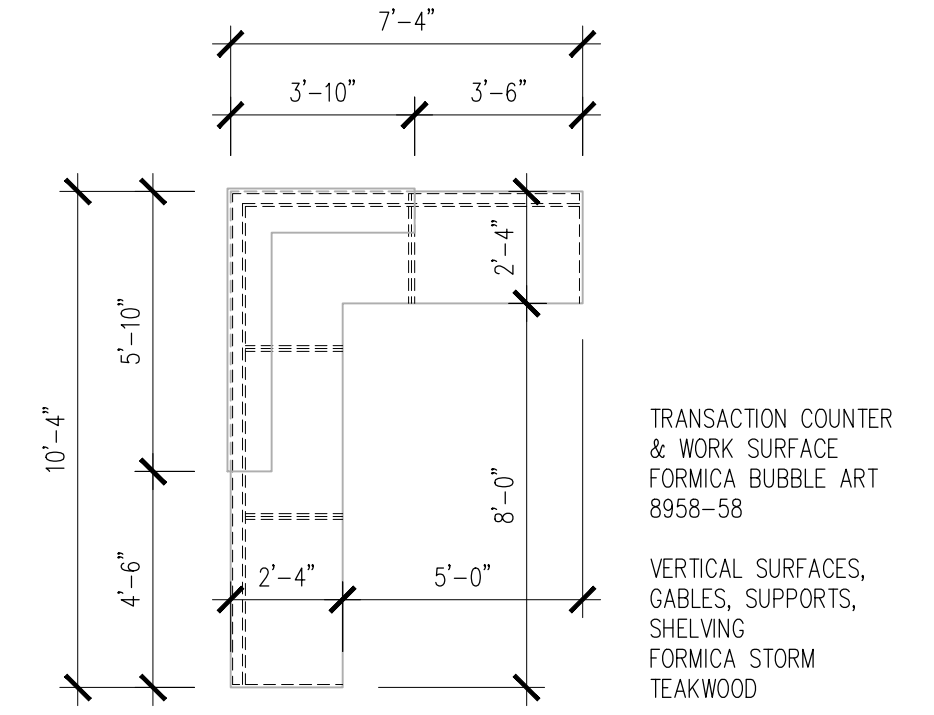


RECEPTION DESK PLAN - LOBBY (102)
SCALE: 1/4" = 1'-0"

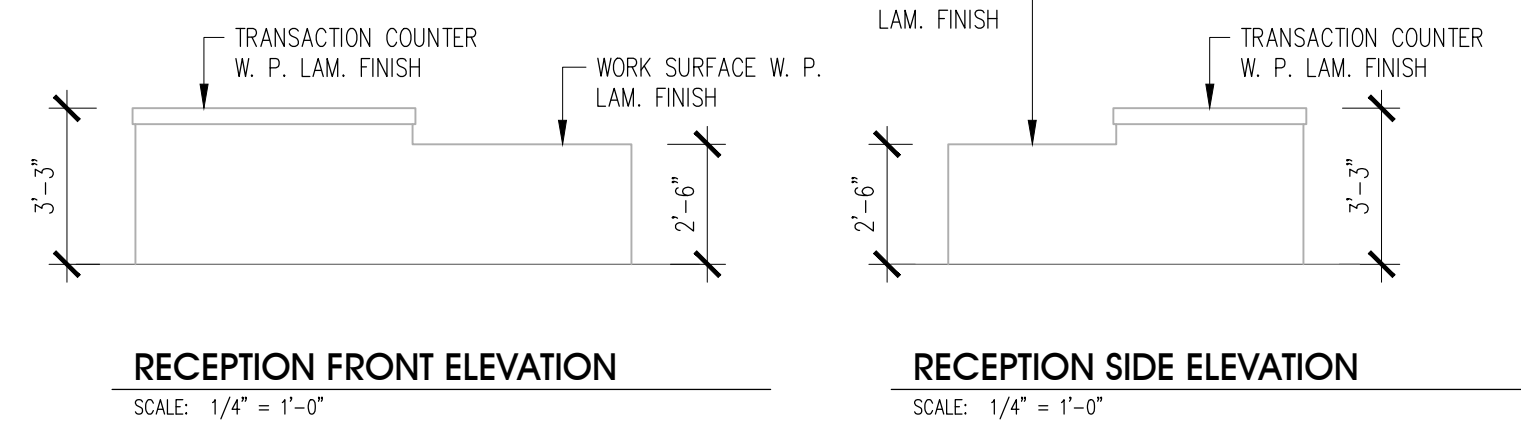

RECEPTION FRONT ELEVATION
SCALE: 1/4" = 1'-0"

RECEPTION SIDE ELEVATION
SCALE: 1/4" = 1'-0"


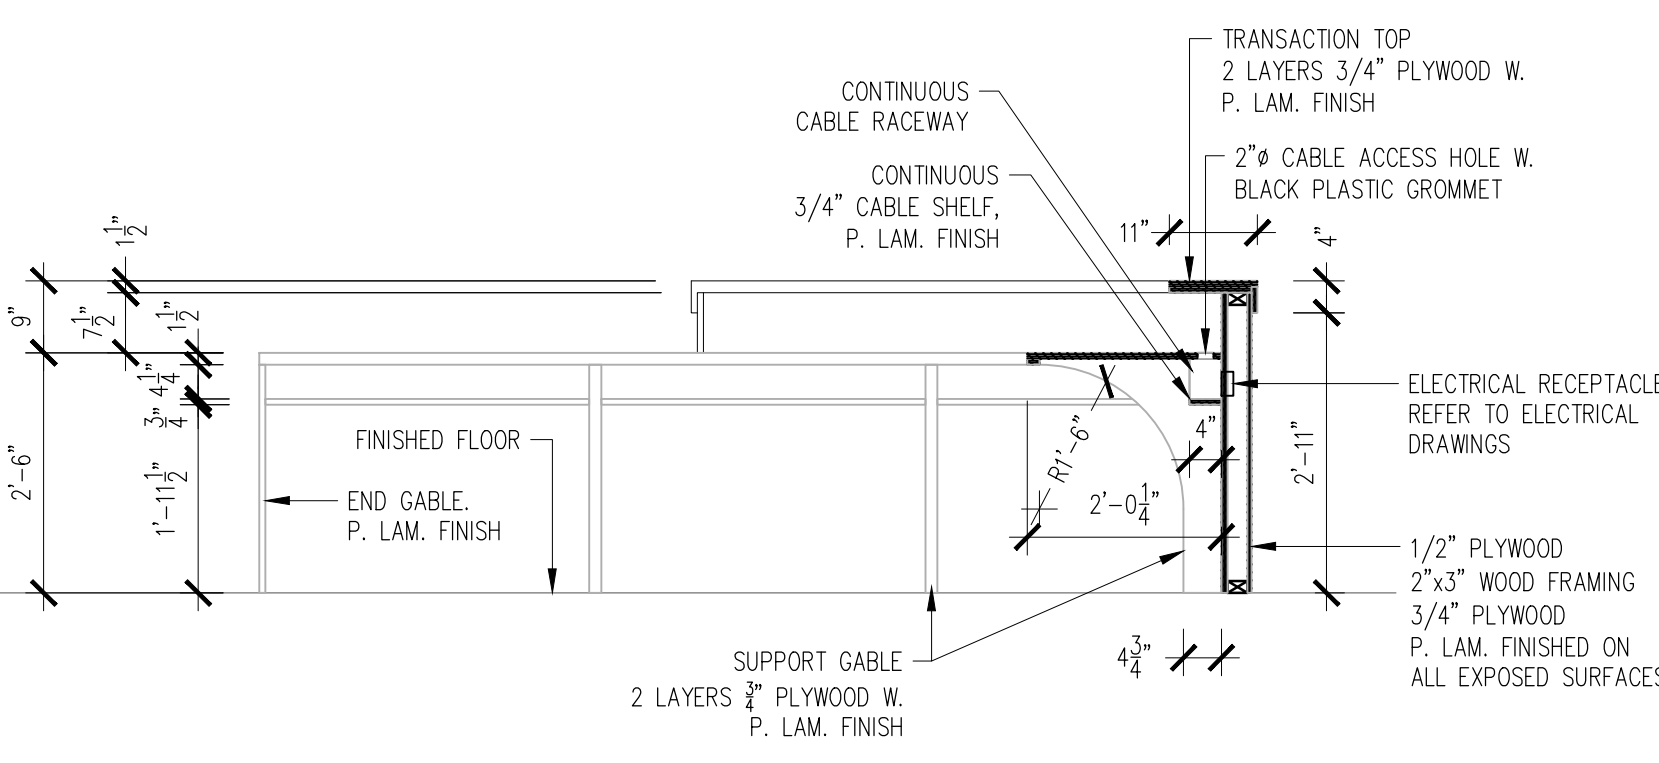


RECEPTION DESK SECTION
SCALE: 1/2" = 1'-0"

ISSUED FOR PERMIT	FEB. 01/22	
ADDENDA #6	JAN. 7/22	6
ADDENDA #2	DEC. 15/21	2
ISSUED FOR TENDER	DEC. 01/21	-
revisions	date	no.

CONTRACTORS MUST CHECK AND
VERIFY ALL DIMENSIONS AND REPORT
ANY DISCREPANCY TO THIS FIRM
BEFORE PROCEEDING WITH THE WORK

A - detail no.
B - location sheet
C - detail sheet

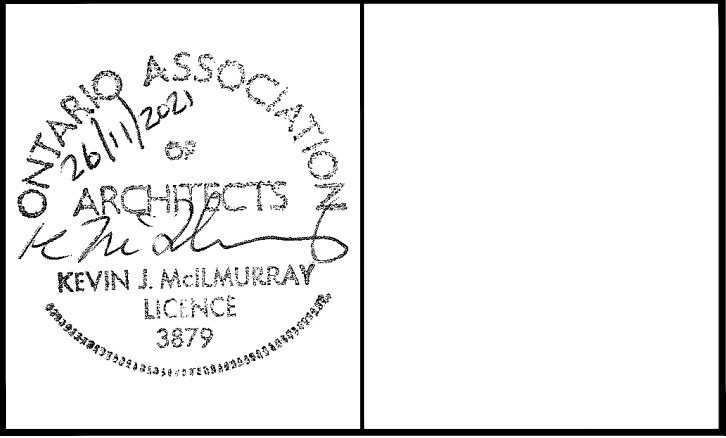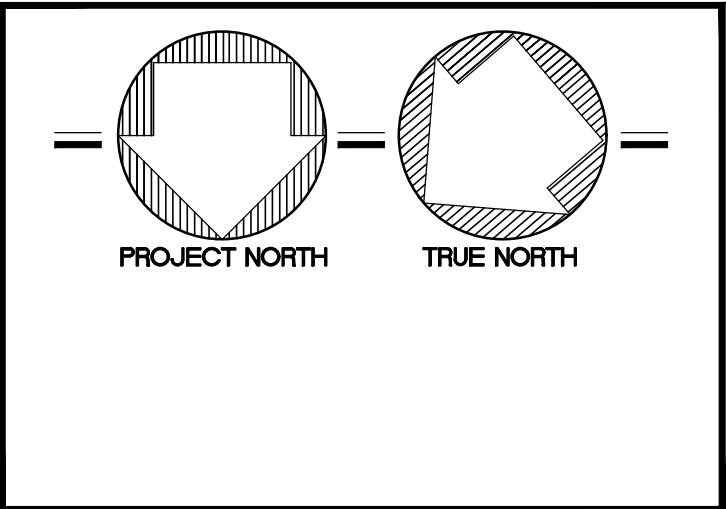

SPRIET ASSOCIATES

LIMITED architects
LONDON LTD. engineers


155 york street - london - N6A 1A8
phone : (519) 672-4100 fax : (519) 433-9351
e-mail : mail@spriet.on.ca

LUCAN BIDDULPH COMMUNITY MEMORIAL CENTRE
PHASE 2 - LUCAN ARENA
RENO'S & ARENA ADDITION
263 & 265 MAIN STREET, LUCAN, ONTARIO

drawing title :
INTERIOR ELEVATIONS


date : NOV 26, 2021
scale : AS NOTED
drawn by : MTH
project no. : 216255-2

drawing no. :
A17

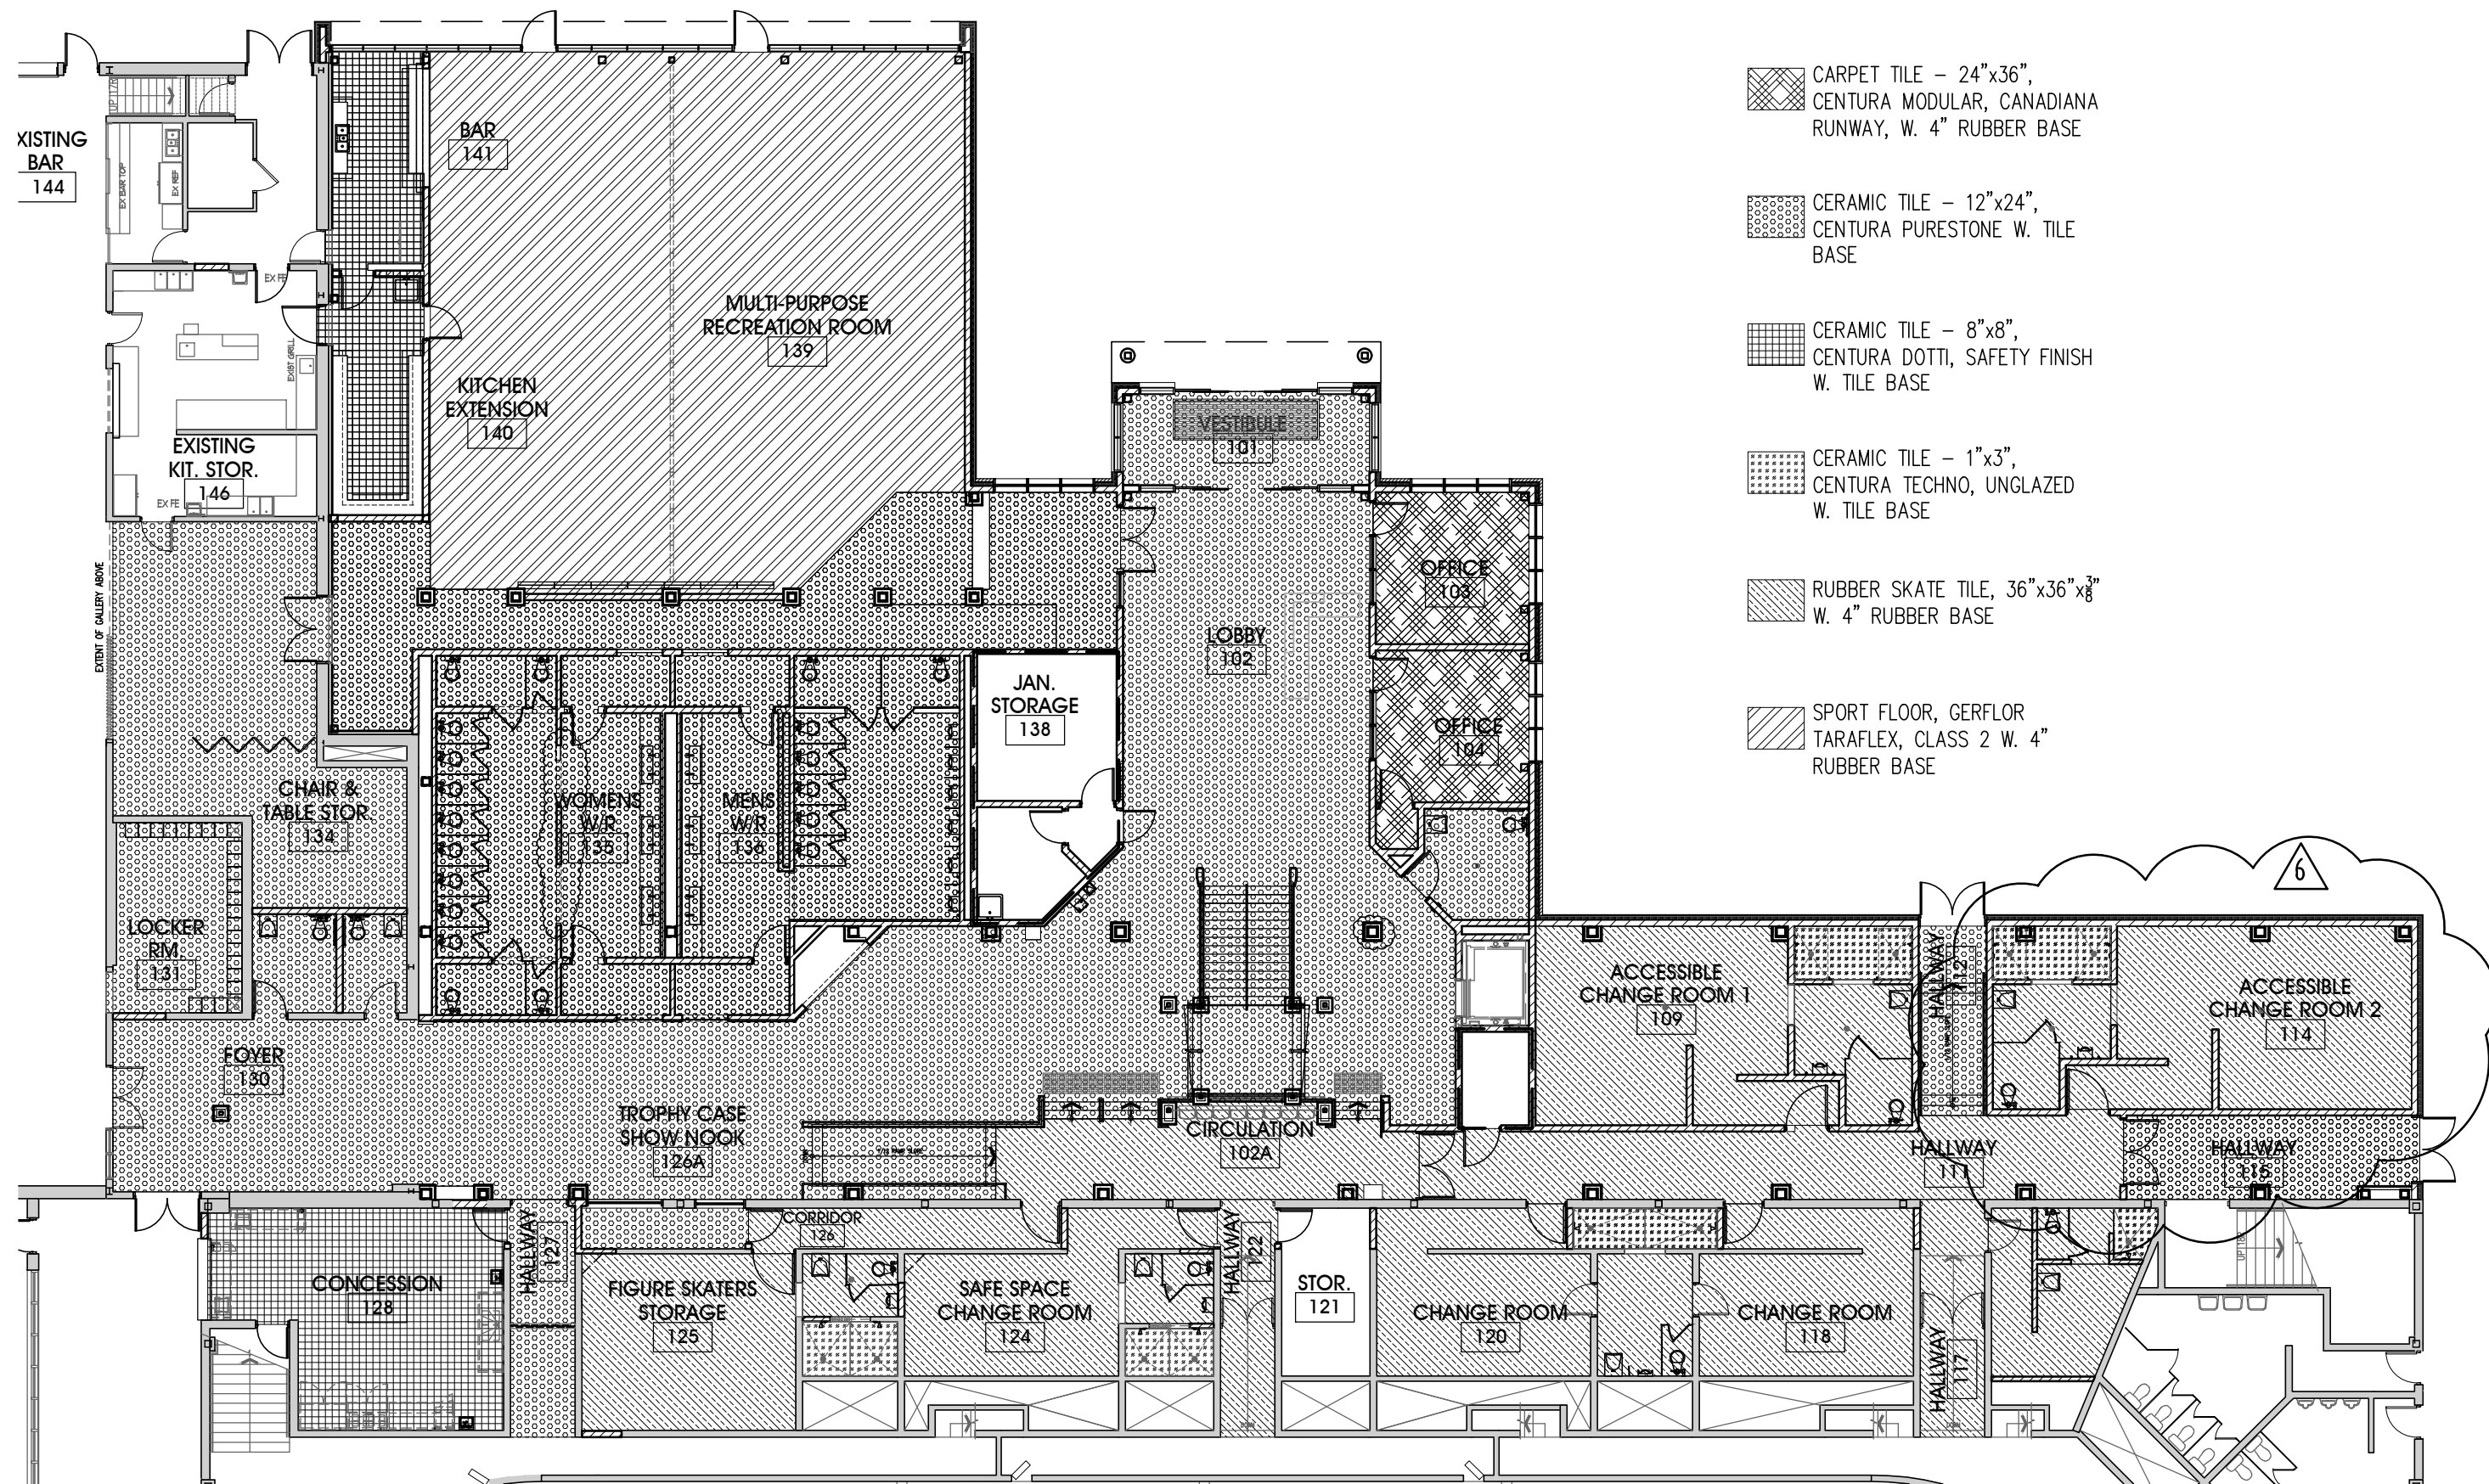

GROUND FLOOR - FLOORING FINISHES PLAN

SCALE: 1/16" = 1'-0"

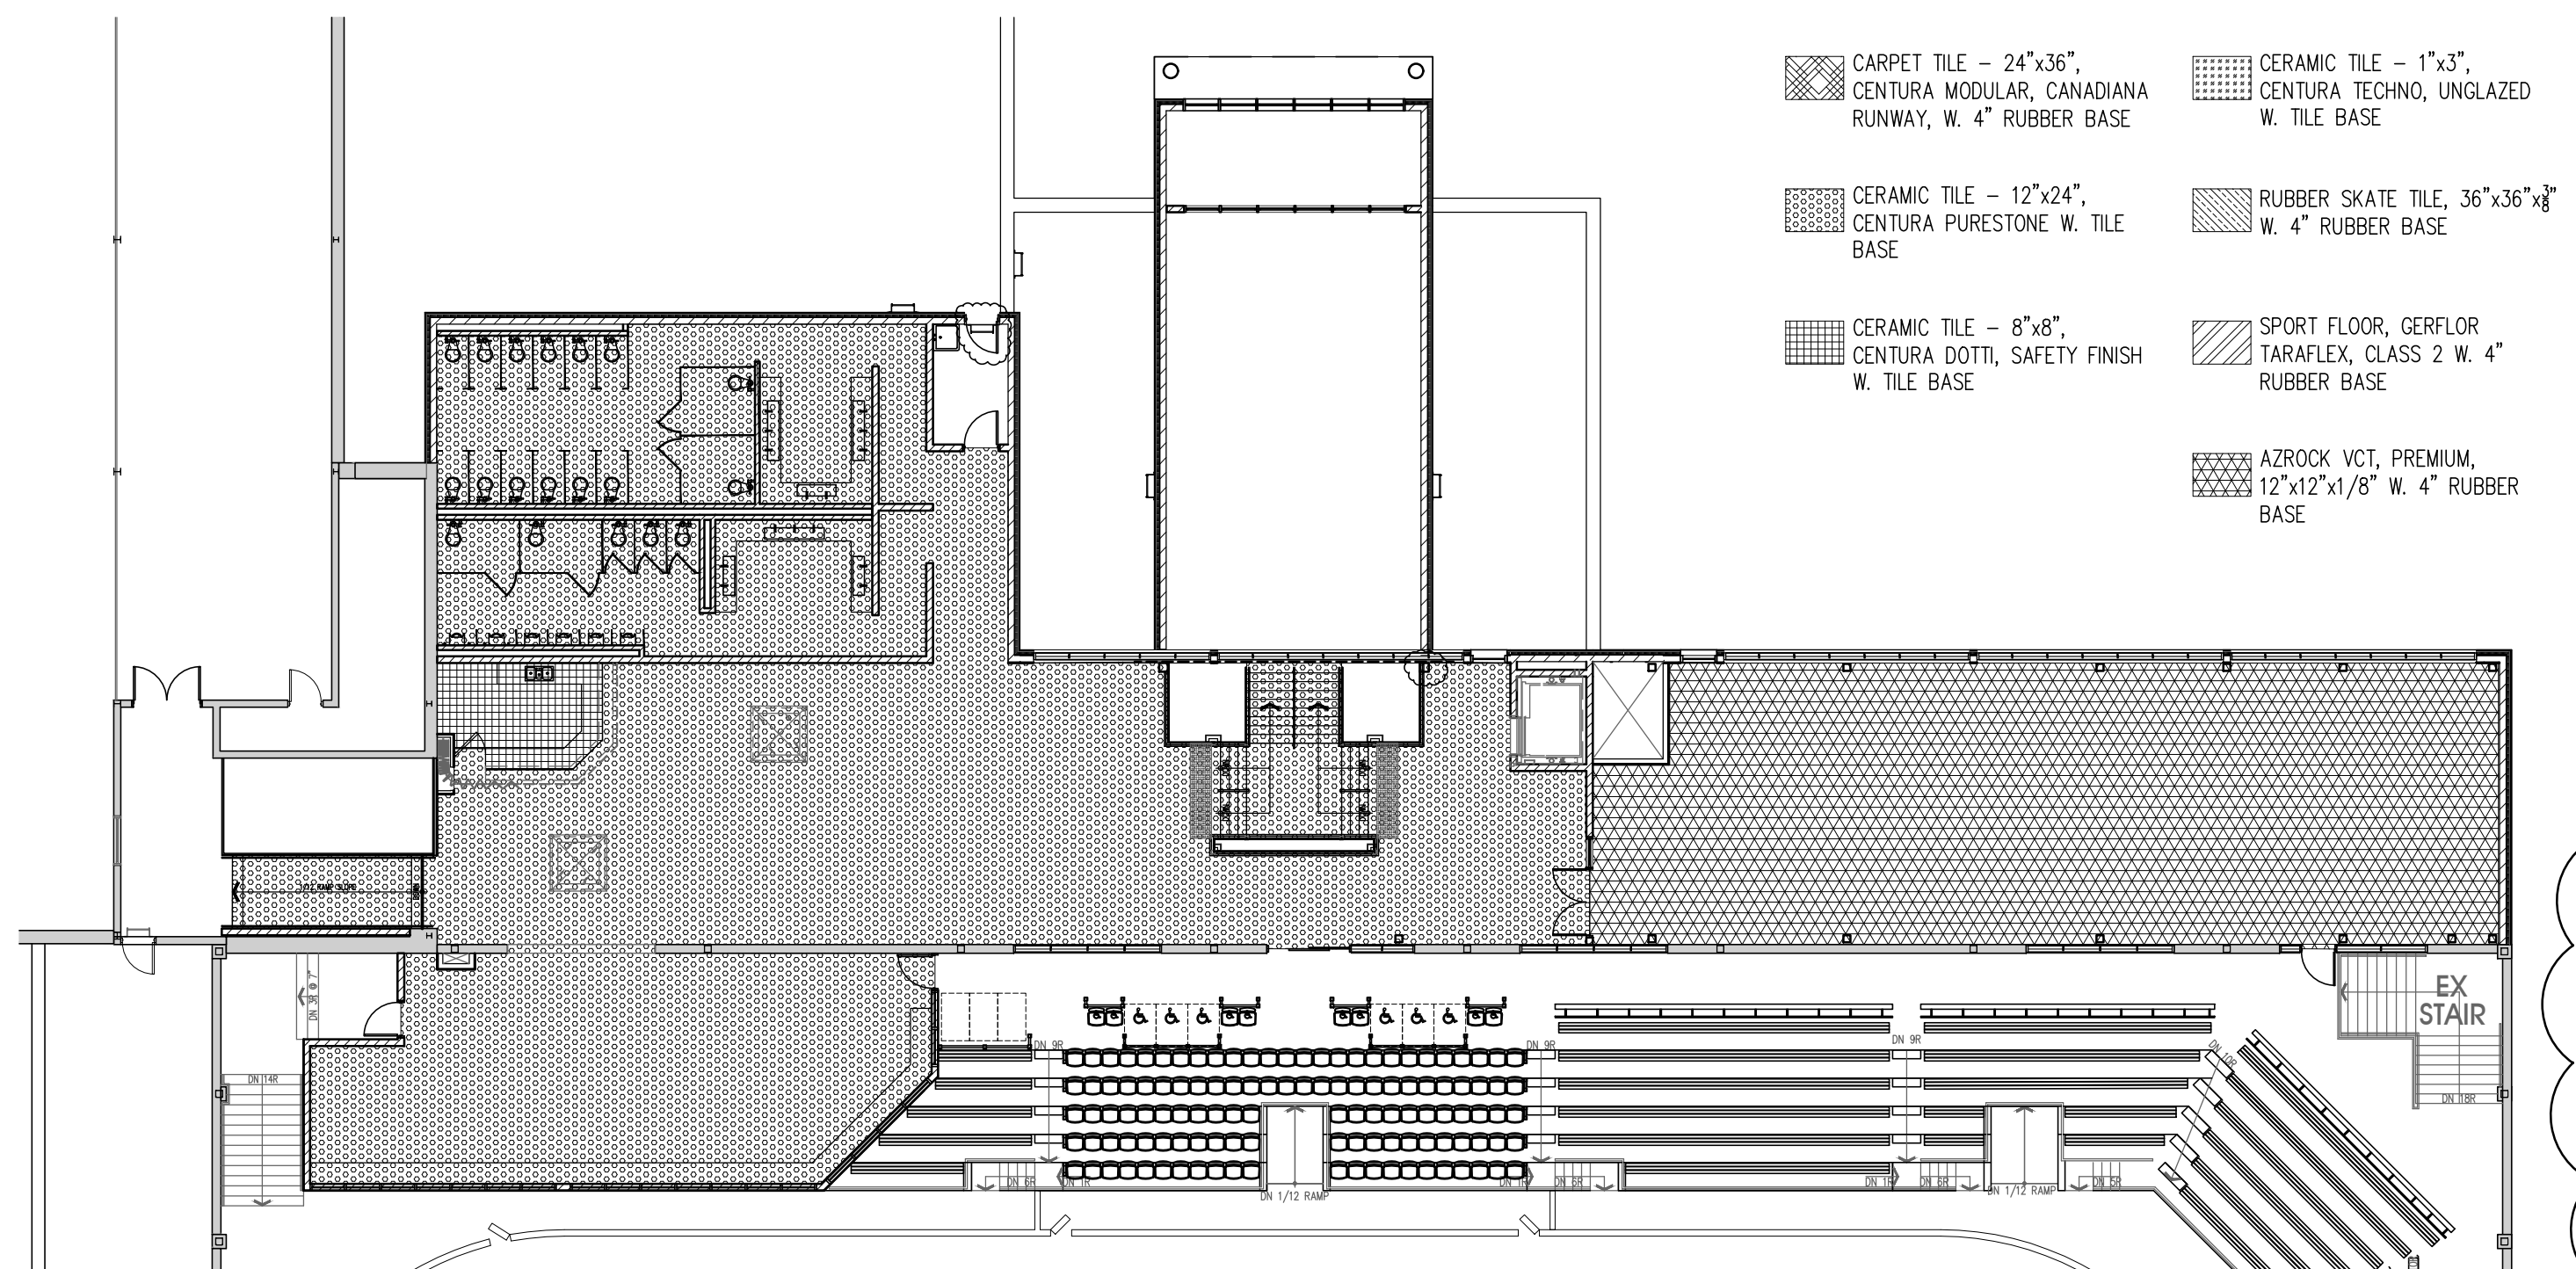

SECOND FLOOR - FLOORING FINISHES PLAN

SCALE: 1/16" = 1'-0"

1. PROVIDE 24" WIDE ACOUSTIC INSULATION AROUND PERIMETER ABOVE CEILING.
2. ALL EXPOSED CONCRETE FLOORS TO BE SEALED. REFER TO SPECIFICATIONS FOR PRODUCT TO BE USED.
3. PROVIDE HOLD DOWN CLIPS ON ACOUSTIC CEILING TILES.
4. INSTALL VISUALLY IMPAIRED, STRINGER / RISER COMBINATION (ONE PIECE STAIR TREAD) BY MARATHON - CARBOUNDOM FOR THE VISUALLY IMPAIRED.
5. INSTALL CERAMIC TILES or COLOURED CONCRETE TOPPING TO SECOND FLOOR AT TOP OF STAIRS - SEE DRAWINGS FOR MATERIALS.
6. PAINTING OF EXPOSED CEILING SHALL INCLUDE ALL STRUCTURAL STEEL, EXPOSED DUCT WORK, CONDUIT, O.W.S.J., STEEL DECK ETC.
7. ALL FINISHES TO BE INSTALLED PRIOR TO INSTALLATION OF MILLWORK.
8. PAINTING TO EXTEND TO FINISH FLOOR LEVEL.
9. INSTALL CERAMIC TILE TO ALL TREADS c/w SCHLUTER ANODIZED ALUMINUM NOSING, PAINT RISERS.
10. INSTALL 6" HIGH CERAMIC TILE BASE c/w SCHLUTER INSIDE AND OUTSIDE VERTICAL CORNERS, CAPS AND TRIMS AND COVE BASE WITH ALL INSIDE AND OUTSIDE CORNERS, CONNECTORS AND END CAPS. REFER TO SPECIFICATIONS FOR DETAILS.
11. ALL CONCRETE BLOCK / CONCRETE FLOOR SLAB INTERSECTIONS TO BE FILLED WITH GROUT TO ELIMINATE GAPS
12. BETWEEN WALL AND FLOOR. SEAL AS REQUIRED.

ABBREVIATIONS

THESE ARE STANDARD ROOM FINISH ABBREVIATIONS. NOT ALL ABBREVIATIONS ARE SPECIFIC TO THIS PROJECT AND ONLY APPLY IF LISTED IN THE ROOM FINISH SCHEDULE

A.T. - 1. . . . 2'-0" x 2'-0" ACOUSTIC TILES
A.T. - 2. . . . 2'-0" x 4'-0" ACOUSTIC TILES
EXP. EXPOSED
CPT. CARPET
CONC. CONCRETE
SF. SKATE TILE FLOORING
RSF. RUBBER SPORTS FLOOR
RWF. RESILIENT WOOD FLOORING
BLK. BLOCK
P. PAINT
RB. RUBBER BASE
C.T. CERAMIC TILE
DW. DRYWALL
L.P. METAL LINER PANEL
V.C.T. VINYL COMPOSITION TILE
M.R.B. . . . "MILLWORK" RUBBER BASE
TER. TERRAZZO
TERC. . . . TERRAZZO COVE BASE
ASB. ASBESTOS FLOOR TILE
WDP. WOOD PANELS
WDB. WOOD BASE
C.P.T.T. . . . CARPET TILE
EPX. EPOXY FLOOR COVERING
EPXC. EPOXY COVE BASE



ROOM FINISH SCHEDULE

No.	ROOM NAME	WALL		CEILING			REMARKS
		MATERIAL	FINISH	MATERIAL	FINISH	HEIGHT	
101	VESTIBULE	BLK/GB	P	ACT-1	-	9'-0"	.
102	LOBBY	BLK/GB	P	EXP/GB	P	11'-0"	CLING PART OPEN TO ABOVE, REFER TO RCP
102A	CIRCULATION	BLK/GB	P	GB/ACT-1	-	9'-0"	REFER TO RCP FOR AREA OF GB CEILING
103	OFFICE 1	BLK	P	ACT-2	-	9'-0"	.
104	OFFICE 2	BLK	P	ACT-2	-	9'-0"	.
105	CLOSET	BLK	P	GB	P	8'-0"	.
106	UNIVERSAL WASHROOM	BLK	P C.T.	ACT-1	-	9'-0"	SEE INTERIOR ELEVATIONS FOR EXTENT OF C.T.
107	ELEVATOR	-	-	-	-	-	SEE SPEC FOR FINISHES
108	ELEVATOR MACHINE ROOM	BLK	P	CONC	-	11'-6"	.
109	ACCESSIBLE CHANGE ROOM 1	BLK	P	CONC	-	11'-6"	OPEN TO SLAB ABOVE, PAINT BENCHES
110	ACCESSIBLE WASHROOM 1	BLK	P C.T.	CONC	-	11'-6"	SEE INTERIOR ELEVATIONS FOR EXTENT OF C.T.
110A	ACCESSIBLE SHOWER ROOM 1	BLK	P C.T.	CONC	-	11'-6"	SEE INTERIOR ELEVATIONS FOR EXTENT OF C.T.
111	HALLWAY	BLK	P	CONC	-	11'-6"	OPEN TO SLAB ABOVE
112	HALLWAY	BLK	P	CONC	-	VARIES	CEILING HEIGHT VARIES SEE RCP
113	ACCESSIBLE WASHROOM 2	BLK	P C.T.	CONC	-	11'-6"	SEE INTERIOR ELEVATIONS FOR EXTENT OF C.T.
113A	ACCESSIBLE SHOWER ROOM 2	BLK	P C.T.	CONC	-	11'-6"	SEE INTERIOR ELEVATIONS FOR EXTENT OF C.T.
114	ACCESSIBLE CHANGE ROOM 2	BLK	P	CONC	-	11'-6"	OPEN TO SLAB ABOVE, PAINT BENCHES
115	HALLWAY	BLK	P	CONC	-	11'-6"	OPEN TO SLAB ABOVE
116	REFEREE CHANGE ROOM	BLK	P C.T.	CONC	-	VARIES	SEE INTERIOR ELEVATIONS FOR EXTENT OF C.T.
117	HALLWAY	BLK	P	CONC	-	VARIES	OPEN TO SLAB ABOVE, REFER TO RCP
118	CHANGE ROOM 3	BLK	P	CONC	-	VARIES	CLING HEIGHT VARIES, REFER TO RCP
119	SHOWER ROOM	BLK	P	CONC	-	VARIES	OPEN TO SLAB ABOVE, CLING HEIGHT VARIES, REFER TO RCP
120	CHANGE ROOM 4	BLK	P	CONC	-	VARIES	CLING HEIGHT VARIES, REFER TO RCP
121	STORAGE	BLK	-	CONC	-	-	OPEN TO SLAB ABOVE
122	HALLWAY	BLK	P	CONC	-	VARIES	OPEN TO SLAB ABOVE, CLING HEIGHT VARIES, REFER TO RCP
123	SHOWER ROOM	BLK	P C.T.	CONC	-	VARIES	SEE INTERIOR ELEVATIONS FOR EXTENT OF C.T.
124	SAFE SPACE CHANGE ROOM	BLK	P	CONC	-	VARIES	OPEN TO SLAB ABOVE, CLING HEIGHT VARIES, REFER TO RCP
125	FIGURE SKATERS STORAGE	BLK	P	CONC	-	11'-8"	OPEN TO SLAB ABOVE
125A	SHOWER ROOM	BLK	P C.T.	CONC	-	VARIES	SEE INTERIOR ELEVATIONS FOR EXTENT OF C.T.
126	CORRIDOR	BLK	P	CONC	-	12'-0"	OPEN TO SLAB ABOVE, REFER TO RCP
126A	TROPHY CASE/SHOW NOOK	BLK	P	GB	P	9'-0"	.
127	HALLWAY	BLK	P	CONC	-	10'-4"	OPEN TO SLAB ABOVE, CLING HEIGHT VARIES, REFER TO RCP
128	CONCESSION	BLK	P	ACT-2	-	9'-0"	.
129	STORE	BLK	-	CONC	-	-	CLING HEIGHT VARIES, UNDER STAIR
130	FOYER	BLK	P	ACT-1	-	9'-0"	PART CLING OPEN TO ABOVE W. GB BULKHEAD REFER TO RCP
131	LOCKER ROOM	BLK	P	ACT-1	-	9'-0"	.
132	BF WASHROOM	BLK	P C.T.	ACT-1	-	8'-0"	CERAMIC TILE FROM FLOOR TO 5'-0" AFF. ALL WALLS, PAINT ABOVE
133	WASHROOM	BLK	P C.T.	ACT-1	-	8'-0"	CERAMIC TILE FROM FLOOR TO 5'-0" AFF. ALL WALLS, PAINT ABOVE
134	CHAIR AND TABLE STORAGE	BLK	P	ACT-1	-	9'-0"	W. GB BULKHEAD, REFER TO RCP
135	WOMEN'S WASHROOM	BLK	P C.T.	ACT-1	-	9'-0"	CERAMIC TILE FROM FLOOR TO 5'-0" AFF. ALL WALLS, PAINT ABOVE
136	MEN'S WASHROOM	BLK	P C.T.	ACT-1	-	9'-0"	CERAMIC TILE FROM FLOOR TO 5'-0" AFF. ALL WALLS, PAINT ABOVE
137	MECH ROOM	BLK	P	CONC	-	10'-6"	OPEN TO SLAB ABOVE
138	JANITOR/STORAGE	BLK	P	CONC	-	10'-6"	OPEN TO SLAB ABOVE
139	MULTI-PURPOSE REC. ROOM	BLK	P	ACT-1	-/P	13'-0"	W. GB BULKHEAD AT MOVABLE PARTITION, REFER TO RCP
139A	CORRIDOR	BLK	P	GB	P	9'-0"	.
140	KITCHEN EXTENSION	BLK	P	ACT-2	-	10'-0"	.
141	BAR	BLK	P	ACT-2	-	13'-0"	.
142	EXISTING STORAGE	BLK	P	EXISTING	-	-	PAINT WALLS MODIFIED BY CONSTRUCTION COLOUR TO MATCH EXISTING
144	EXISTING BAR	BLK	P	EXISTING	-	-	.
145	EXISTING KITCHEN	BLK	P	EXISTING	-	-	PAINT WALLS MODIFIED BY CONSTRUCTION COLOUR TO MATCH EXISTING
146	EXISTING KITCHEN STORAGE	BLK	P	EXISTING	-	-	.
147	EXISTING ALCOVE	BLK	P	ACT-1 GB	-	9'-0"	PAINT BULKHEAD
148	EXISTING GYMNASIUM	BLK	P	EXISTING	-	-	PAINT WALLS MODIFIED BY CONSTRUCTION COLOUR TO MATCH EXISTING
156	CORRIDOR	-	-	-	-	-	PAINT WALL MODIFIED BY CONSTRUCTION COLOUR TO MATCH EXISTING
201	OPEN CIRCULATION SPACE	BLK	P	ACT-1 GB	-	10'-0" 9'-6"	PAINT BULKHEAD
202	BAR	BLK/GB	P	ACT-1 GB	-	9'-6"	PAINT BULKHEAD
203	HEATED VIEWING AREA	BLK/GB	P				
204	CORRIDOR	BLK	P				
205	MALE WASHROOM	BLK	P C.T.				CERAMIC TILE FROM FLOOR TO 5'-0" AFF. ALL WALLS, PAINT ABOVE
206	FEMALE WASHROOM	BLK	P C.T.				CERAMIC TILE FROM FLOOR TO 5'-0" AFF. ALL WALLS, PAINT ABOVE
207	JANITOR	BLK	P				
208	CORRIDOR	BLK	P				
209	FLEX SPACE	BLK/GB	P				
210	SPECTATORS	BLK/GB	P				
		-	-	-	-	-	

ISSUED FOR PERMIT	FEB. 01/22	
ADDENDA #6	JAN. 07/22	6
ADDENDA #2	DEC. 15/21	1
ISSUED FOR TENDER	DEC. 01/21	1
revisions	date	no.

CONTRACTORS MUST CHECK AND VERIFY ALL DIMENSIONS AND REPORT ANY DISCREPANCY TO THIS FIRM BEFORE PROCEEDING WITH THE WORK

A - detail no.
B - location sheet
C - detail sheet

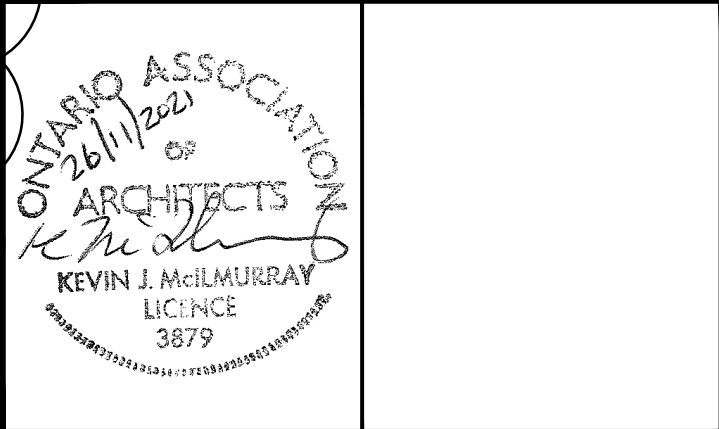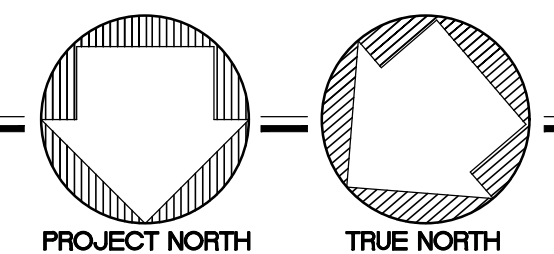


SPRIET ASSOCIATES

LIMITED architects LONDON LTD. engineers
155 york street - london - N6A 1A8
phone : (519) 672-4100 fax : (519) 433-9351
e-mail : mail@spriet.on.ca


LUCAN BIDDULPH COMMUNITY MEMORIAL CENTRE
PHASE 2 - LUCAN ARENA
RENO'S & ARENA ADDITION
263 & 265 MAIN STREET, LUCAN, ONTARIO

drawing title :
ROOM FINISH SCHEDULE
date : NOV. 26, 2021
scale : AS NOTED
drawn by : RP
project no. : 216255-2
drawing no. : A19

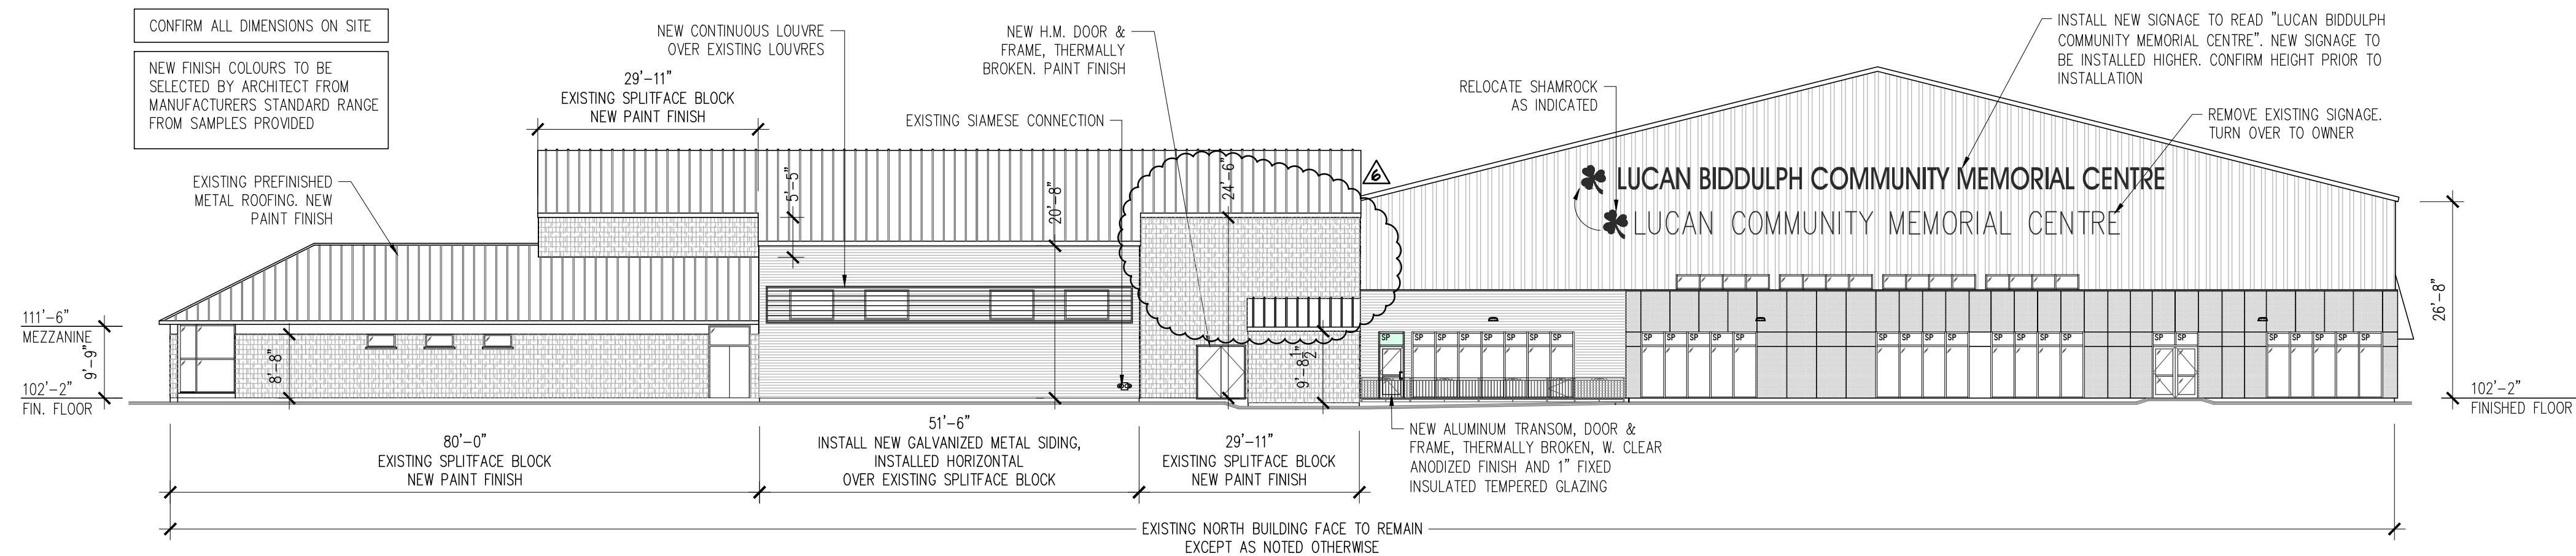


NORTH ELEVATION

SCALE: 1/16" = 1'-0"

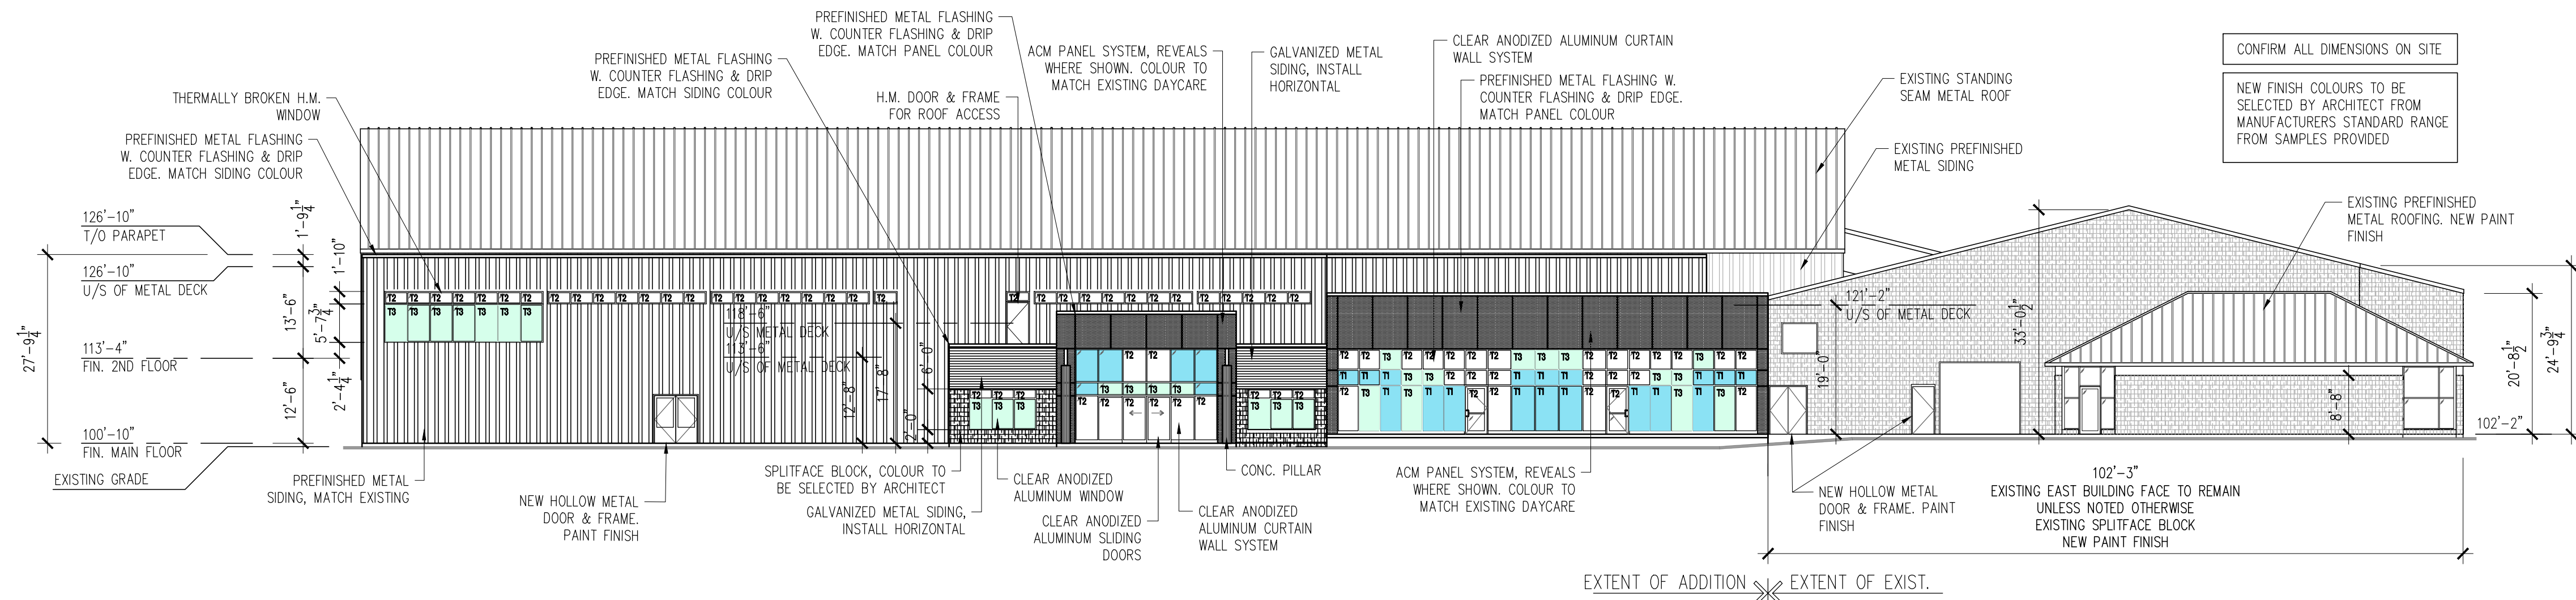

EAST ELEVATION

SCALE: 1/16" = 1'-0"

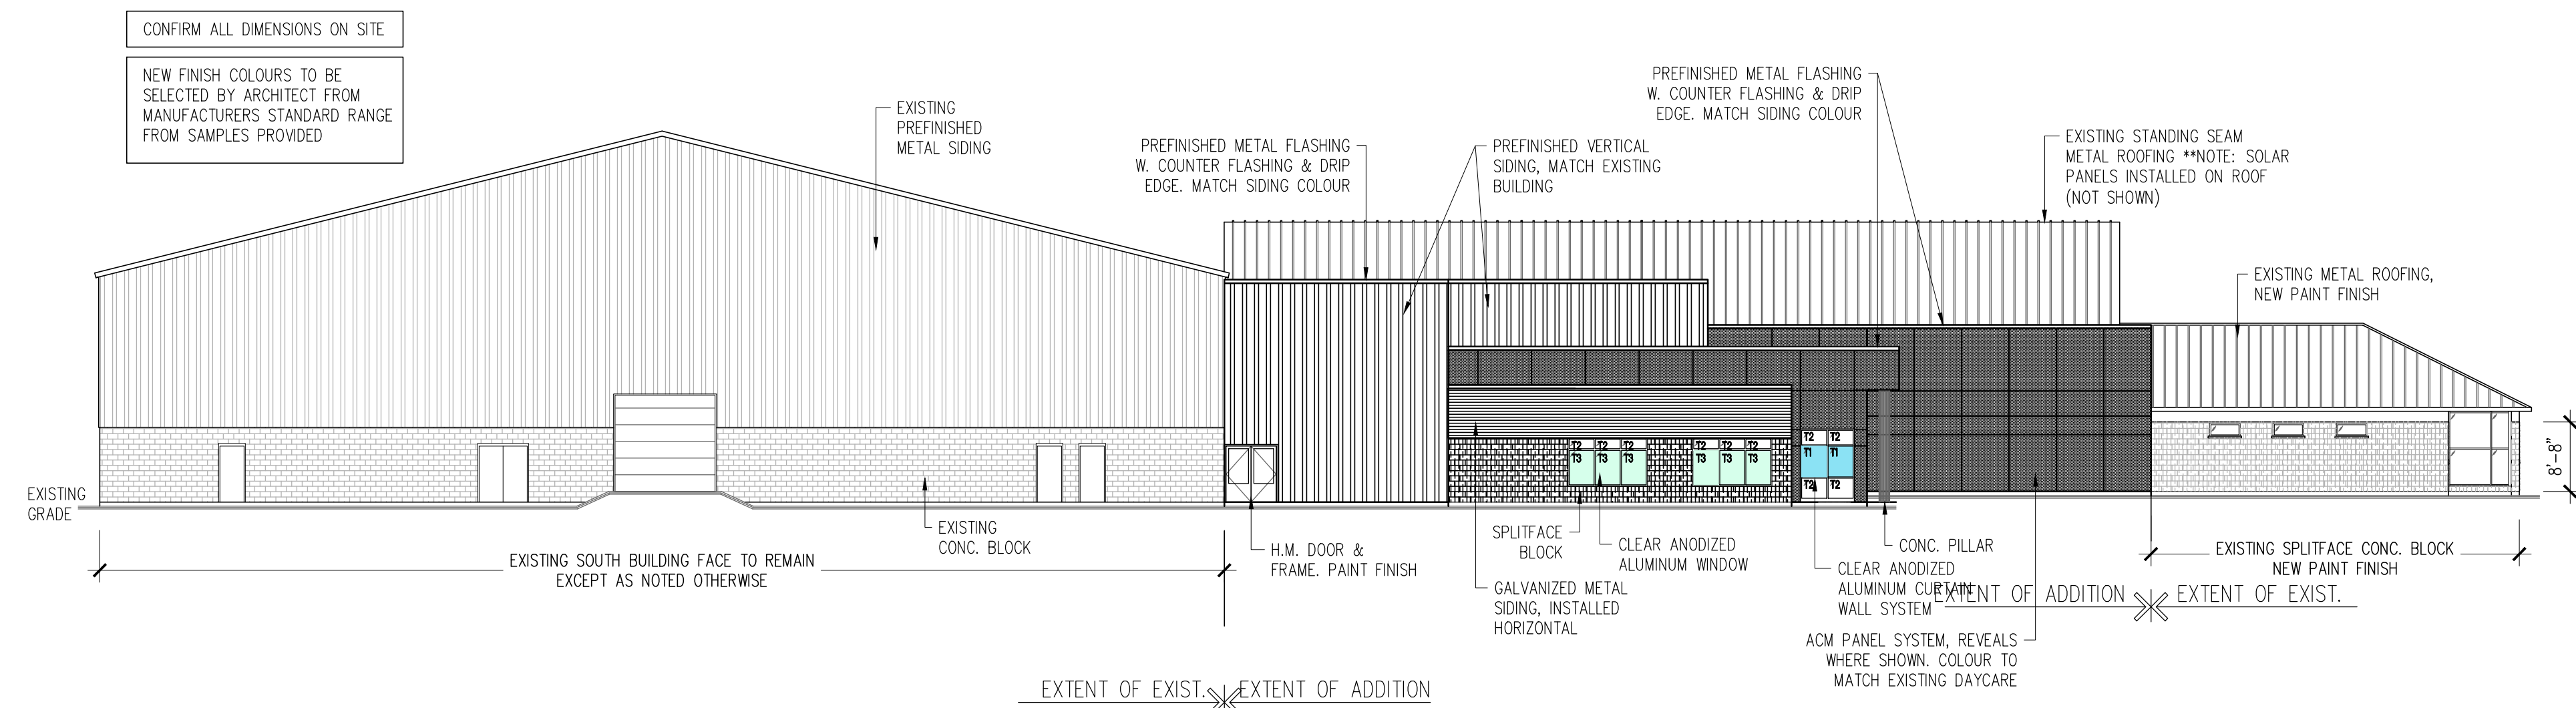

SOUTH ELEVATION

SCALE: 1/16" = 1'-0"

FINISH NOTES:

GLAZING TINTS

ALL NEW GLAZING TO RECEIVE TINT AS NOTED

T1 - 1" VC AZURIA, CLEAR LOW-E, TEM/TEM; ARGON GAS INSULATED GLASS UNIT
1/4" VISTA COOL AZURIA TEMPERED O.B. LITE
1/2" AS GRAY; ARGON GAS; SILICONE SEALS
1/4" CLEAR SOLARBAN 60 LOW-E #3 TEMPERED I.B. LITE

T2 - 1" OPTIGRAY, CLEAR LOW-E, TEM/TEM; ARGON GAS INSULATED GLASS UNIT
1/4" OPTIGRAY TEMPERED O.B. LITE
1/2" AS GRAY; ARGON GAS; SILICONE SEALS
1/4" CLEAR SOLARBAN 60 LOW-E #3 TEMPERED I.B. LITE

T3 - 1" SOLEXIA/CLEAR LOW-E, TEM/TEM; ARGON GAS INSULATED GLASS UNIT
1/4" SOLEXIA (GREEN) TEMPERED O.B. LITE
1/2" AS GRAY; ARGON GAS; SILICONE SEALS
1/4" CLEAR SOLARBAN 60 LOW-E #3 TEMPERED I.B. LITE

CURTAIN WALL

CLEAR ANODIZED ALUMINUM 1600 UT SERIES CURTAIN WALL SYSTEM

ACM PANEL SYSTEM

CLADCO ACM PANEL SYSTEM C2000, 3mm ACM ALPOLIC/PE, PANEL FINISH BGN GREEN.

FLASHING COLOUR TO MATCH ACM PANEL COLOUR

HORIZONTAL METAL SIDING

AGWAY 7/8" CORRUGATED METAL SIDING, PERSPECTRA PLUS, GALVANIZED ALUMINUM

FLASHING COLOUR TO BE WHITE

VERTICAL METAL SIDING




AGWAY 3-150 INV, PERSPECTRA PLUS, QC 28013, SLATE GREY

FLASHING COLOUR TO BE WHITE

ISSUED FOR PERMIT	FEB. 01/22	
ADDENDA #6	JAN. 07/22	6
ADDENDA #2	DEC. 15/21	2
ISSUED FOR TENDER	DEC. 01/21	-
revisions	date	no.

CONTRACTORS MUST CHECK AND VERIFY ALL DIMENSIONS AND REPORT ANY DISCREPANCY TO THIS FIRM BEFORE PROCEEDING WITH THE WORK

A - detail no.
B - location sheet
C - detail sheet

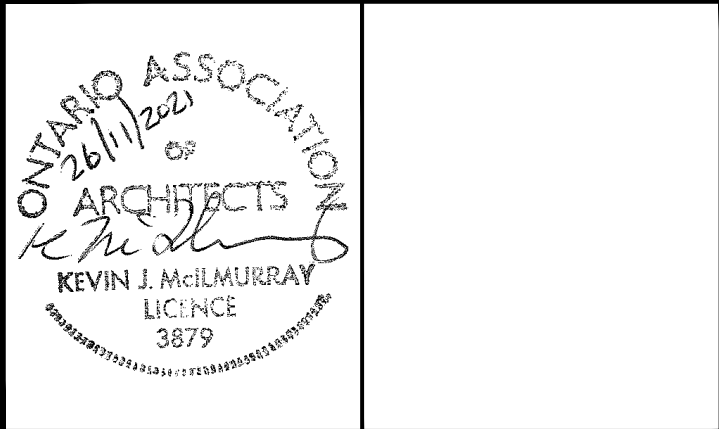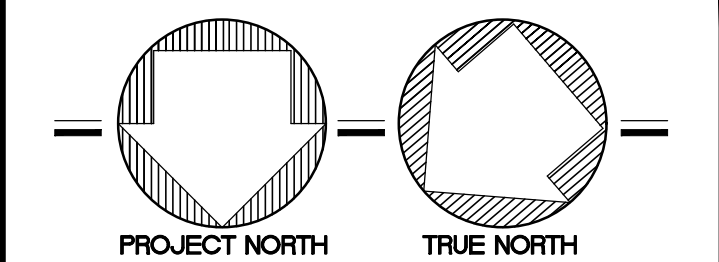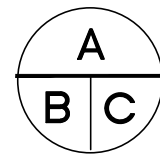

SPRIET ASSOCIATES



LIMITED architects
LONDON LTD. engineers

155 york street - london - N6A 1A8
phone : (519) 672-4100 fax : (519) 433-9351
e-mail : mail@spriet.on.ca

LUCAN BIDDULPH COMMUNITY MEMORIAL CENTRE
PHASE 2 - LUCAN ARENA
RENO'S & ARENA ADDITION
263 & 265 MAIN STREET, LUCAN, ONTARIO

drawing title :

EXTERIOR ELEVATIONS

date : NOV 26, 2021

scale : AS NOTED

drawn by : RPM/MT

project no. : 216255-2

drawing no. :

A20